

LEGEND

RECEPTACLE

THERMOSTAT

SWITCH

LIGHT FIXTURE

RECESSED LIGHT

EXHAUST FAN

PANEL BOX

SOLAR TUBE

AIR SUPPLY

14" RETURN AIR

RETURN AIR GRILLE

OVERHEAD REGISTER

FLOOR REGISTER

CROSS-OVER LOCATION

SUPPORT POST

SHEARWALL

SMOKE ALARM

OPT CO ALARM (STD W/GAS)

A160 x 52'-0"

BX

CX

Cavco

INDUSTRIES, INC.

RIVERSIDE 220

PRODUCT NAME
CANYON LAKE

MODEL NO.
14522L

DRAWING TITLE
CUSTOM
PROD. FLOOR PLAN


DRAWN BY:
Roselyn Q.

DATE:
01/31/22

SHT
FPP.1c

REV

22CL14522L154710

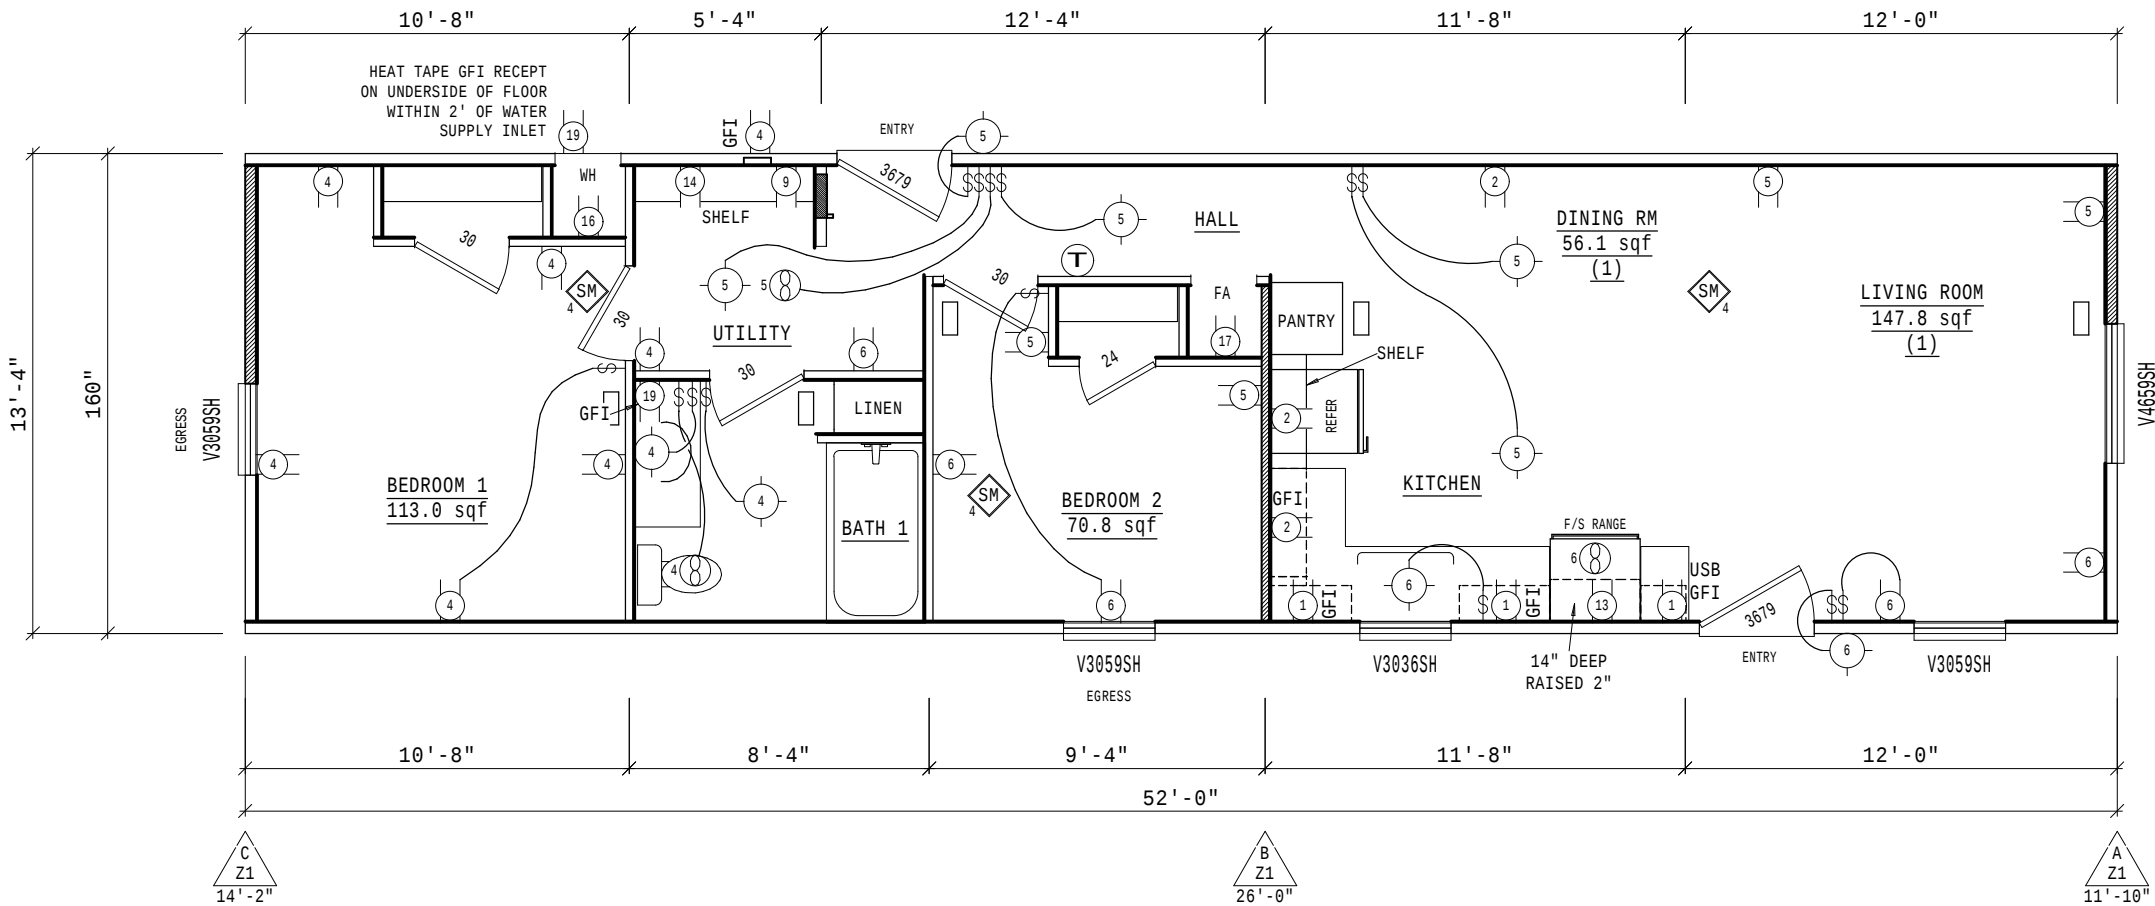


- NOTES:
- RECEPT SHALL NOT BE INSTALLED WITHIN 30" OF TUB/SHOWER SPACE.
 - ELECTRICAL WALL PLATES SHALL NOT BE INSTALLED WITHIN 6" OF A RANGE OR COOKTOP.
 - ROOM TITLES INCLUDING (#) INDICATES SQUARE FOOTAGE HAS BEEN COMBINED FOR GLAZING/VENTING REQUIREMENTS.

THIS FLOOR PLAN AND ATTACHED OPTION DETAILS (IF APPLICABLE) IS DESIGNED TO MEET THE FOLLOWING STRUCTURAL REQUIREMENTS:
WIND ZONE(S) 1 ROOF LOAD(S) 20 LBS.

CUSTOMER: FACTORY SELECT - LEARD
ORDER NO: 154710

PLUMBING SCHEDULE		
CODE	QTY	DESCRIPTION
A	2	ELBOW (45) 1-1/2
B	2	ELBOW (45) 2
C	2	ELBOW (45) 3
C-0	1	CLEANOUT ASSEMBLY 1-1/2
D	5	ELBOW (90-LONG) 1-1/2
F	1	ELBOW (90-LONG) 3
I	2	T-WYE (LONG TURN) 3x3x1-1/2
J	1	T-WYE (LONG TURN) 3x3x2 w/Bush
L	3	SAN. TEE 1-1/2
M	1	SAN. TEE 2 x 1-1/2 x 1-1/2
OUTLET	1	MAIN DRAIN OUTLET
T.FL	1	TOILET FLANGE-OUTBOARD
TRAP	4	P-TRAP w/ 1-1/2 UNION
VENT	3	AUTO-VENT ASSEMBLY
VTR	1	ROOF VENT ASSEMBLY
x45	1	ELBOW (90 DOUBLE) W/ BUSH 1.5

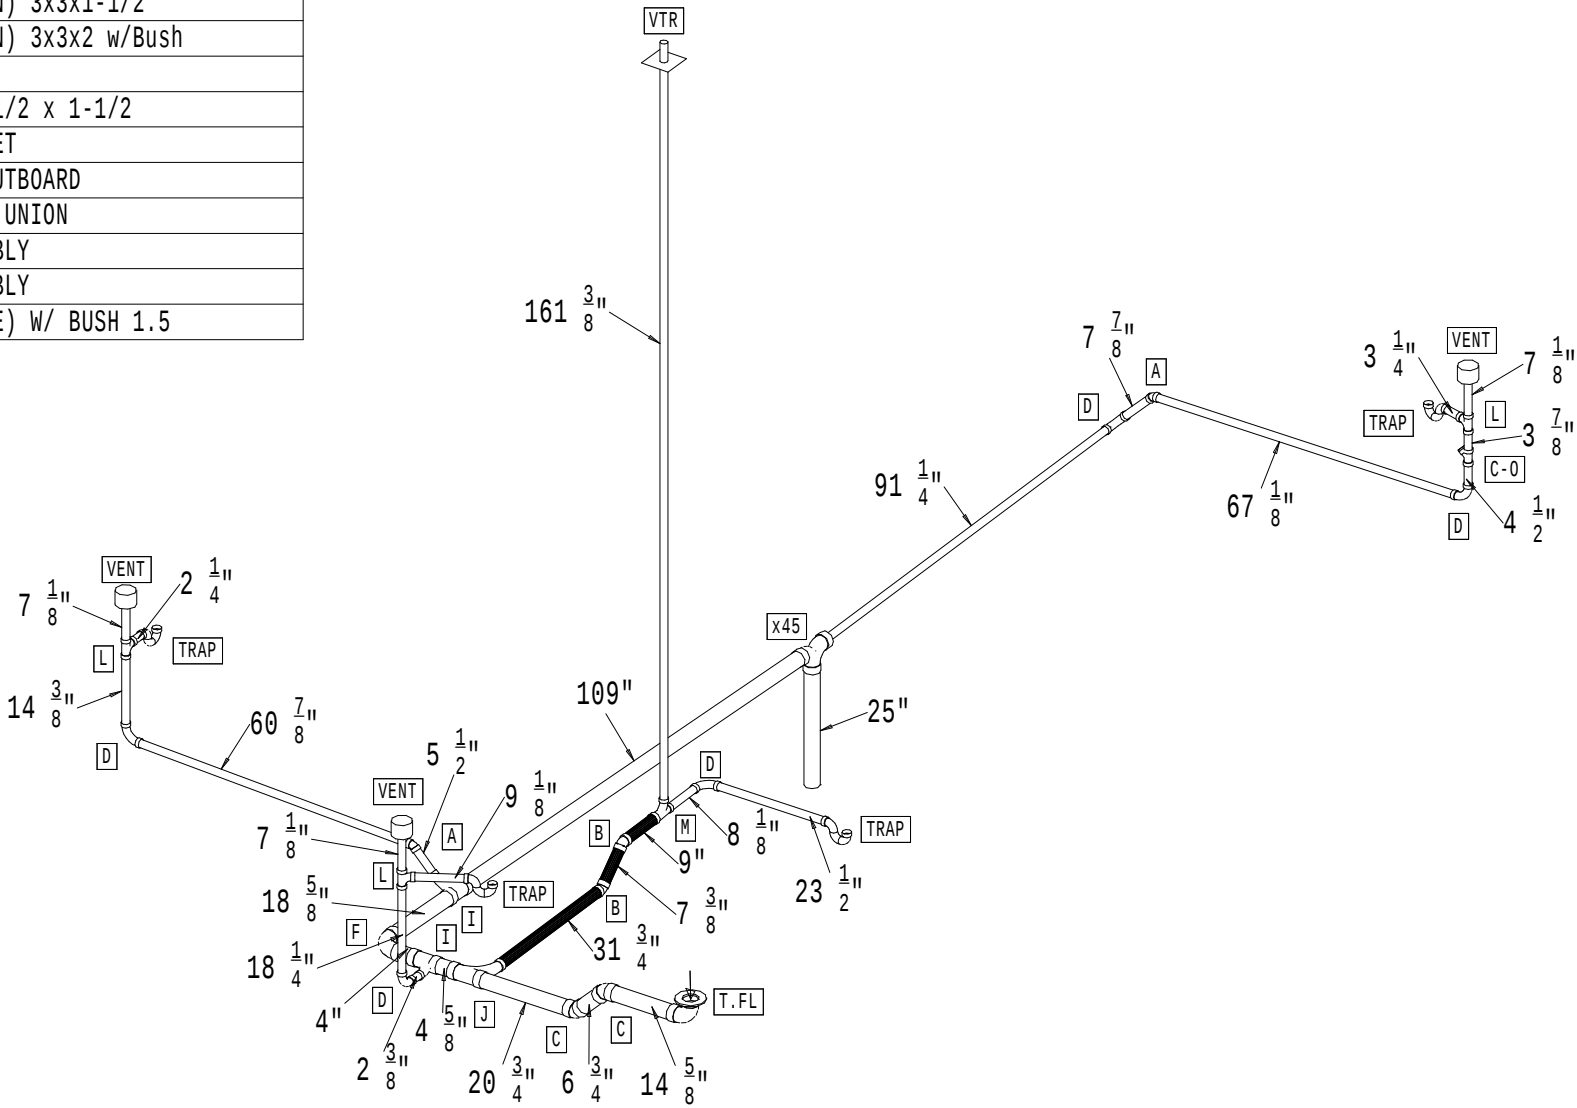

L E G E N D



3 WAY ELL



LTTY



45° WYE



AUTO VENT



SAN TEE



90° ELL



1 1/2" PIPING



2" PIPING



3" PIPING

* INDICATES OPTIONAL SHIP LOOSE PIPE AND ATTACHED FITTINGS.

Cavco

INDUSTRIES, INC.®

RIVERSIDE 220

PRODUCT NAME
CANYON LAKE

MODEL NO.
14522L

DRAWING TITLE
CUSTOM PRODUCTION PLUMBING DRAIN

DRAWN BY:
Roselyn Q.

DATE:
01/31/22

SHT
PPD.1c

REV


22CL14522L154710

CUSTOMER: FACTORY SELECT - LEARD

ORDER NO: 154710


ORD#154710/CUSTOMER:FACTORY SELE

PLUMBING SCHEDULE		
CODE	QTY	DESCRIPTION
E-1/2	5	ELBOW-90 1/2 x 1/2
E-3/4	1	ELBOW-90 3/4 x 3/4
T-1/2	3	TEE 1/2 x 1/2 x 1/2
T-3/4	1	TEE 3/4 x 3/4 x 3/4
TR-3/4x1/2x1/2	1	TEE 3/4 x 1/2 x 1/2

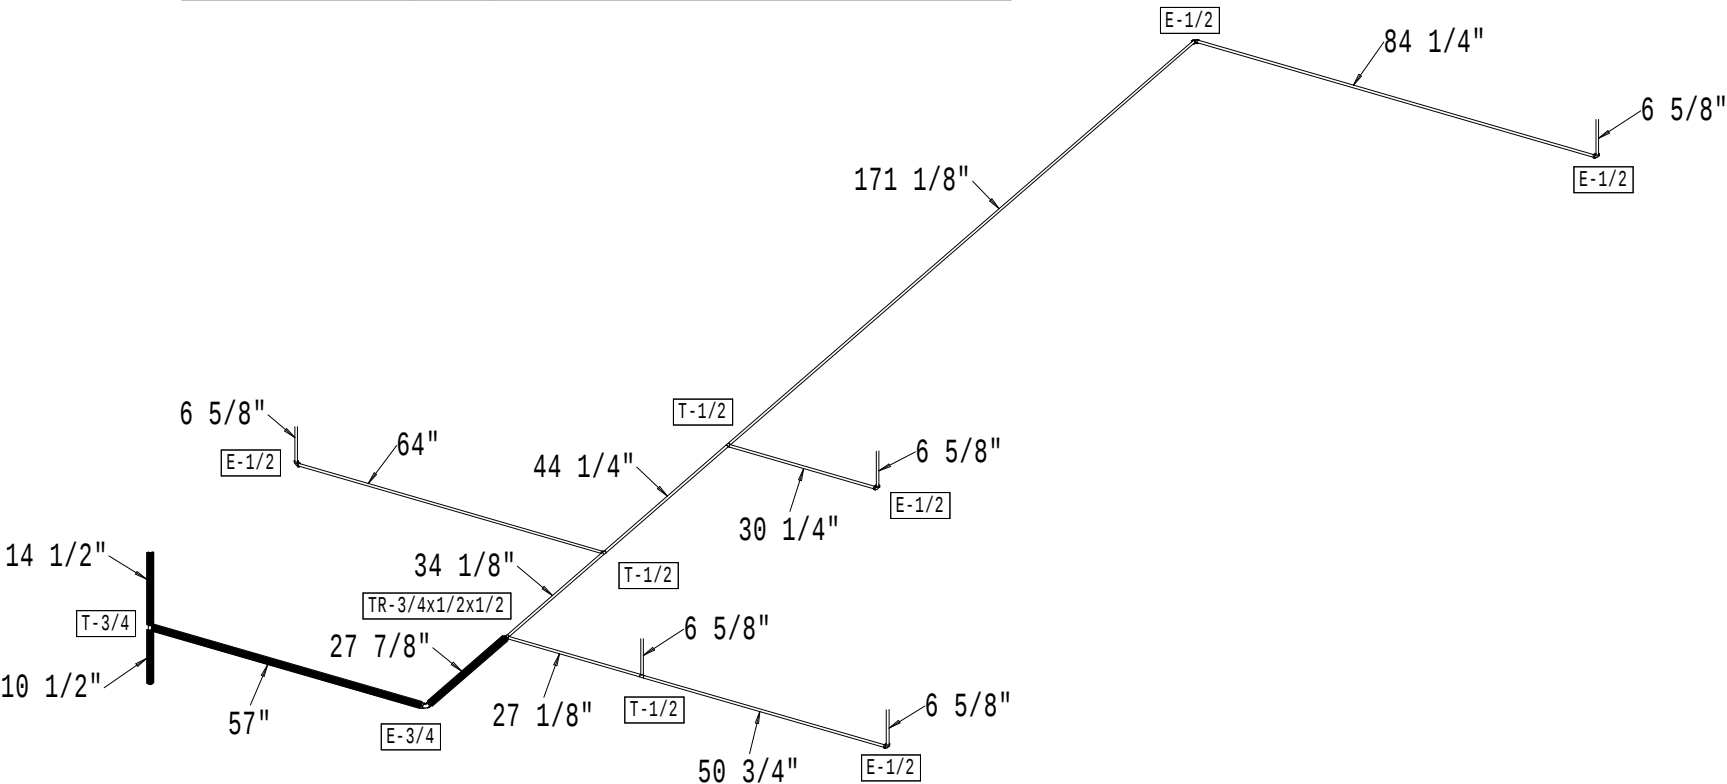

COLD WATER PLUMBING

PLUMBING SCHEDULE		
CODE	QTY	DESCRIPTION
E-1/2	6	ELBOW-90 1/2 x 1/2
E-3/4-1/2	1	ELBOW-90 3/4 x 1/2
T-1/2	3	TEE 1/2 x 1/2 x 1/2

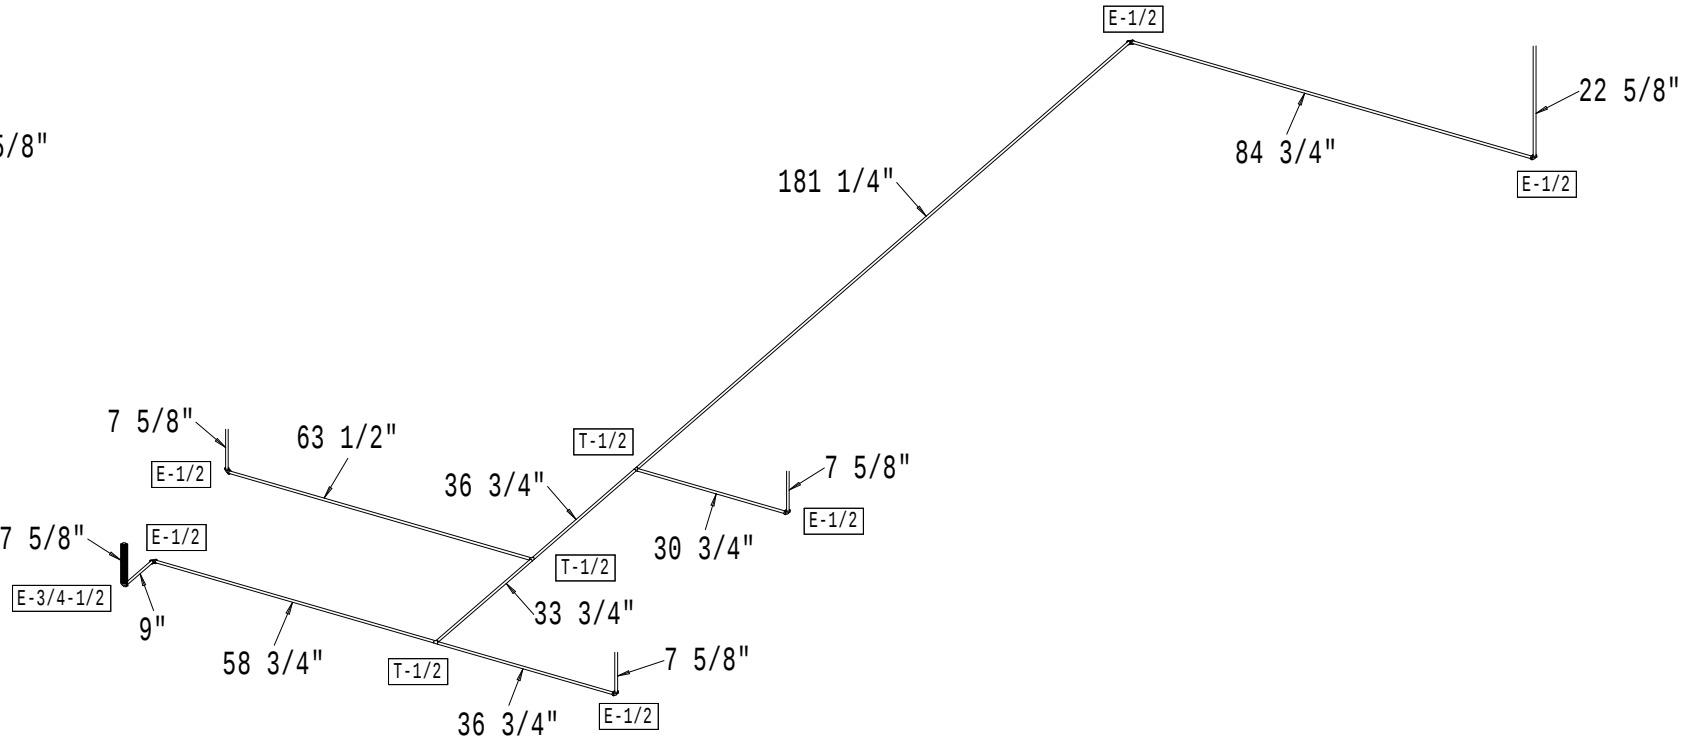

HOT WATER PLUMBING

CUSTOMER: FACTORY SELECT - LEARD
ORDER NO: 154710

ORD#154710/CUSTOMER:FACTORY SELE

LEGEND

TEE

90° ELL

1/2" PIPING

3/4" PIPING

FOR PEX PIPING, SEE
ENG. PG. 35-01-0003

Cavco
INDUSTRIES, INC.®

RIVERSIDE
220

PRODUCT NAME
CANYON LAKE

MODEL NO.
14522L

DRAWING TITLE
CUSTOM
PRODUCTION
PLUMBING WATER


DRAWN BY:
Roselyn Q.

DATE:
01/31/22

SHT
PPW.1c

REV

22CL14522L154710

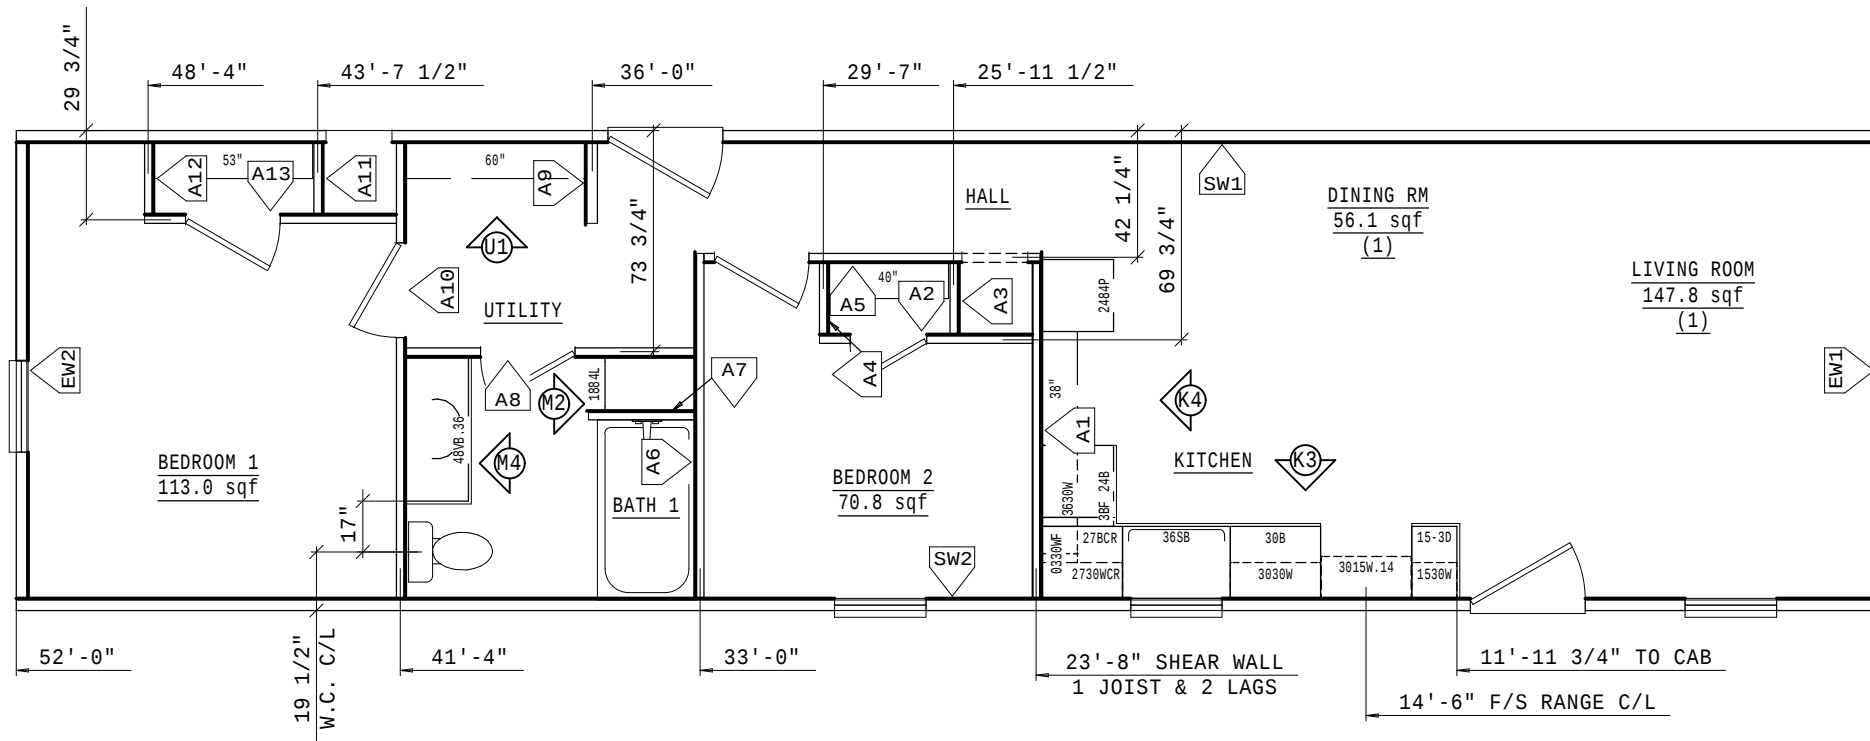


Cavco INDUSTRIES, INC.	
RIVERSIDE 220	
PRODUCT NAME CANYON LAKE	
MODEL NO. 14522L	
DRAWING TITLE CUSTOM WALL LOCATION	
DRAWN BY: Roselyn Q.	
DATE: 01/31/22	
SHT WL.1c	REV

CUSTOMER: FACTORY SELECT - LEARD
ORDER NO: 154710

ORD#154710/CUSTOMER:FACTORY SELE


22CL14522L154710

SW1

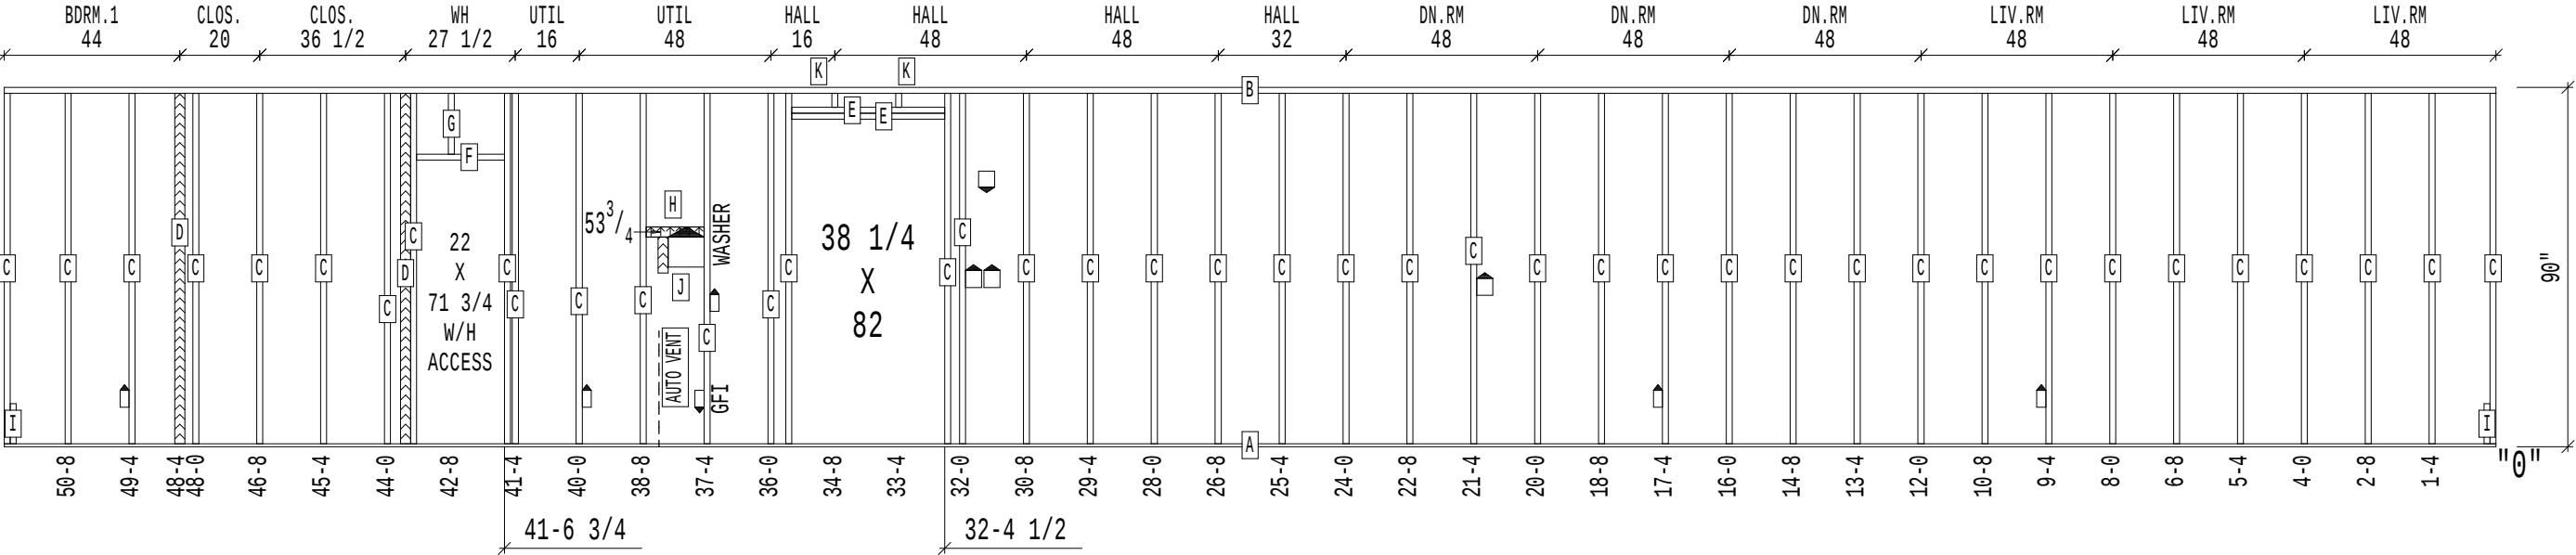






CUT LIST	
A	1 1x4 PL 624
B	1 1x4 PL 624
C	41 2x4 STUD 87 3/4
D	2 1x3 STUD 87 3/4
E	2 2x4 STUD 38 1/4
F	1 2x4 STUD 22
G	1 2x4 STUD 15 1/4
H	1 1x3 PL 14 1/2
I	2 2x4 STUD 10
J	1 1x3 STUD 9
K	2 2x4 STUD 3 1/2

SW2

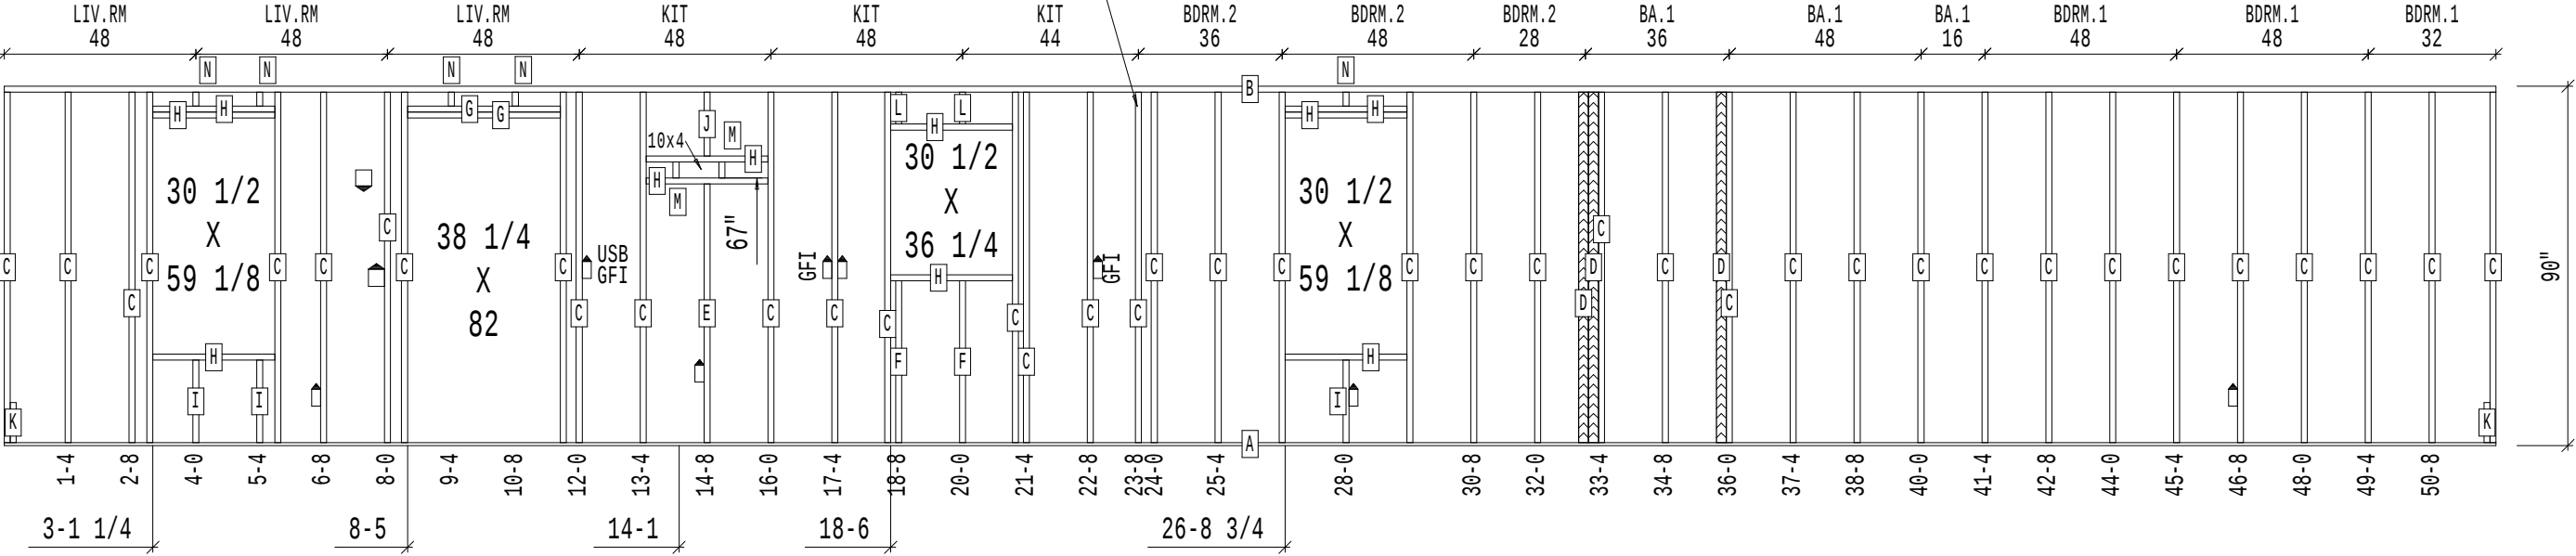

CUT LIST	
A	1 1x4 PL 624
B	1 1x4 PL 624
C	39 2x4 STUD 87 3/4
D	3 1x3 STUD 87 3/4
E	1 2x4 STUD 64 3/4
F	2 2x4 STUD 40 1/2
G	2 2x4 STUD 38 1/4
H	10 2x4 STUD 30 1/2
I	3 2x4 STUD 20 5/8
J	1 2x4 STUD 16
K	2 2x4 STUD 10
L	2 2x4 STUD 8
M	2 2x4 STUD 4
N	5 2x4 STUD 3 1/2

  L E G E N D

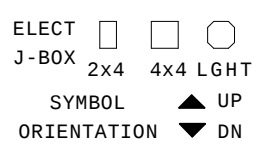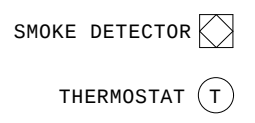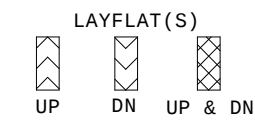

NOTE:
1. ALL OPENING DIMS.
ARE TO THE EDGE OF
STUD.

Cavco
INDUSTRIES, INC.

RIVERSIDE
220

PRODUCT NAME
CANYON LAKE

MODEL NO.
14522L

DRAWING TITLE
CUSTOM
SIDE WALLS

DRAWN BY:
Roselyn Q.

DATE:
01/31/22

L.L. 30, SHT SW.1E.1c

W.Z. 1, REV

CUSTOMER: FACTORY SELECT - LEARD
ORDER NO: 154710


ORD#154710/CUSTOMER:FACTORY SELE

22CL14522L154710

EW1

CUT LIST


- A 1 1x4 PL 152
- B 2 2x4 PL 77 1/2
- C 2 2x4 STUD 99 1/2
- D 2 2x4 STUD 99 1/4
- E 1 2x4 STUD 98 5/8
- F 1 2x4 STUD 97
- G 1 2x4 STUD 95 1/4
- H 1 2x4 STUD 93 1/2
- I 1 2x4 STUD 91 3/4
- J 1 2x4 STUD 90
- K 2 2x4 STUD 88 3/8
- L 1 2x4 2SPF 46 1/2
- M 1 2x4 STUD 46 1/2
- N 1 2x4 STUD 22
- O 1 2x4 STUD 21 1/8
- P 3 2x4 STUD 20 5/8
- Q 1 2x4 STUD 19 3/8
- R 1 2x4 STUD 17 5/8

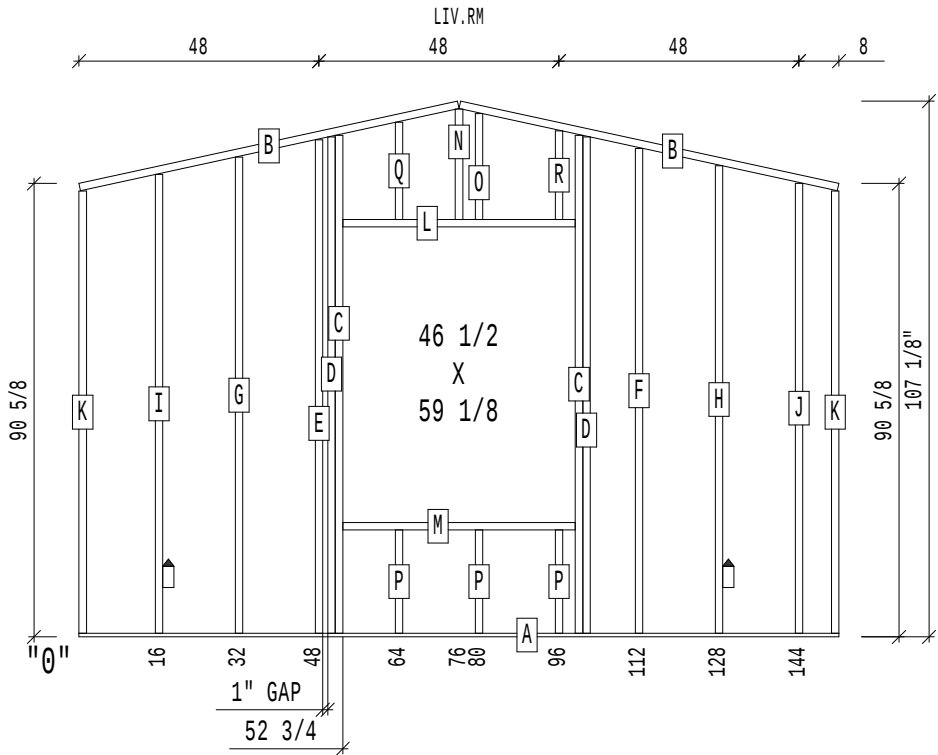

EW2

CUT LIST

- A 1 1x4 PL 152
- B 2 2x4 PL 77 1/2
- C 1 2x4 STUD 103 7/8
- D 1 2x4 STUD 100 3/8
- E 1 2x4 STUD 98 5/8
- F 1 2x4 STUD 97
- G 1 2x4 STUD 95 1/4
- H 1 2x4 STUD 93 1/2
- I 1 2x4 STUD 91 3/4
- J 1 2x4 STUD 90
- K 2 2x4 STUD 88 3/8
- L 1 2x4 2SPF 30 1/2
- M 1 2x4 STUD 30 1/2
- N 1 2x4 STUD 22
- O 1 2x4 STUD 20 5/8
- P 1 2x4 STUD 19 3/8
- Q 1 2x4 PL 10

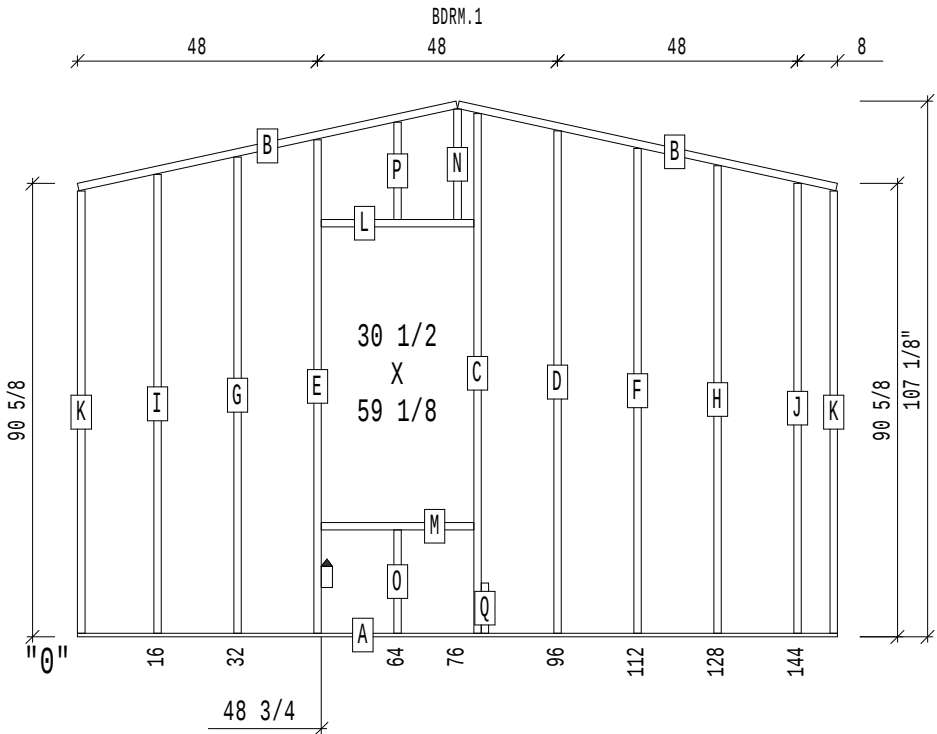

LEGEND

LAYFLAT(S)

UP DN UP & DN

HORIZ. BLK'G DIR.

UP DN UP & DN

SMOKE DETECTOR

THERMOSTAT

WASHER PANEL RETURN BOX AIR

ELECT J-BOX 2x4 4x4 LGHT

SYMBOL ORIENTATION

UP DN

NOTE:

1. ALL OPENING DIMS. ARE TO THE EDGE OF STUD.



RIVERSIDE 220

PRODUCT NAME

CANYON LAKE

MODEL NO.

14522L

DRAWING TITLE

CUSTOM END WALLS

DRAWN BY:

Roselyn Q.

DATE:

01/31/22

L.L.	SHT
20	EW.1C.1c
W.Z.	REV
1	

CUSTOMER: FACTORY SELECT - LEARD

ORDER NO: 154710


ORD#154710/CUSTOMER:FACTORY SELE

22CL14522L154710

A1

CUT LIST

A	1	1x3	PL	112
B	1	1x3	PL	77 5/8
C	1	1x3	PL	36 5/8
D	1	2x3	STUD	105 1/2
E	1	2x3	STUD	104 5/8
F	1	1x3	STUD	103 1/2
G	1	1x3	STUD	102 7/8
H	1	2x3	STUD	101 1/4
I	1	2x3	STUD	99 1/2
J	1	2x3	STUD	97 7/8
K	1	2x3	STUD	94 1/4
L	1	2x3	STUD	89 1/8
M	6	1x3	STUD	22 1/2
N	3	1x3	STUD	21 3/4
O	2	2x3	STUD	13 3/4
P	2	2x3	STUD	12

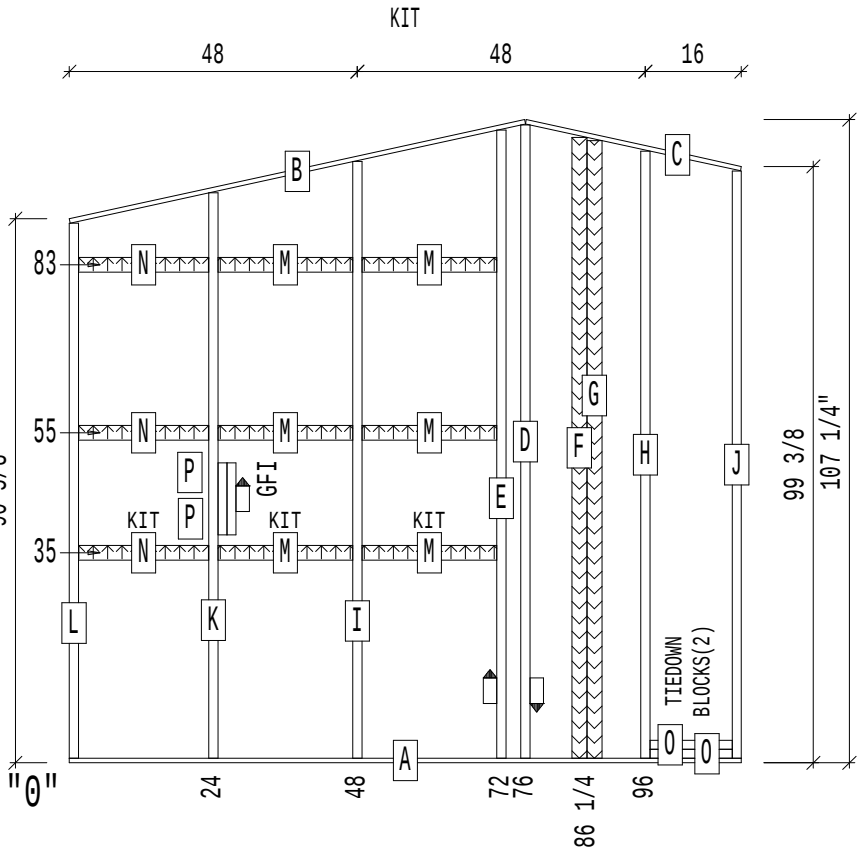


SHEAR PANEL

A2

CUT LIST

A	2	1x3	PL	71
B	5	2x3	STUD	103 1/8
C	1	1x3	STUD	103 1/8
D	1	2x3	2SPF	25 1/2
E	3	2x3	STUD	19 3/8

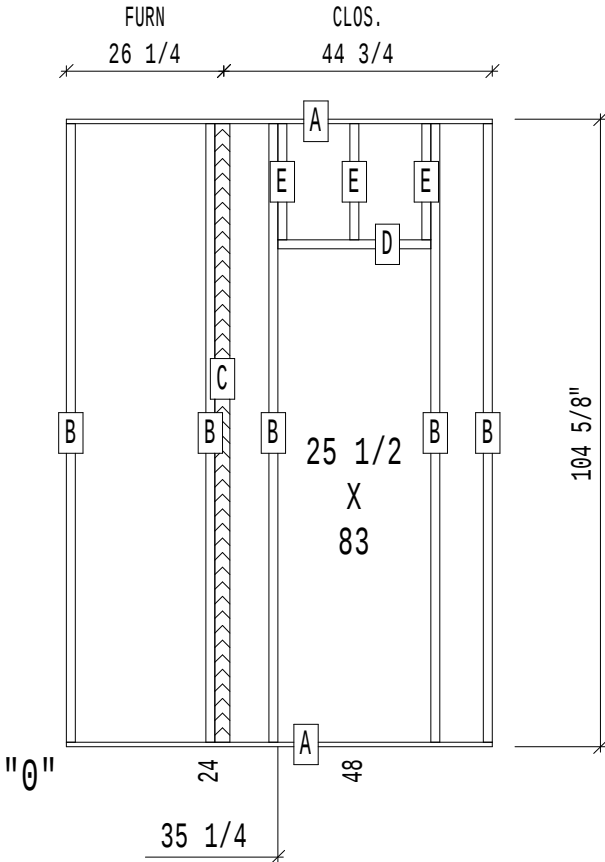


WEDGE DOWN

A3

CUT LIST


A	1	1x3	PL	24
B	1	1x3	PL	24 3/8
C	1	2x3	STUD	102 3/4
D	1	2x3	STUD	97 7/8
E	1	1x3	STUD	21

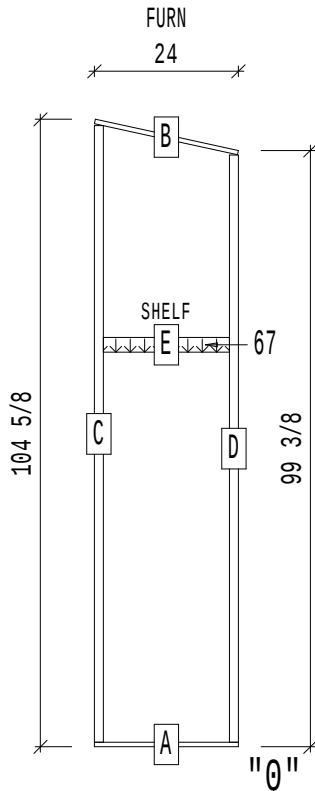

A4

CUT LIST


A	1	1x3	PL	24
B	1	1x3	PL	24 3/8
C	1	2x3	STUD	102 3/4
D	1	2x3	STUD	97 7/8
E	1	1x3	STUD	21

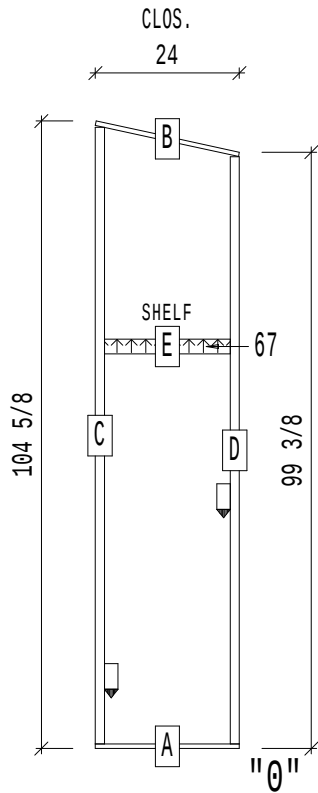

A5

CUT LIST

A	2	1x3	PL	112
B	8	2x3	STUD	97 1/4
C	2	1x3	STUD	97 1/4
D	1	2x3	2SPF	31 1/2
E	1	2x3	2SPF	22
F	3	2x3	STUD	13 1/2
G	3	2x3	STUD	6 1/2

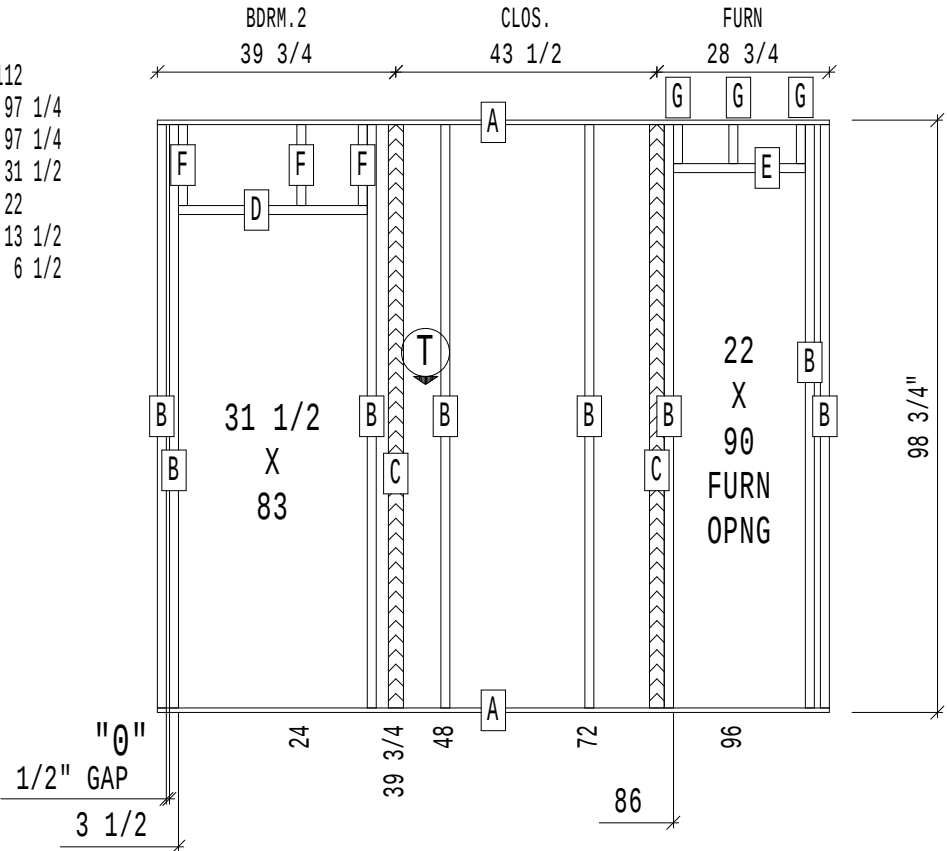

WEDGE UP

L E G E N D

LAYFLAT(S)
UP DN UP & DN

HORIZ. BLK'G DIR.
UP DN UP & DN

SMOKE DETECTOR

THERMOSTAT

W PB RA
WASHER PANEL RETURN
BOX AIR

ELECT J-BOX 2x4 4x4 LGT
SYMBOL UP DN
ORIENTATION

NOTE:
1. ALL OPENING DIMS.
ARE TO THE EDGE OF
STUD.

Cavco
INDUSTRIES, INC.

RIVERSIDE
220

PRODUCT NAME
CANYON LAKE

MODEL NO.
14522L

DRAWING TITLE
CUSTOM
INTERIOR WALLS

DRAWN BY:
Roselyn Q.

DATE: 01/31/22

L.L. SHT
---- IW.1c

W.Z. REV

CUSTOMER: FACTORY SELECT - LEARD
ORDER NO: 154710


ORD#154710/CUSTOMER:FACTORY SELE

22CL14522L154710

A6

CUT LIST


A	1	1x3	PL	115
B	1	1x3	PL	77 5/8
C	1	1x3	PL	39 3/4
D	1	2x3	STUD	105 1/2
E	1	2x3	STUD	104 5/8
F	1	1x3	STUD	104 1/8
G	1	1x3	STUD	102 1/8
H	1	1x3	STUD	101 5/8
I	1	2x3	STUD	101 1/4
J	1	2x3	STUD	99 1/2
K	1	1x3	STUD	97 1/2
L	1	2x3	STUD	97 1/4
M	1	2x3	STUD	94 1/4
N	1	1x3	STUD	89 1/2
O	1	2x3	STUD	89 1/8
P	1	1x3	STUD	9 1/4
Q	1	1x3	STUD	4 1/4
R	1	1x3	STUD	2 1/2

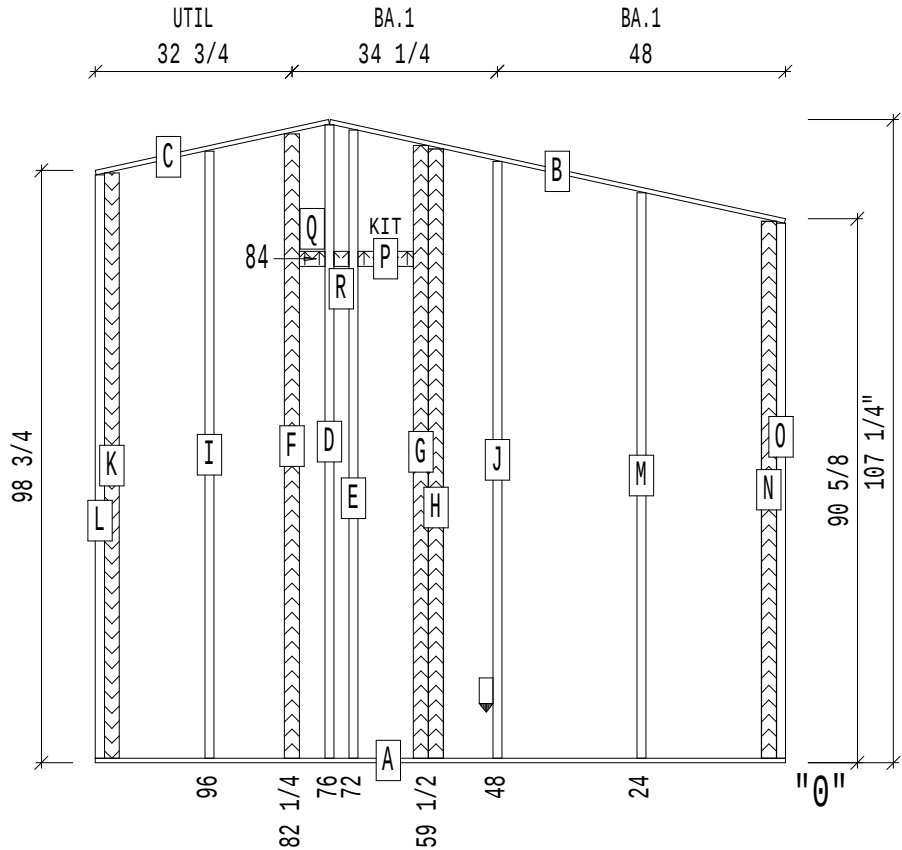

A7

CUT LIST

A	2	1x3	PL	35 1/2
B	3	2x3	STUD	102 1/8
C	2	1x3	STUD	102 1/8
D	1	1x3	STUD	21 3/4
E	1	1/2	PLY	19 1/4

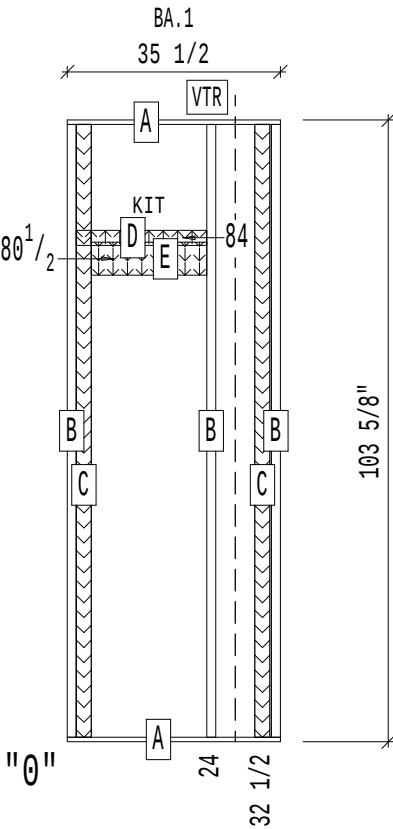


WEDGE UP

A8

CUT LIST

A	2	1x3	PL	96 1/2
B	5	2x3	STUD	104 1/8
C	1	2x3	2SPF	31 1/2
D	1	1x3	STUD	22 1/4
E	1	1x3	STUD	22
F	3	2x3	STUD	20 3/8

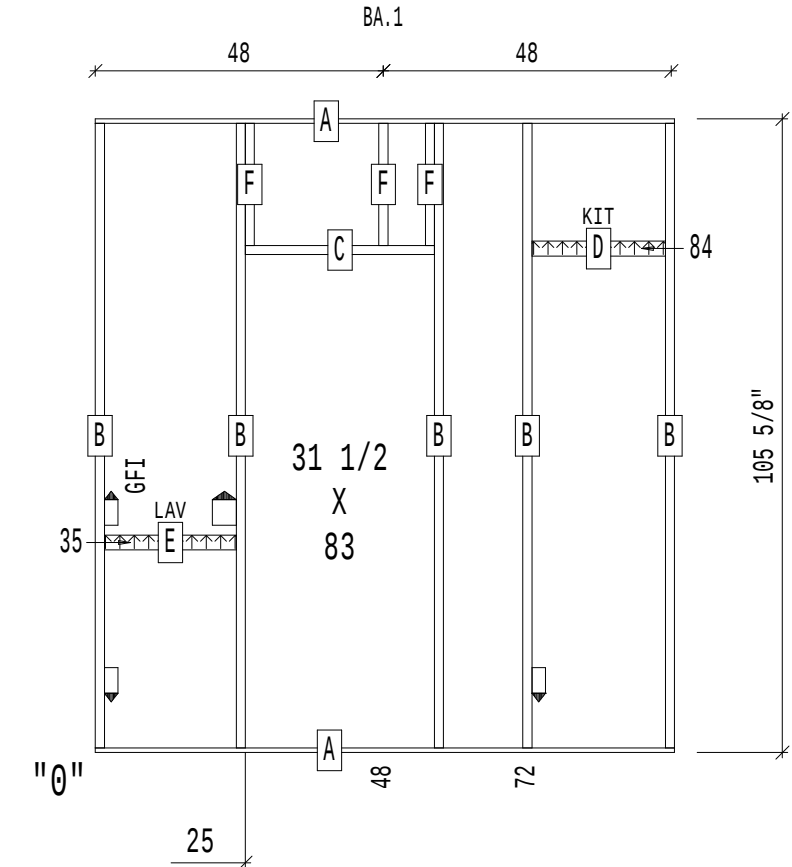


WEDGE UP


A9

CUT LIST

A	1	1x4	PL	27
B	1	1x4	PL	27 1/2
C	1	2x4	STUD	94 3/4
D	1	2x4	STUD	93
E	1	2x4	STUD	89 1/2
F	1	2x4	STUD	89 1/8
G	1	1x3	STUD	14 1/2

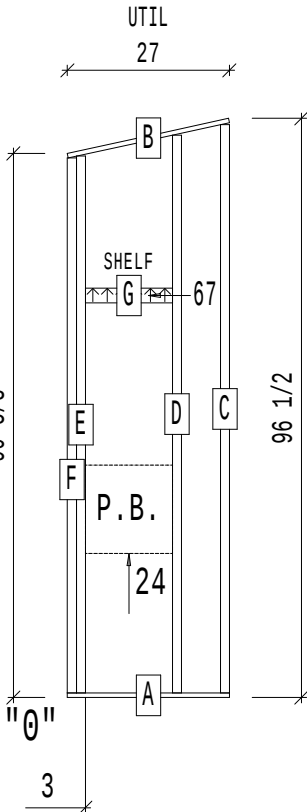

L E G E N D

 

SMOKE DETECTOR

THERMOSTAT

WASHER PANEL RETURN BOX AIR

ELECT J-BOX 2x4 4x4 LGHT SYMBOL ORIENTATION

NOTE: 1. ALL OPENING DIMS. ARE TO THE EDGE OF STUD.

Cavco INDUSTRIES, INC. RIVERSIDE 220

PRODUCT NAME CANYON LAKE

MODEL NO. 14522L

DRAWING TITLE CUSTOM INTERIOR WALLS

DRAWN BY: Roselyn Q.

DATE: 01/31/22

L.L. SHT ---- IW.2c

W.Z. REV ----

CUSTOMER: FACTORY SELECT - LEARD ORDER NO: 154710


ORD#154710/CUSTOMER:FACTORY SELE

22CL14522L154710

A10

CUT LIST


A	1	1x3	PL	152
B	2	1x3	PL	77 5/8
C	1	2x3	STUD	105 1/2
D	1	2x3	STUD	104 5/8
E	1	1x3	STUD	104 1/8
F	1	2x3	STUD	103 3/8
G	1	2x3	STUD	99 1/2
H	1	2x3	STUD	96 1/8
I	1	1x3	STUD	94 3/4
J	1	2x3	STUD	94 1/4
K	1	1x3	STUD	94 1/4
L	1	2x3	STUD	90 3/4
M	2	2x3	STUD	89 1/8
N	1	2x3	2SPF	31 1/2
O	2	1x3	STUD	22 1/2
P	1	2x3	STUD	19 1/4
Q	1	2x3	STUD	17 1/2
R	1	1x3	STUD	14 1/2
S	1	2x3	STUD	12 3/4
T	1	1x3	STUD	5 3/4
U	1	1x3	STUD	4 1/4
V	1	1x3	STUD	2 1/2

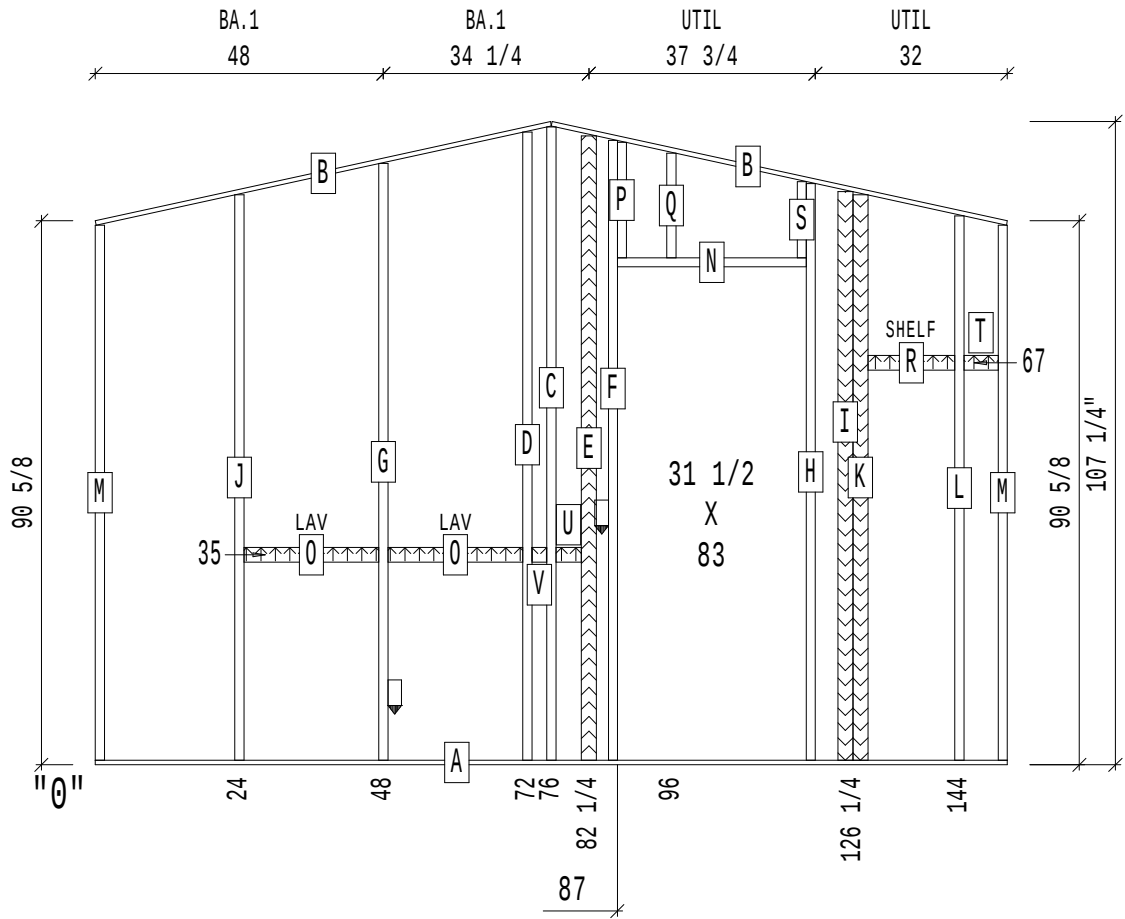

A11

CUT LIST


A	1	1x3	PL	24
B	1	1x3	PL	24 3/8
C	1	2x3	STUD	94 1/8
D	1	2x3	STUD	89 1/8
E	1	1x3	STUD	21

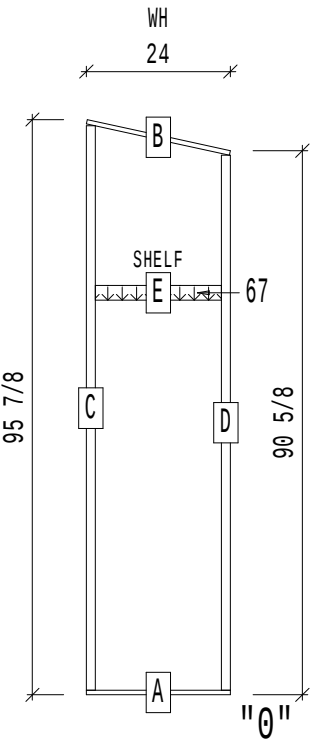

A12

CUT LIST


A	1	1x3	PL	24
B	1	1x3	PL	24 3/8
C	1	2x3	STUD	94 1/8
D	1	2x3	STUD	89 1/8
E	1	1x3	STUD	21

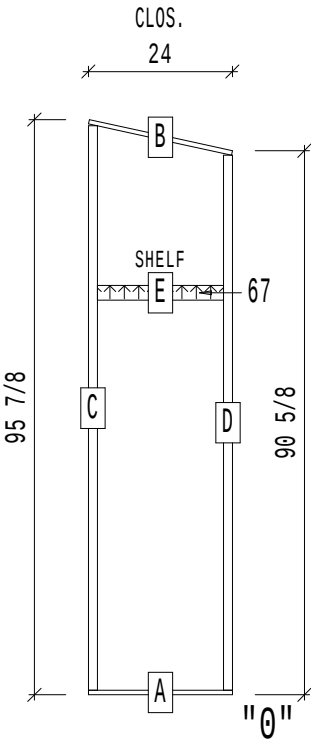

A13

CUT LIST

A	2	1x3	PL	84
B	5	2x3	STUD	94 3/8
C	1	1x3	STUD	94 3/8
D	1	2x3	2SPF	31 1/2
E	3	2x3	STUD	10 5/8

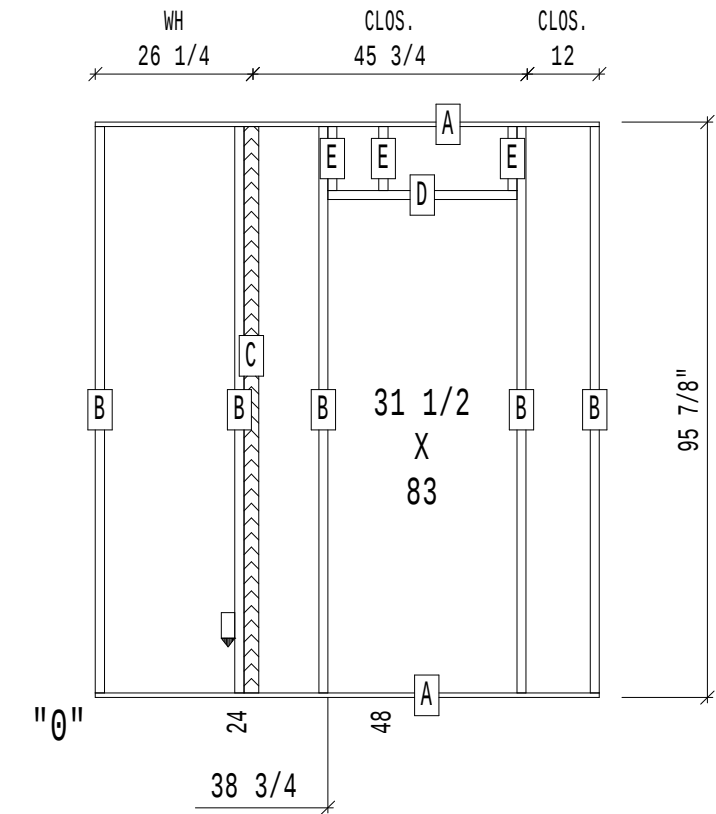

WEDGE DOWN

L E G E N D

LAYFLAT(S)

UP DN UP & DN

HORIZ. BLK'G DIR.

UP DN UP & DN

SMOKE DETECTOR

THERMOSTAT

WASHER

PANEL BOX

RETURN AIR

ELECT J-BOX

2x4 4x4 LGT

SYMBOL

ORIENTATION

UP

DN

NOTE:

1. ALL OPENING DIMS. ARE TO THE EDGE OF STUD.

Cavco INDUSTRIES, INC.

RIVERSIDE 220

PRODUCT NAME

CANYON LAKE

MODEL NO.

14522L

DRAWING TITLE

CUSTOM INTERIOR WALLS

DRAWN BY:

Roselyn Q.

DATE:

01/31/22

L.L.

SH

W.Z.

REV

CUSTOMER: FACTORY SELECT - LEARD




ORDER NO: 154710

ORD#154710/CUSTOMER:FACTORY SELE


22CL14522L154710




U1

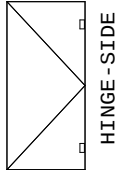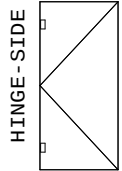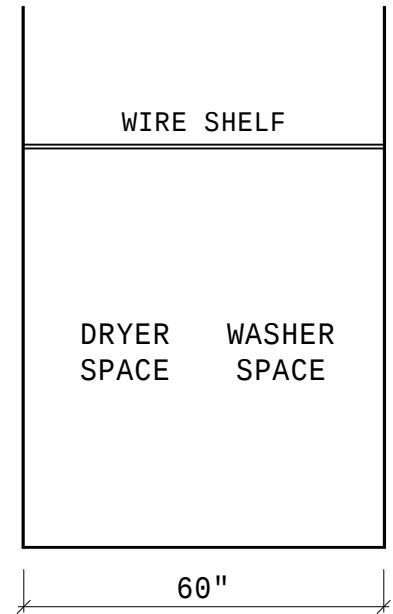


K3

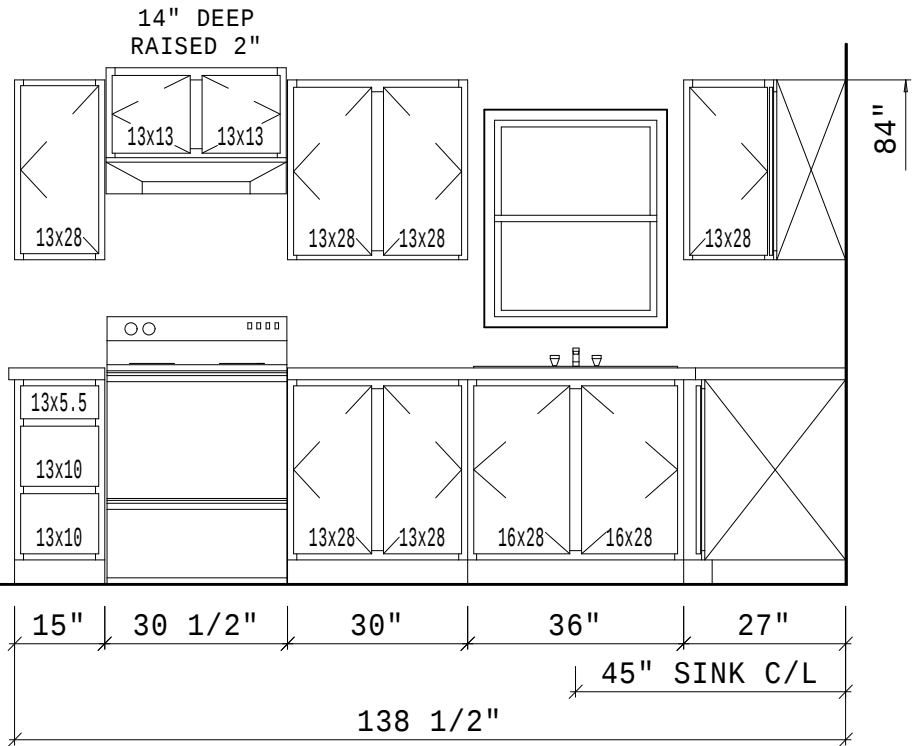


K4

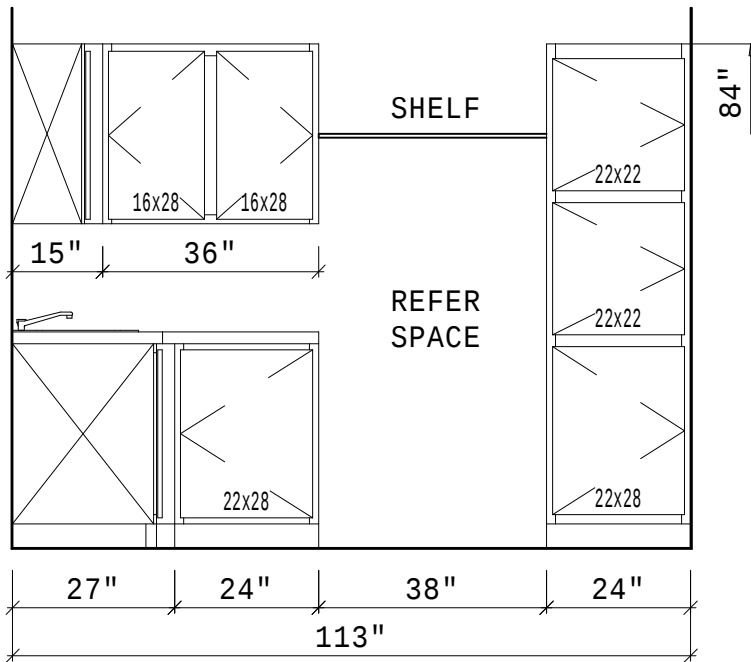

M2

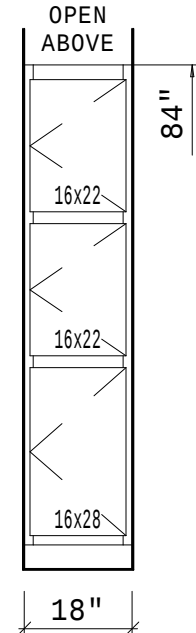

M4

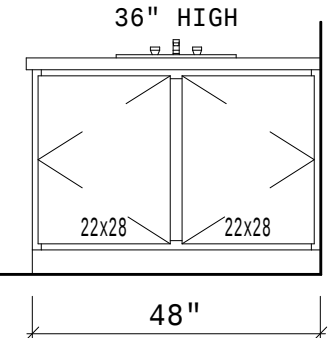

CUSTOMER: FACTORY SELECT - LEARD
ORDER NO: 154710

ORD#154710/CUSTOMER:FACTORY SELE

Cavco
INDUSTRIES, INC.®

RIVERSIDE
220

PRODUCT NAME
CANYON LAKE

MODEL NO.
14522L

DRAWING TITLE
CUSTOM
CABINET
ELEVATIONS


DRAWN BY:
Roselyn Q.

DATE: 01/31/22


SHT
CE.1c

REV


22CL14522L154710

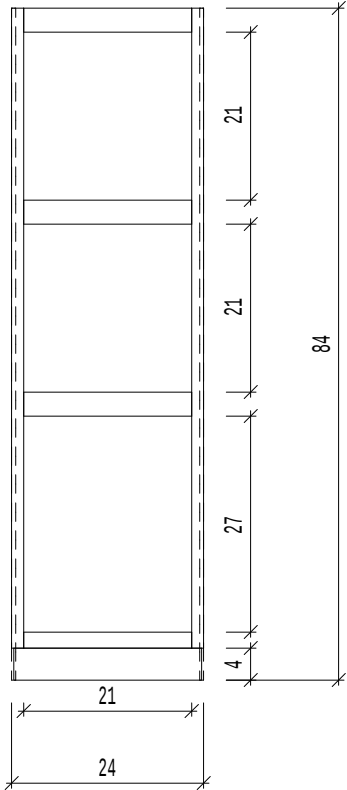


2484P

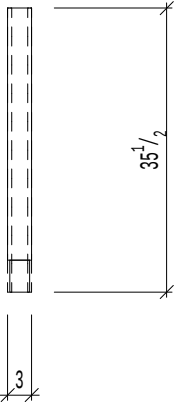


3BF

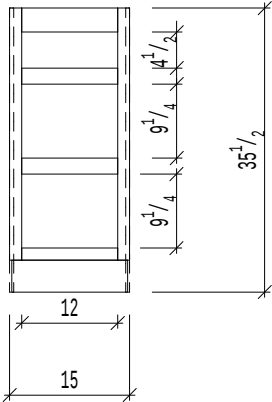


15 - 3D

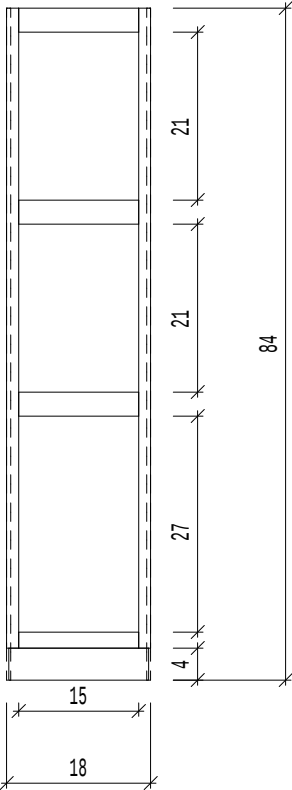


1884L

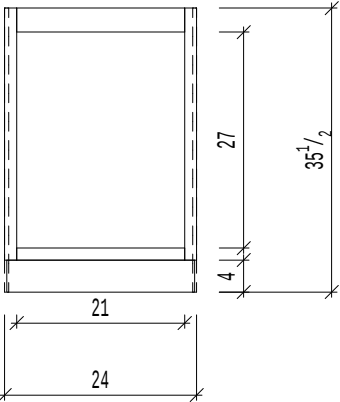


24B

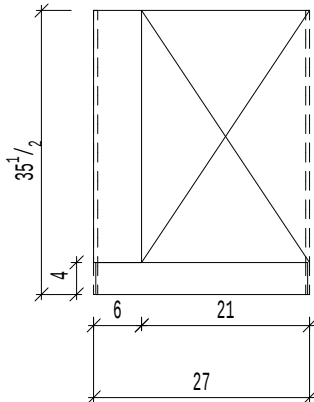


27BCR

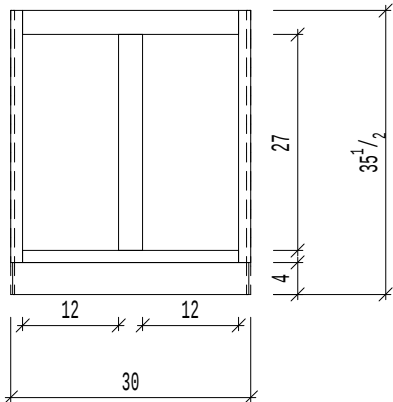


30B

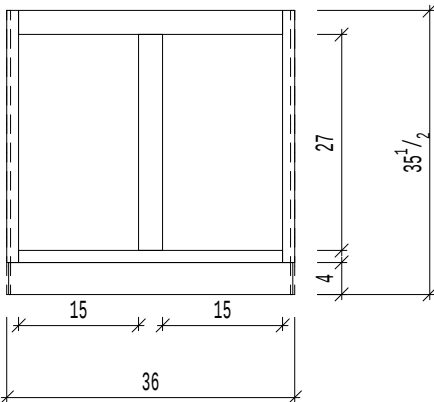

36SB

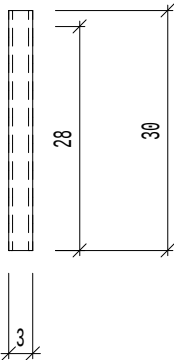

0330WF

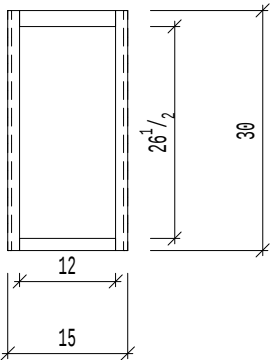

1530W

CUSTOMER: FACTORY SELECT - LEARD
ORDER NO: 154710

ORD#154710/CUSTOMER:FACTORY SELE

Cavco
INDUSTRIES, INC.

RIVERSIDE
220

PRODUCT NAME
CANYON LAKE

MODEL NO.
14522L

DRAWING TITLE
CUSTOM
CABINET FRAMING


DRAWN BY:
Roselyn Q.

DATE: 01/31/22


SHT
CF.1c

REV


22CL14522L154710

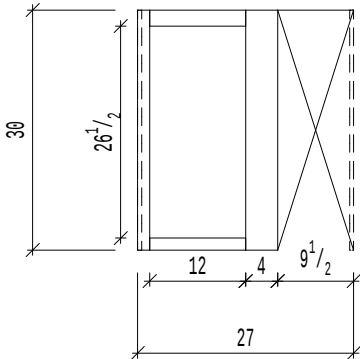


2730WCR

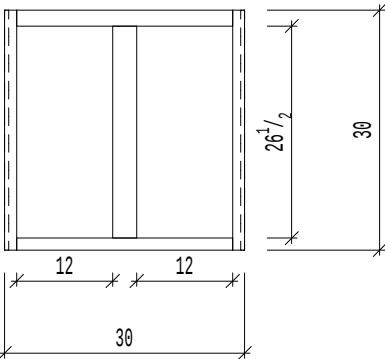


3030W

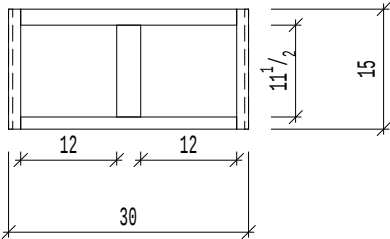

3015W.14

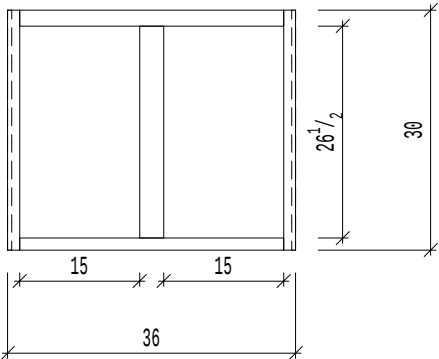

3630W

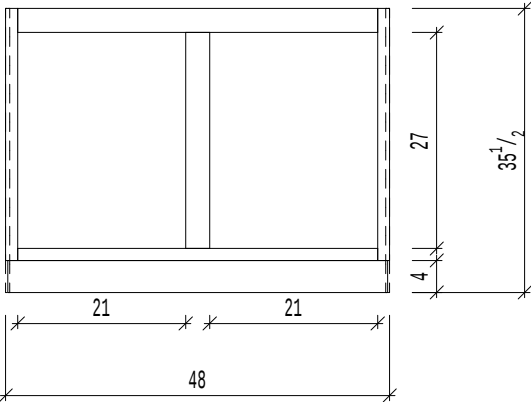

48VB.36

CUSTOMER: FACTORY SELECT - LEARD
ORDER NO: 154710

ORD#154710/CUSTOMER:FACTORY SELE

Cavco

INDUSTRIES, INC.

RIVERSIDE
220

PRODUCT NAME

CANYON LAKE

MODEL NO.

14522L

DRAWING TITLE

CUSTOM
CABINET FRAMING

DRAWN BY:


Roselyn Q.

DATE:

01/31/22

SHT	REV
CF.2c	

22CL14522L154710

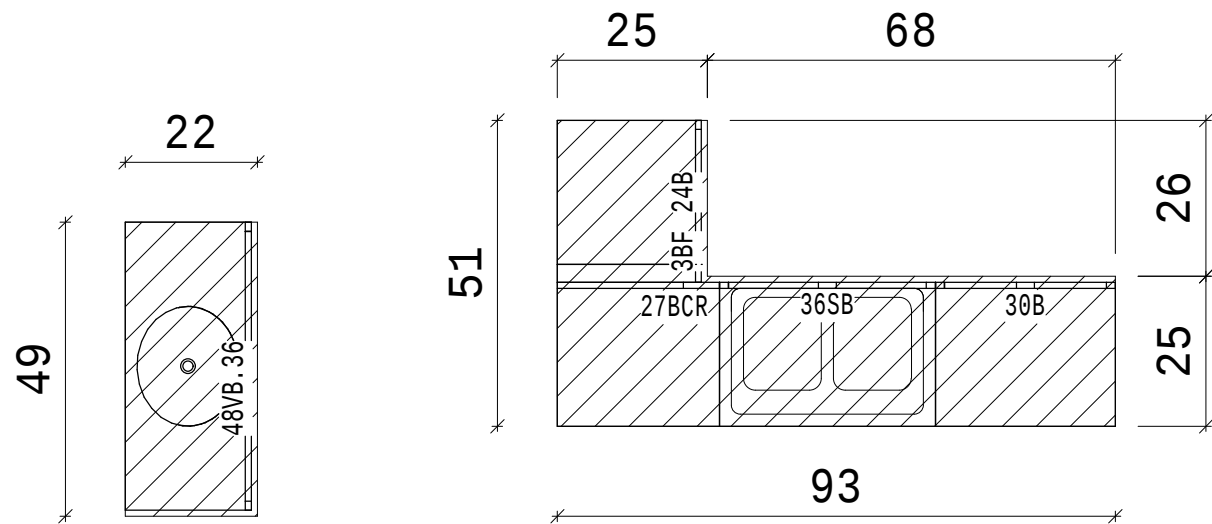

BATH 1
7.49 s.f.

KITCHEN
20.66 s.f.

KITCHEN
2.78 s.f.

CUSTOMER: FACTORY SELECT - LEARD
ORDER NO: 154710

ORD#154710/CUSTOMER:FACTORY SELE

Cavco INDUSTRIES, INC.®	
RIVERSIDE 220	
PRODUCT NAME CANYON LAKE	
MODEL NO. 14522L	
DRAWING TITLE CUSTOM COUNTERTOPS	
DRAWN BY: Roselyn Q.	
DATE: 01/31/22	
SHT CT.1c	REV

22CL14522L154710

[illegible]

52' - 0" CATHEDRAL

CEILING/ROOF INFO	
RAFTER CODE (CATH)	FLC5-160S-4A(08)
RAFTER CODE (FLAT)	
RAFTER CODE (MID)	
RAFTER SPACING	24"
CEILING THICKNESS	1/2"
CEILING MATERIAL	US GYP
FRONT EAVE 0'HANG	6"
REAR EAVE 0'HANG	6"
FRONT GABLE 0'HG	12"
REAR GABLE 0'HG	0

RIVERSIDE
220

PRODUCT NAME

CANYON LAKE

MODEL NO.

14522L

DRAWING TITLE

CUSTOM
ROOF FRAMING

DRAWN BY:
Roselyn Q.

DATE: 01/31/22

SHT	REV
-----	-----


RF.1c

REV


ORDER NO: 154710

ORD#154710/CUSTOMER:FACTORY SELE

22CL14522L154710

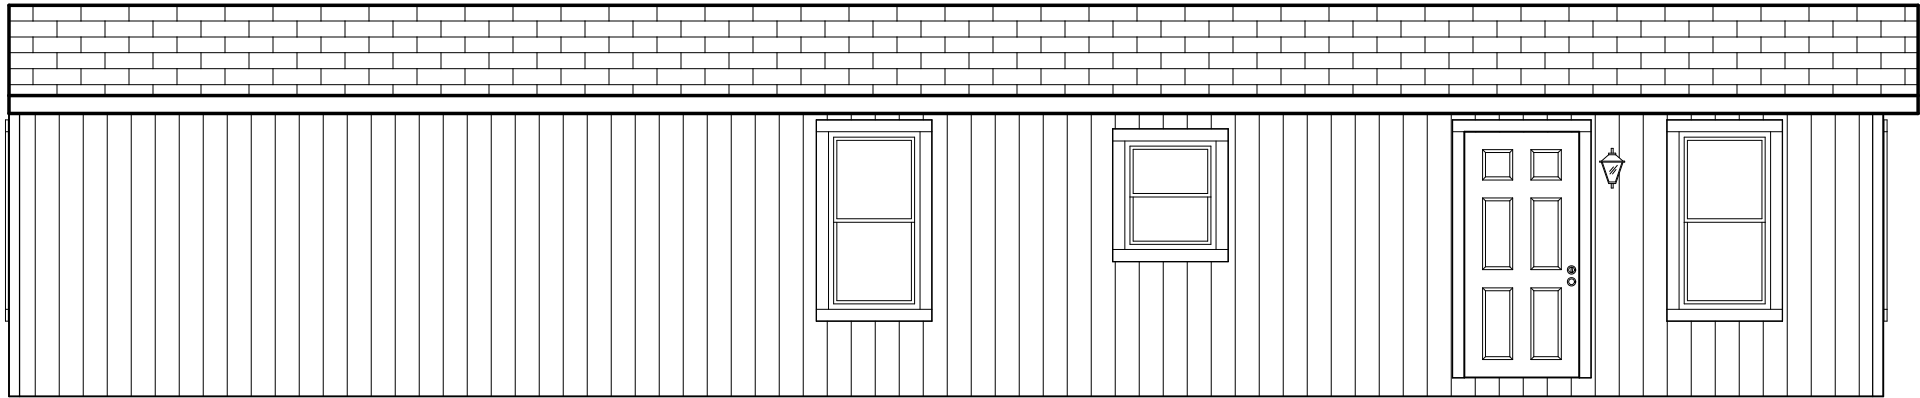

FRONT SIDE WALL ELEVATION

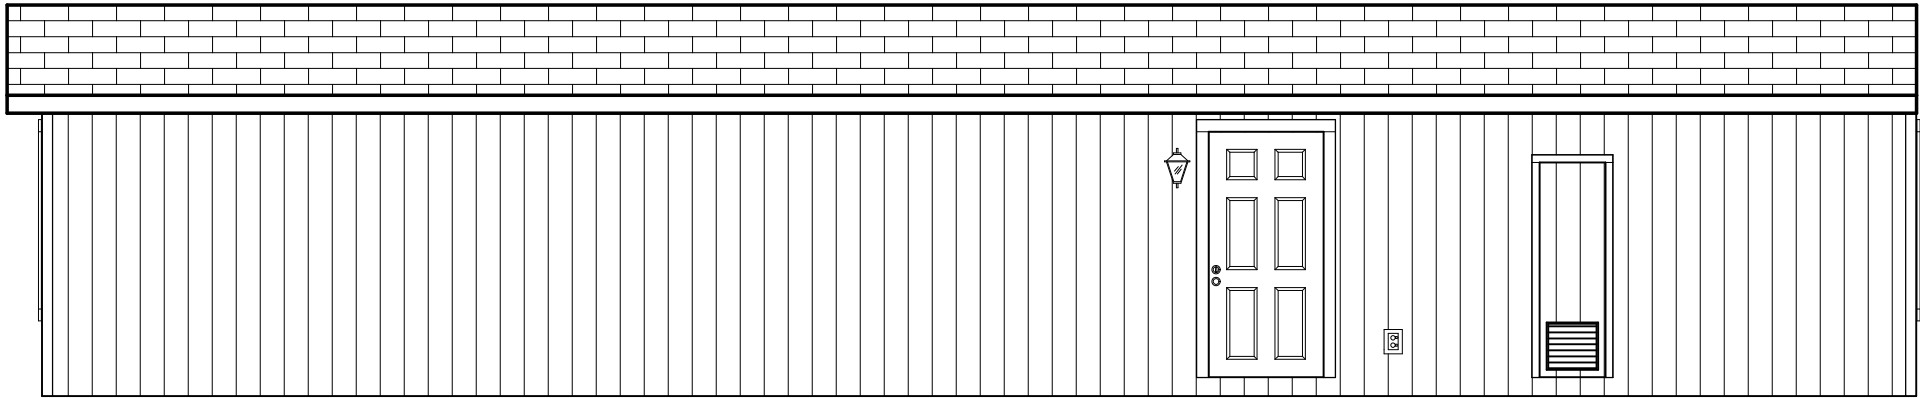

BACK SIDE WALL ELEVATION

CUSTOMER: FACTORY SELECT - LEARD
ORDER NO: 154710

ORD#154710/CUSTOMER:FACTORY SELE

Cavco
INDUSTRIES, INC.

RIVERSIDE
220

PRODUCT NAME
CANYON LAKE

MODEL NO.
14522L

DRAWING TITLE
CUSTOM
EXTERIOR
ELEVATIONS


DRAWN BY:
Roselyn Q.

DATE: 01/31/22


SHT
EE.1c

REV

22CL14522L154710

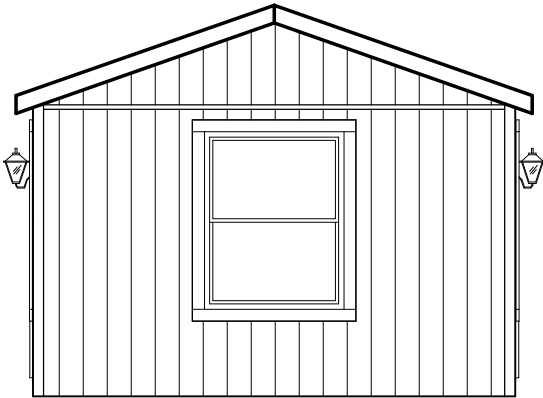

HITCH END WALL ELEVATION

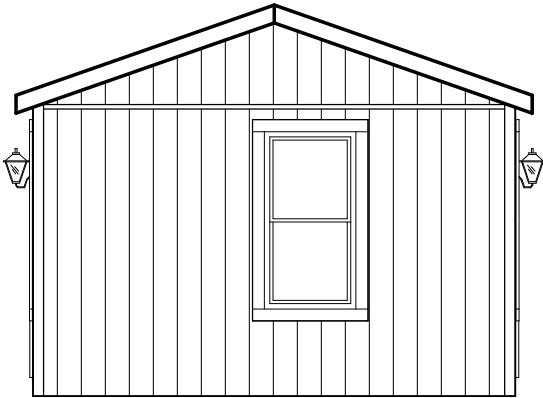

REAR END WALL ELEVATION

CUSTOMER: FACTORY SELECT - LEARD
ORDER NO: 154710

ORD#154710/CUSTOMER:FACTORY SELE

Cavco
INDUSTRIES, INC.

RIVERSIDE
220

PRODUCT NAME
CANYON LAKE

MODEL NO.
14522L

DRAWING TITLE
CUSTOM
EXTERIOR
ELEVATIONS

DRAWN BY:
Roselyn Q.

DATE: 01/31/22

SHT
EE.2c

REV

22CL14522L154710