



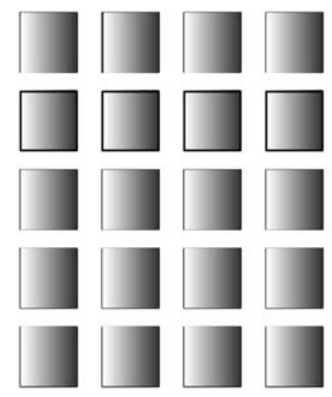

IDEAL DESIGN
SOURCE
281-636-4159

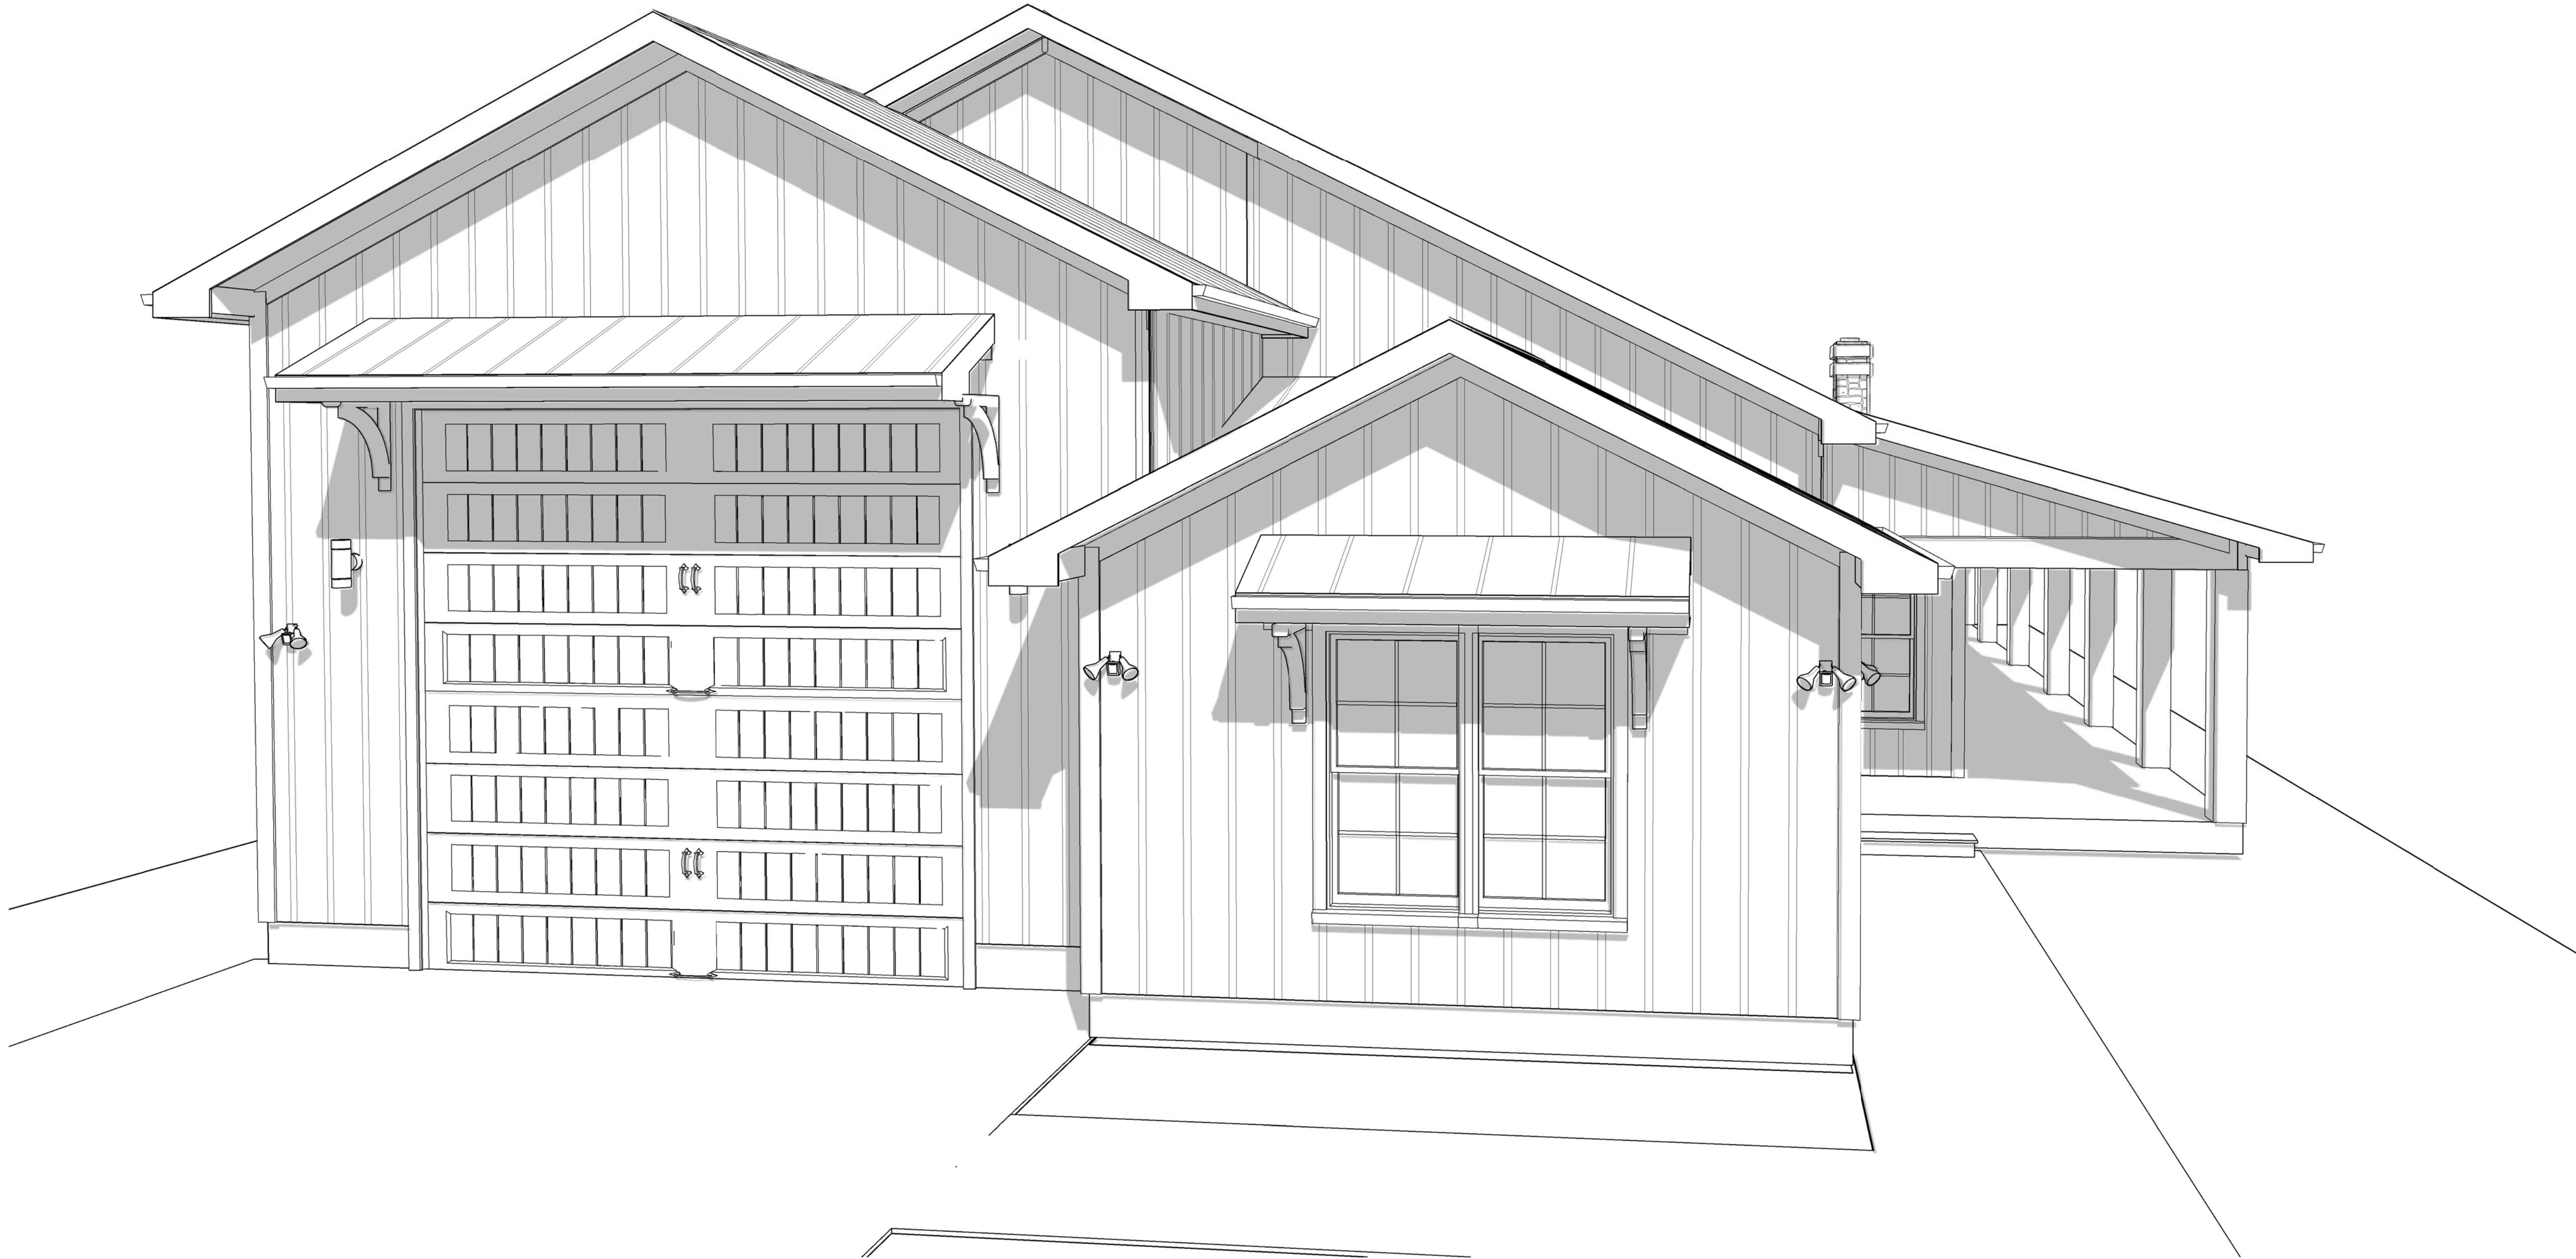

WADELYN ONE UNIT 168

WADELYN ONE UNIT 168
UNIT 168 ARCH RAY CONDOMINIUM
RV AND CABIN COMMUNITY
GILLESPIE COUNTY, TEXAS

PRIVATE ROAD
FREDERICKSBURG, TEXAS 78624

DATE:10/30/2024
DRAWN BY:
Steve Reyna
REVISION
1/4 " = 1'-0"
SIZE: D 24X36

REDLINE REVIEW



DRAWINGS PROVIDED BY IDEAL DESIGN SOURCE © 2024


WWW.IDEALDESIGNSOURCE.COM




PRIVATE ROAD
FREDERICKSBURG, TEXAS 78624

DATE:10/30/2024
DRAWN BY:
Steve Reyna
REVISION
1/4" = 1'-0"
SIZE: D 24X36

2

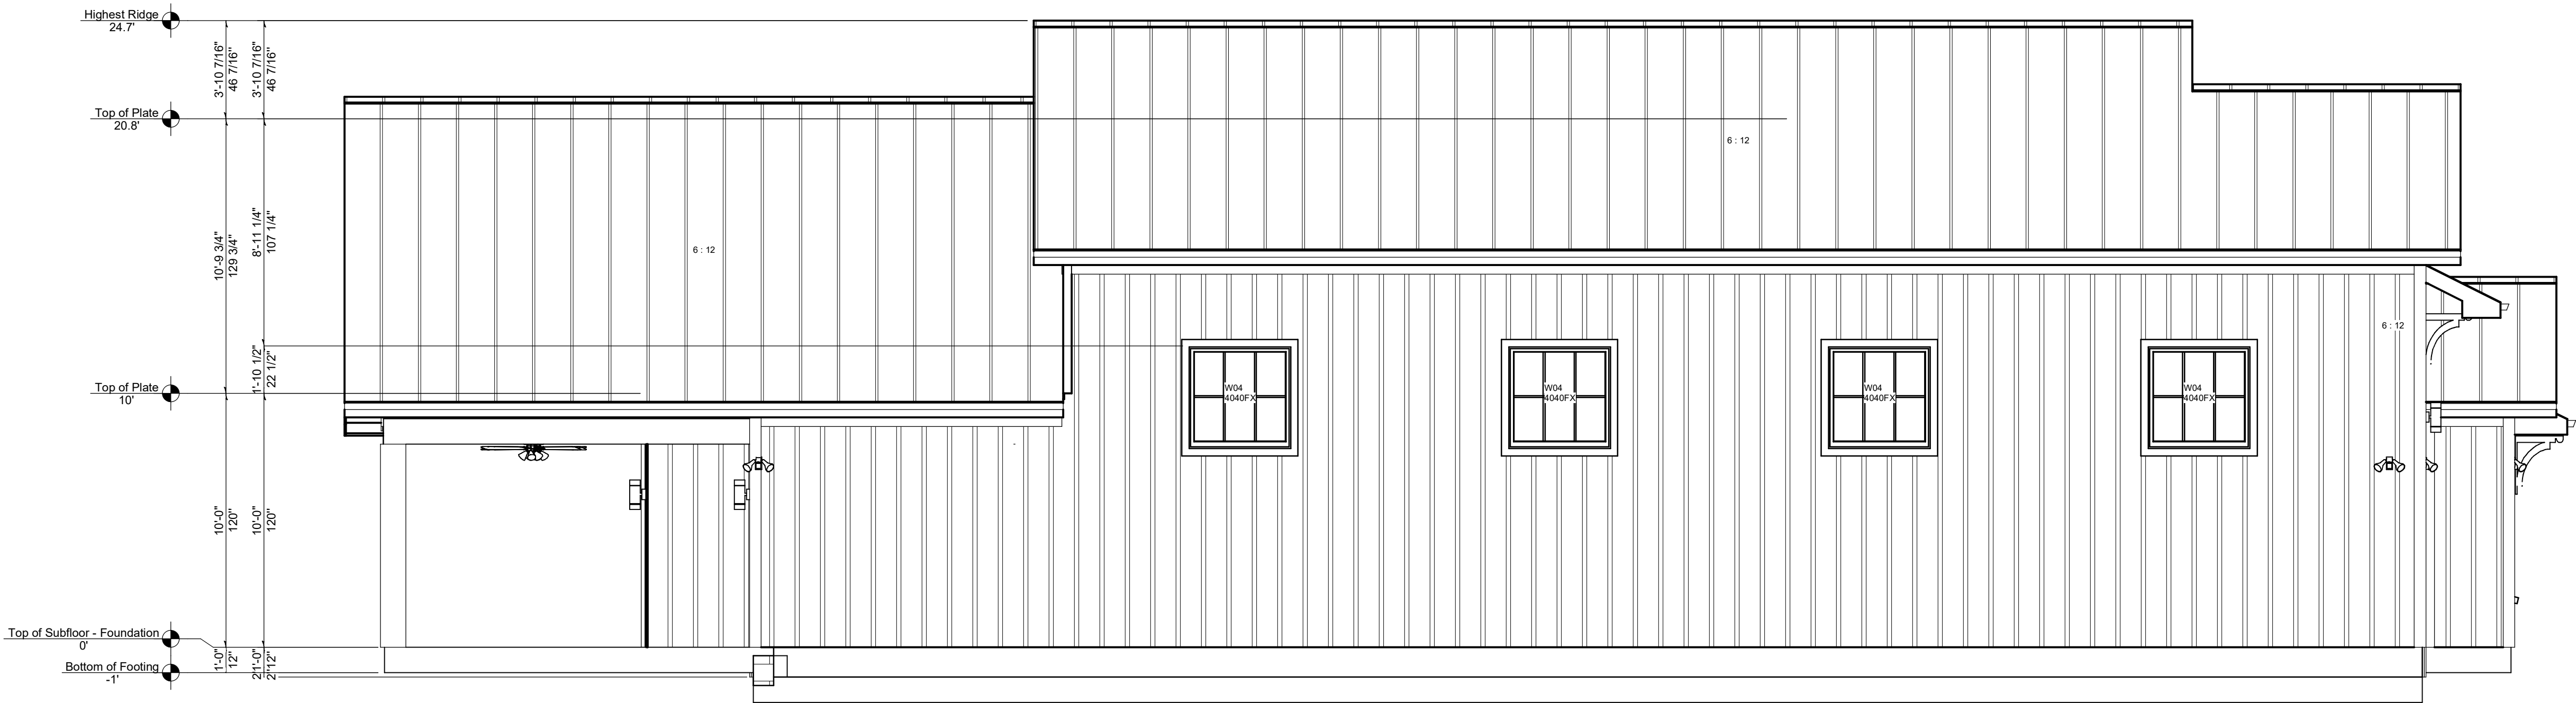

Exterior Elevation Left

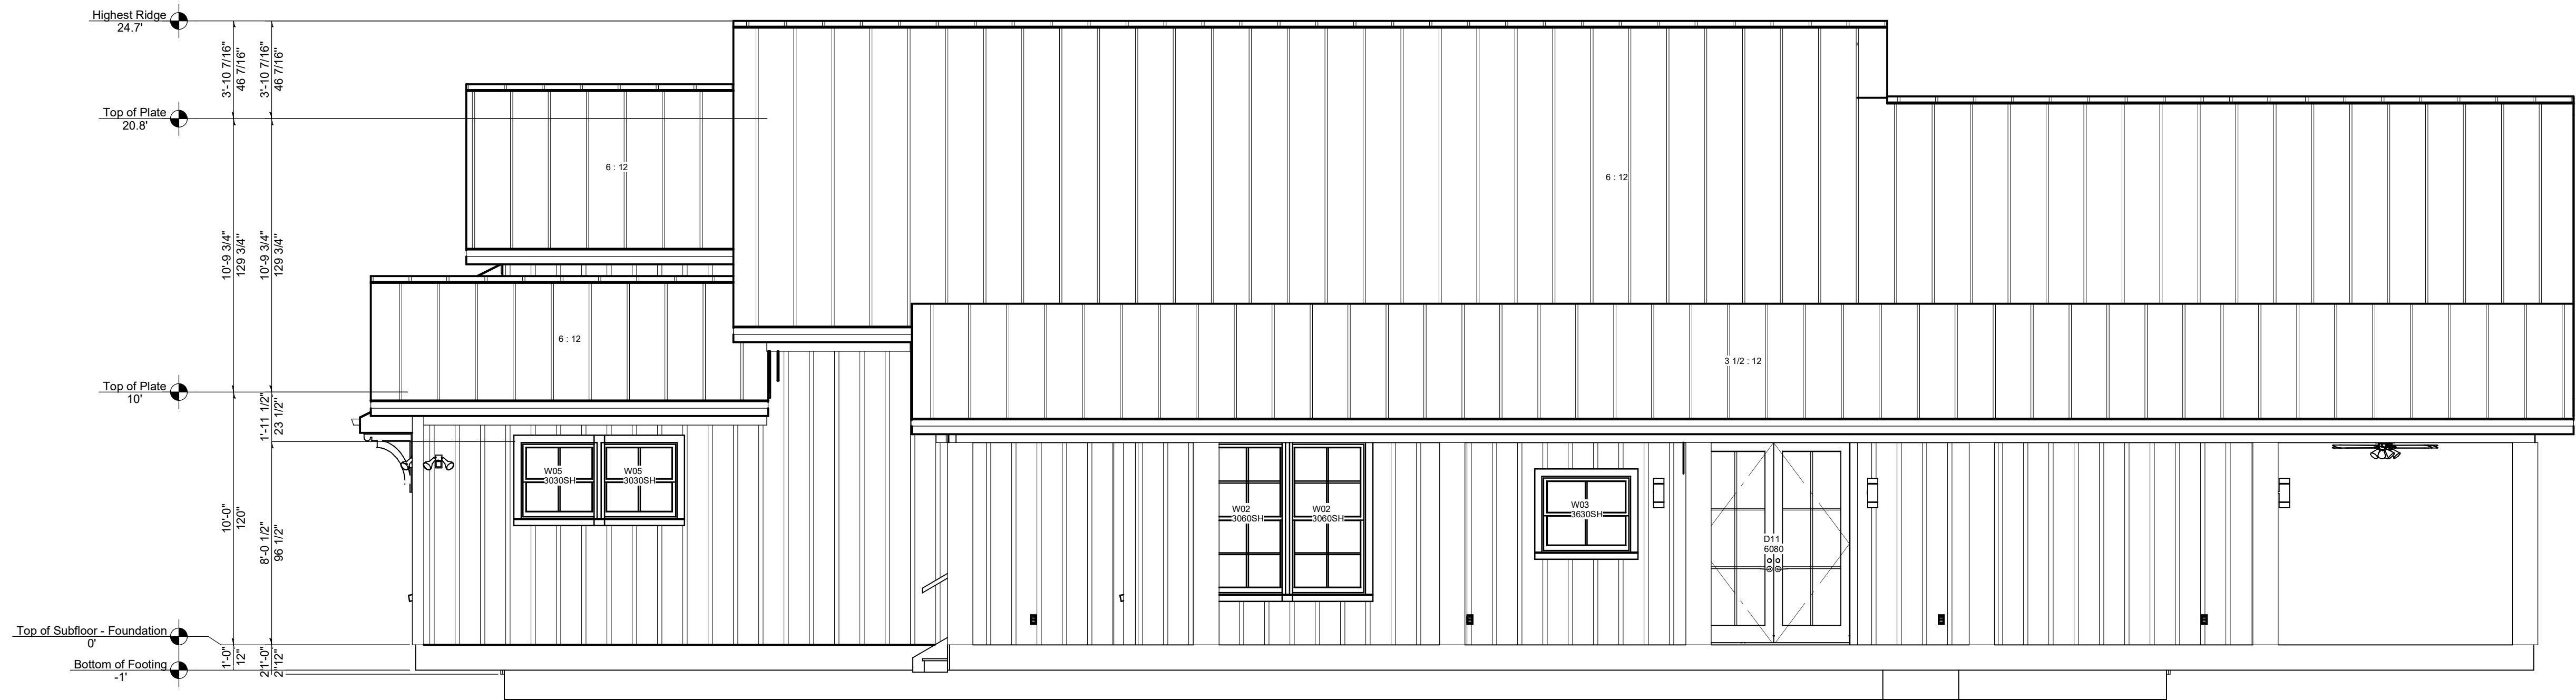

Exterior Elevation Right




**IDEAL DESIGN
SOURCE**
281-636-4159


WADELYN ONE UNIT 168
 UNIT 168 ARCH RAY CONDOMINIUM
 RV AND CABIN COMMUNITY
 GILLESPIE COUNTY, TEXAS

PRIVATE ROAD
FREDERICKSBURG, TEXAS 78624


DATE:10/30/2024
DRAWN BY:
Steve Reyna
REVISION
1/4 " = 1'-0"
SIZE: D 24X36

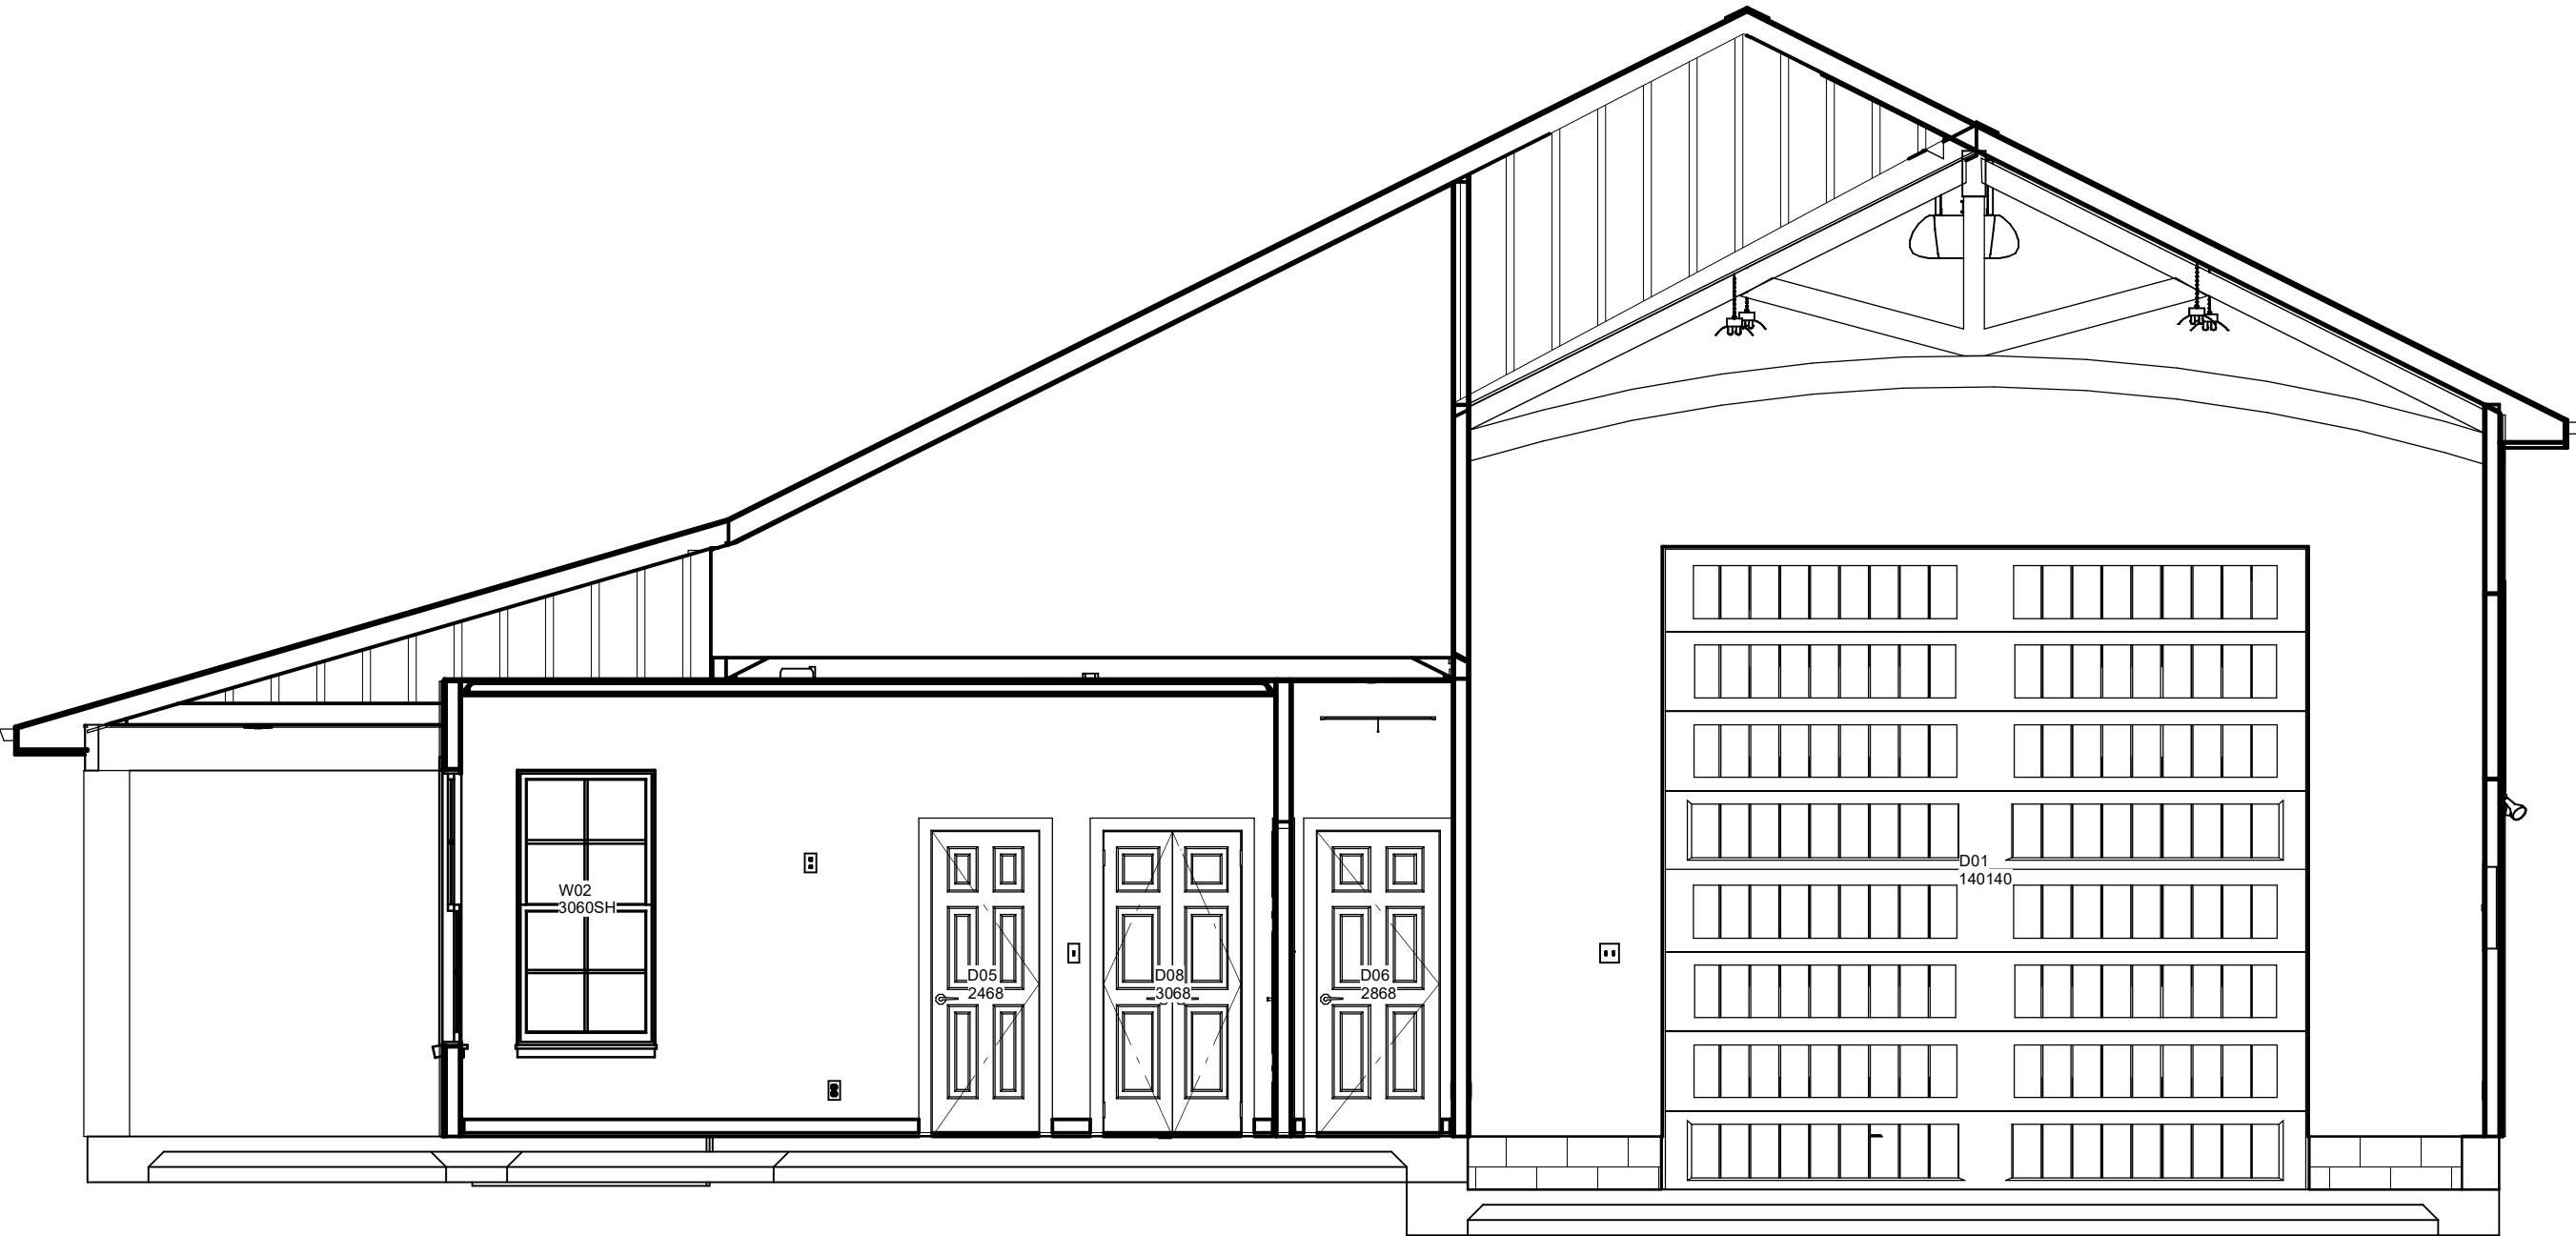


Elevation 5

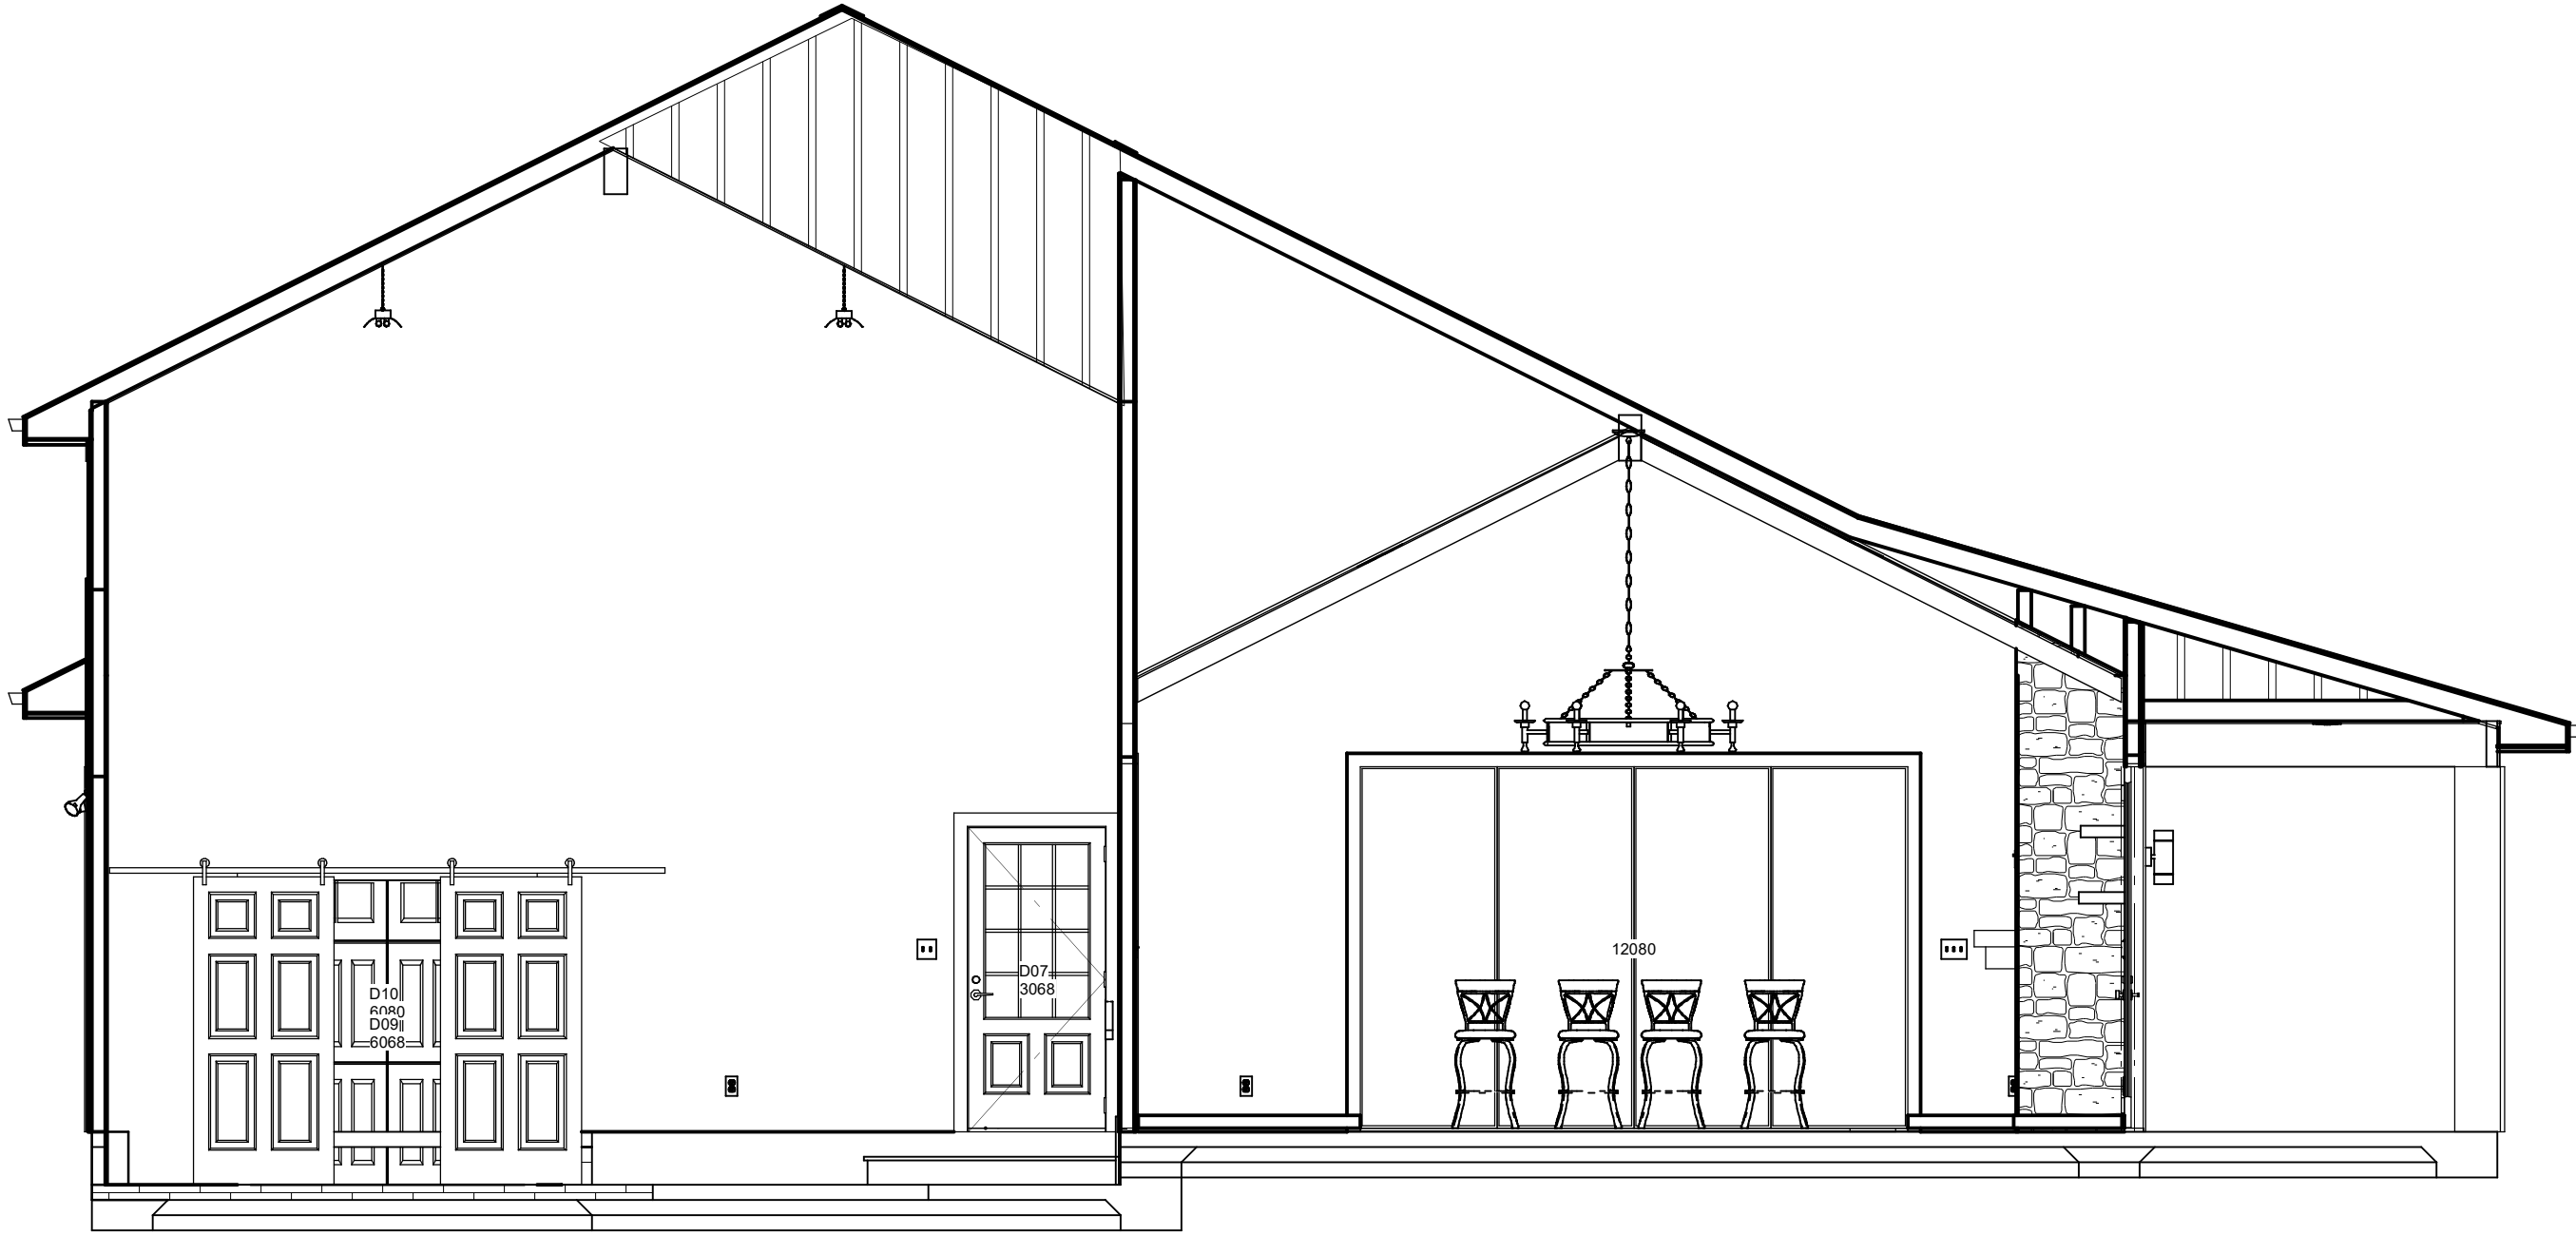


Elevation 6

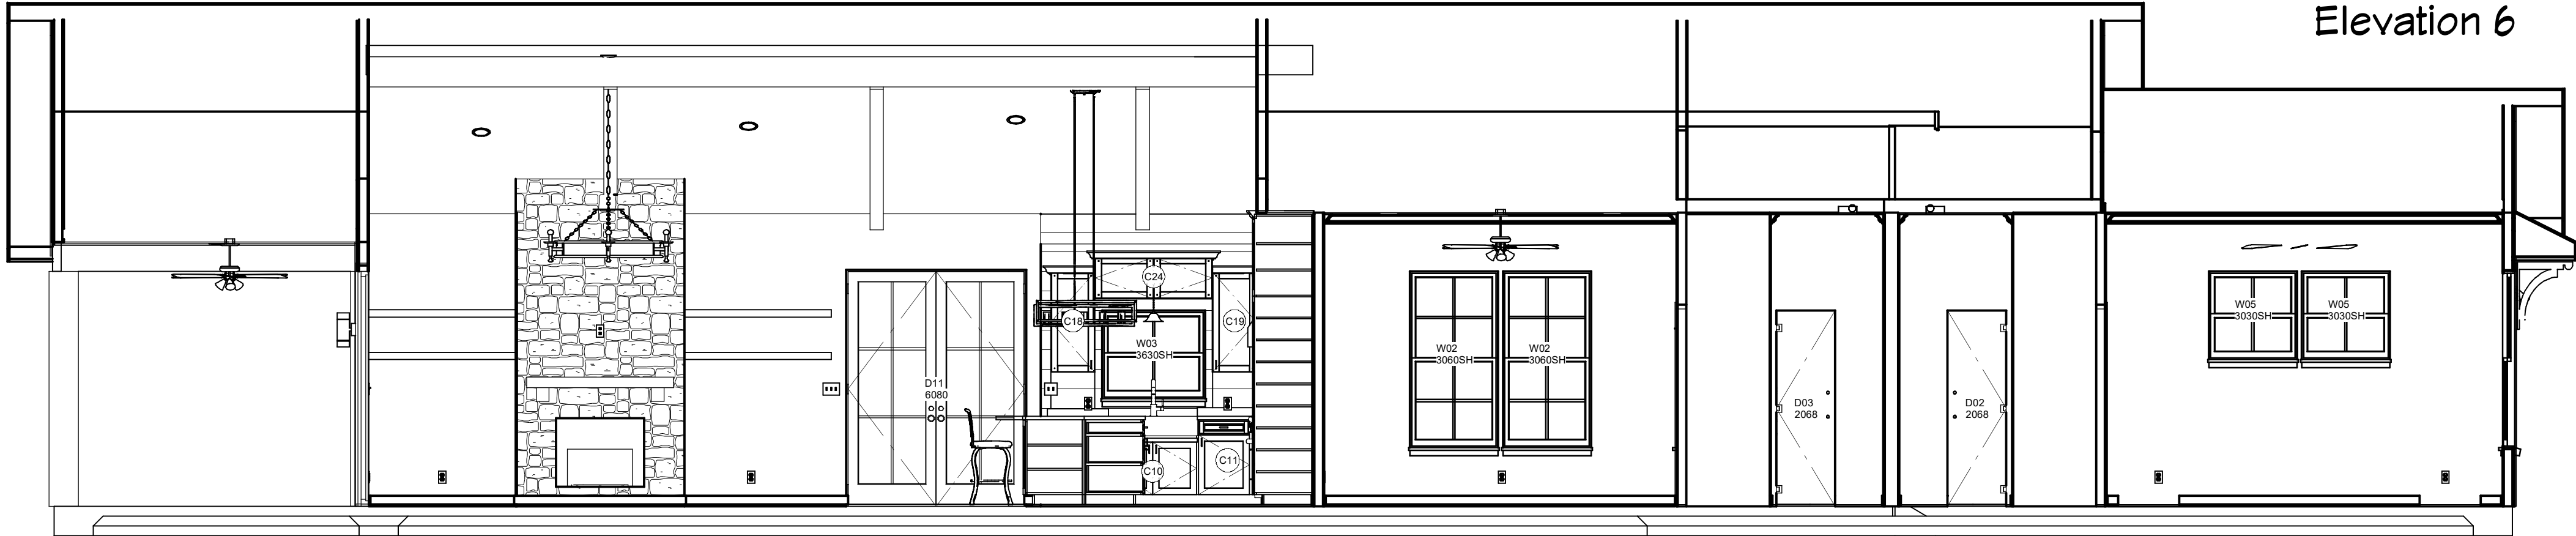

Elevation 7

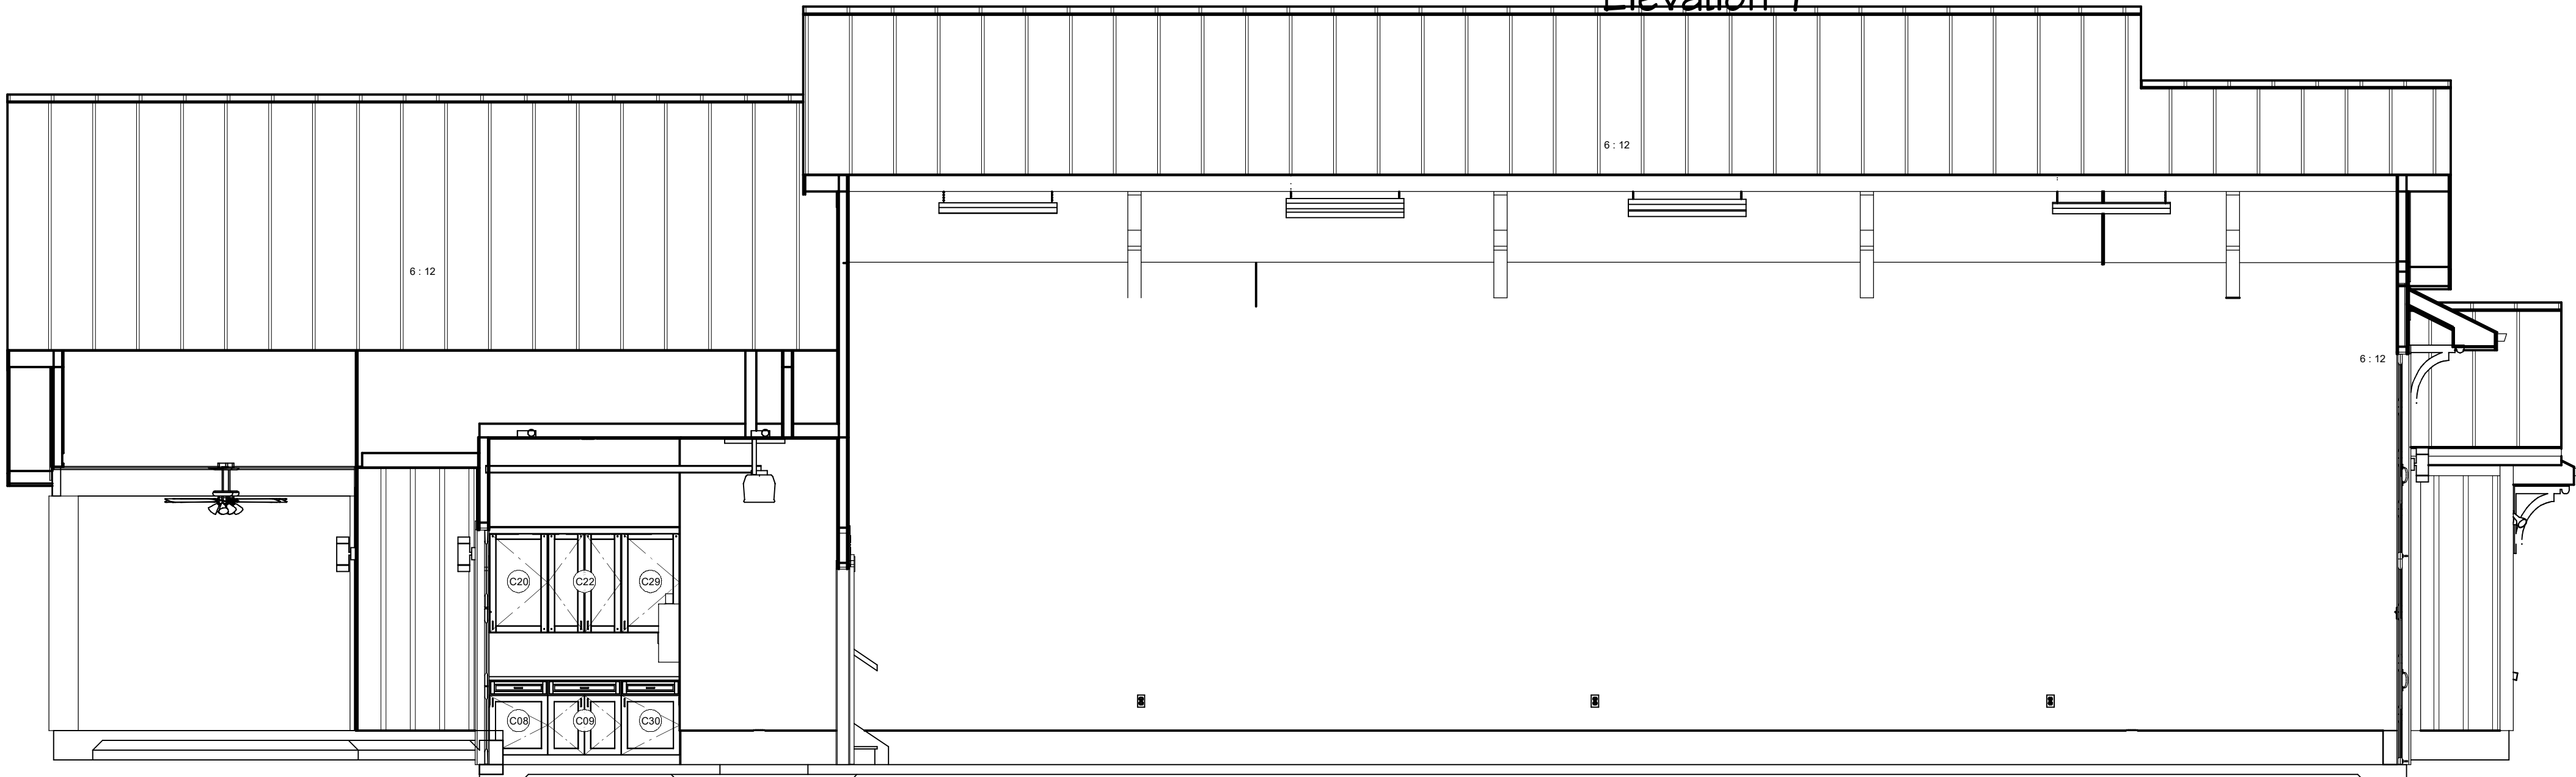

SRR@IDEALDESIGNSOURCE.COM

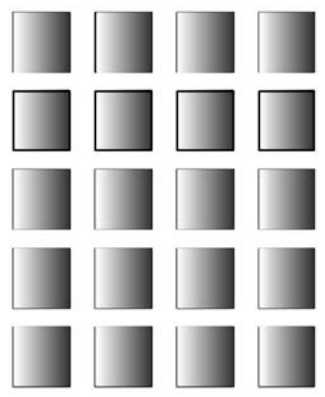


IDEAL DESIGN
SOURCE
281-636-4159

WADELYN ONE UNIT 168
UNIT 168 ARCH RAY CONDOMINIUM
RV AND CABIN COMMUNITY
GILLESPIE COUNTY, TEXAS

PRIVATE ROAD
FREDERICKSBURG, TEXAS 78624


WWW.IDEALDESIGNSOURCE.COM

DATE:10/30/2024
DRAWN BY:
Steve Reyna
REVISION
1/4 " = 1'-0"
SIZE: D 24X36

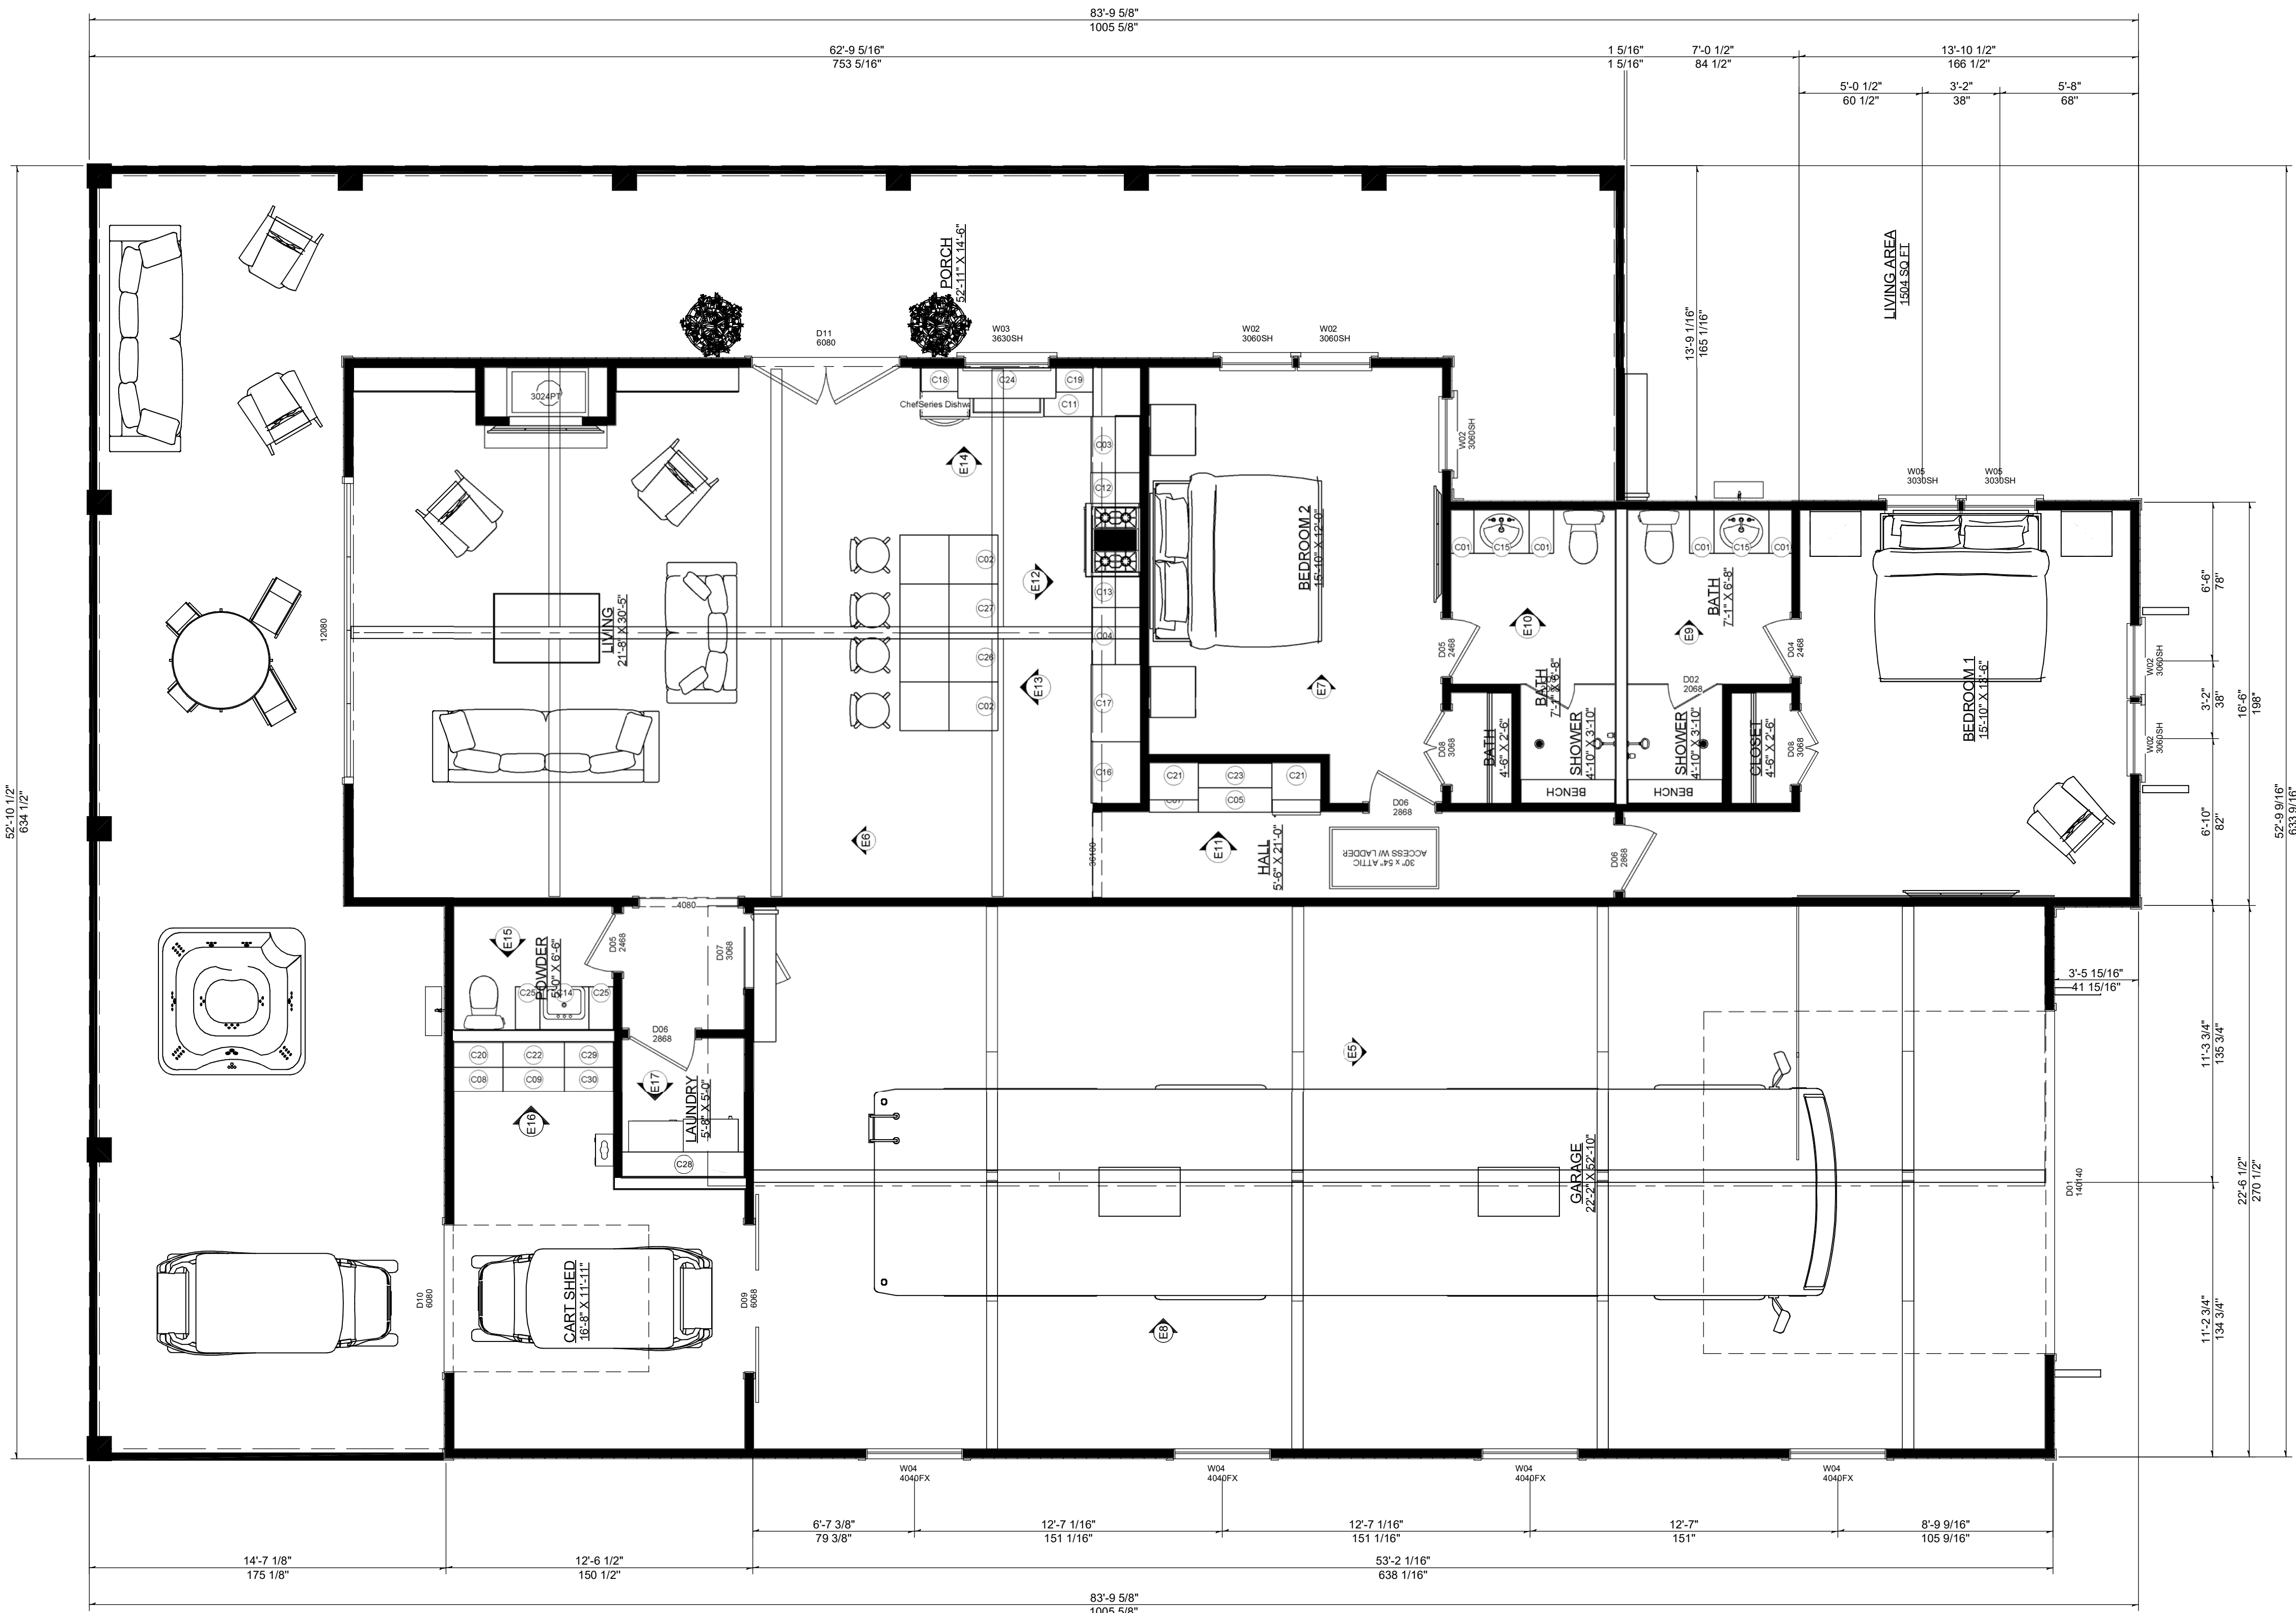


Floor Plan View Dimensioned

REDLINE REVIEW

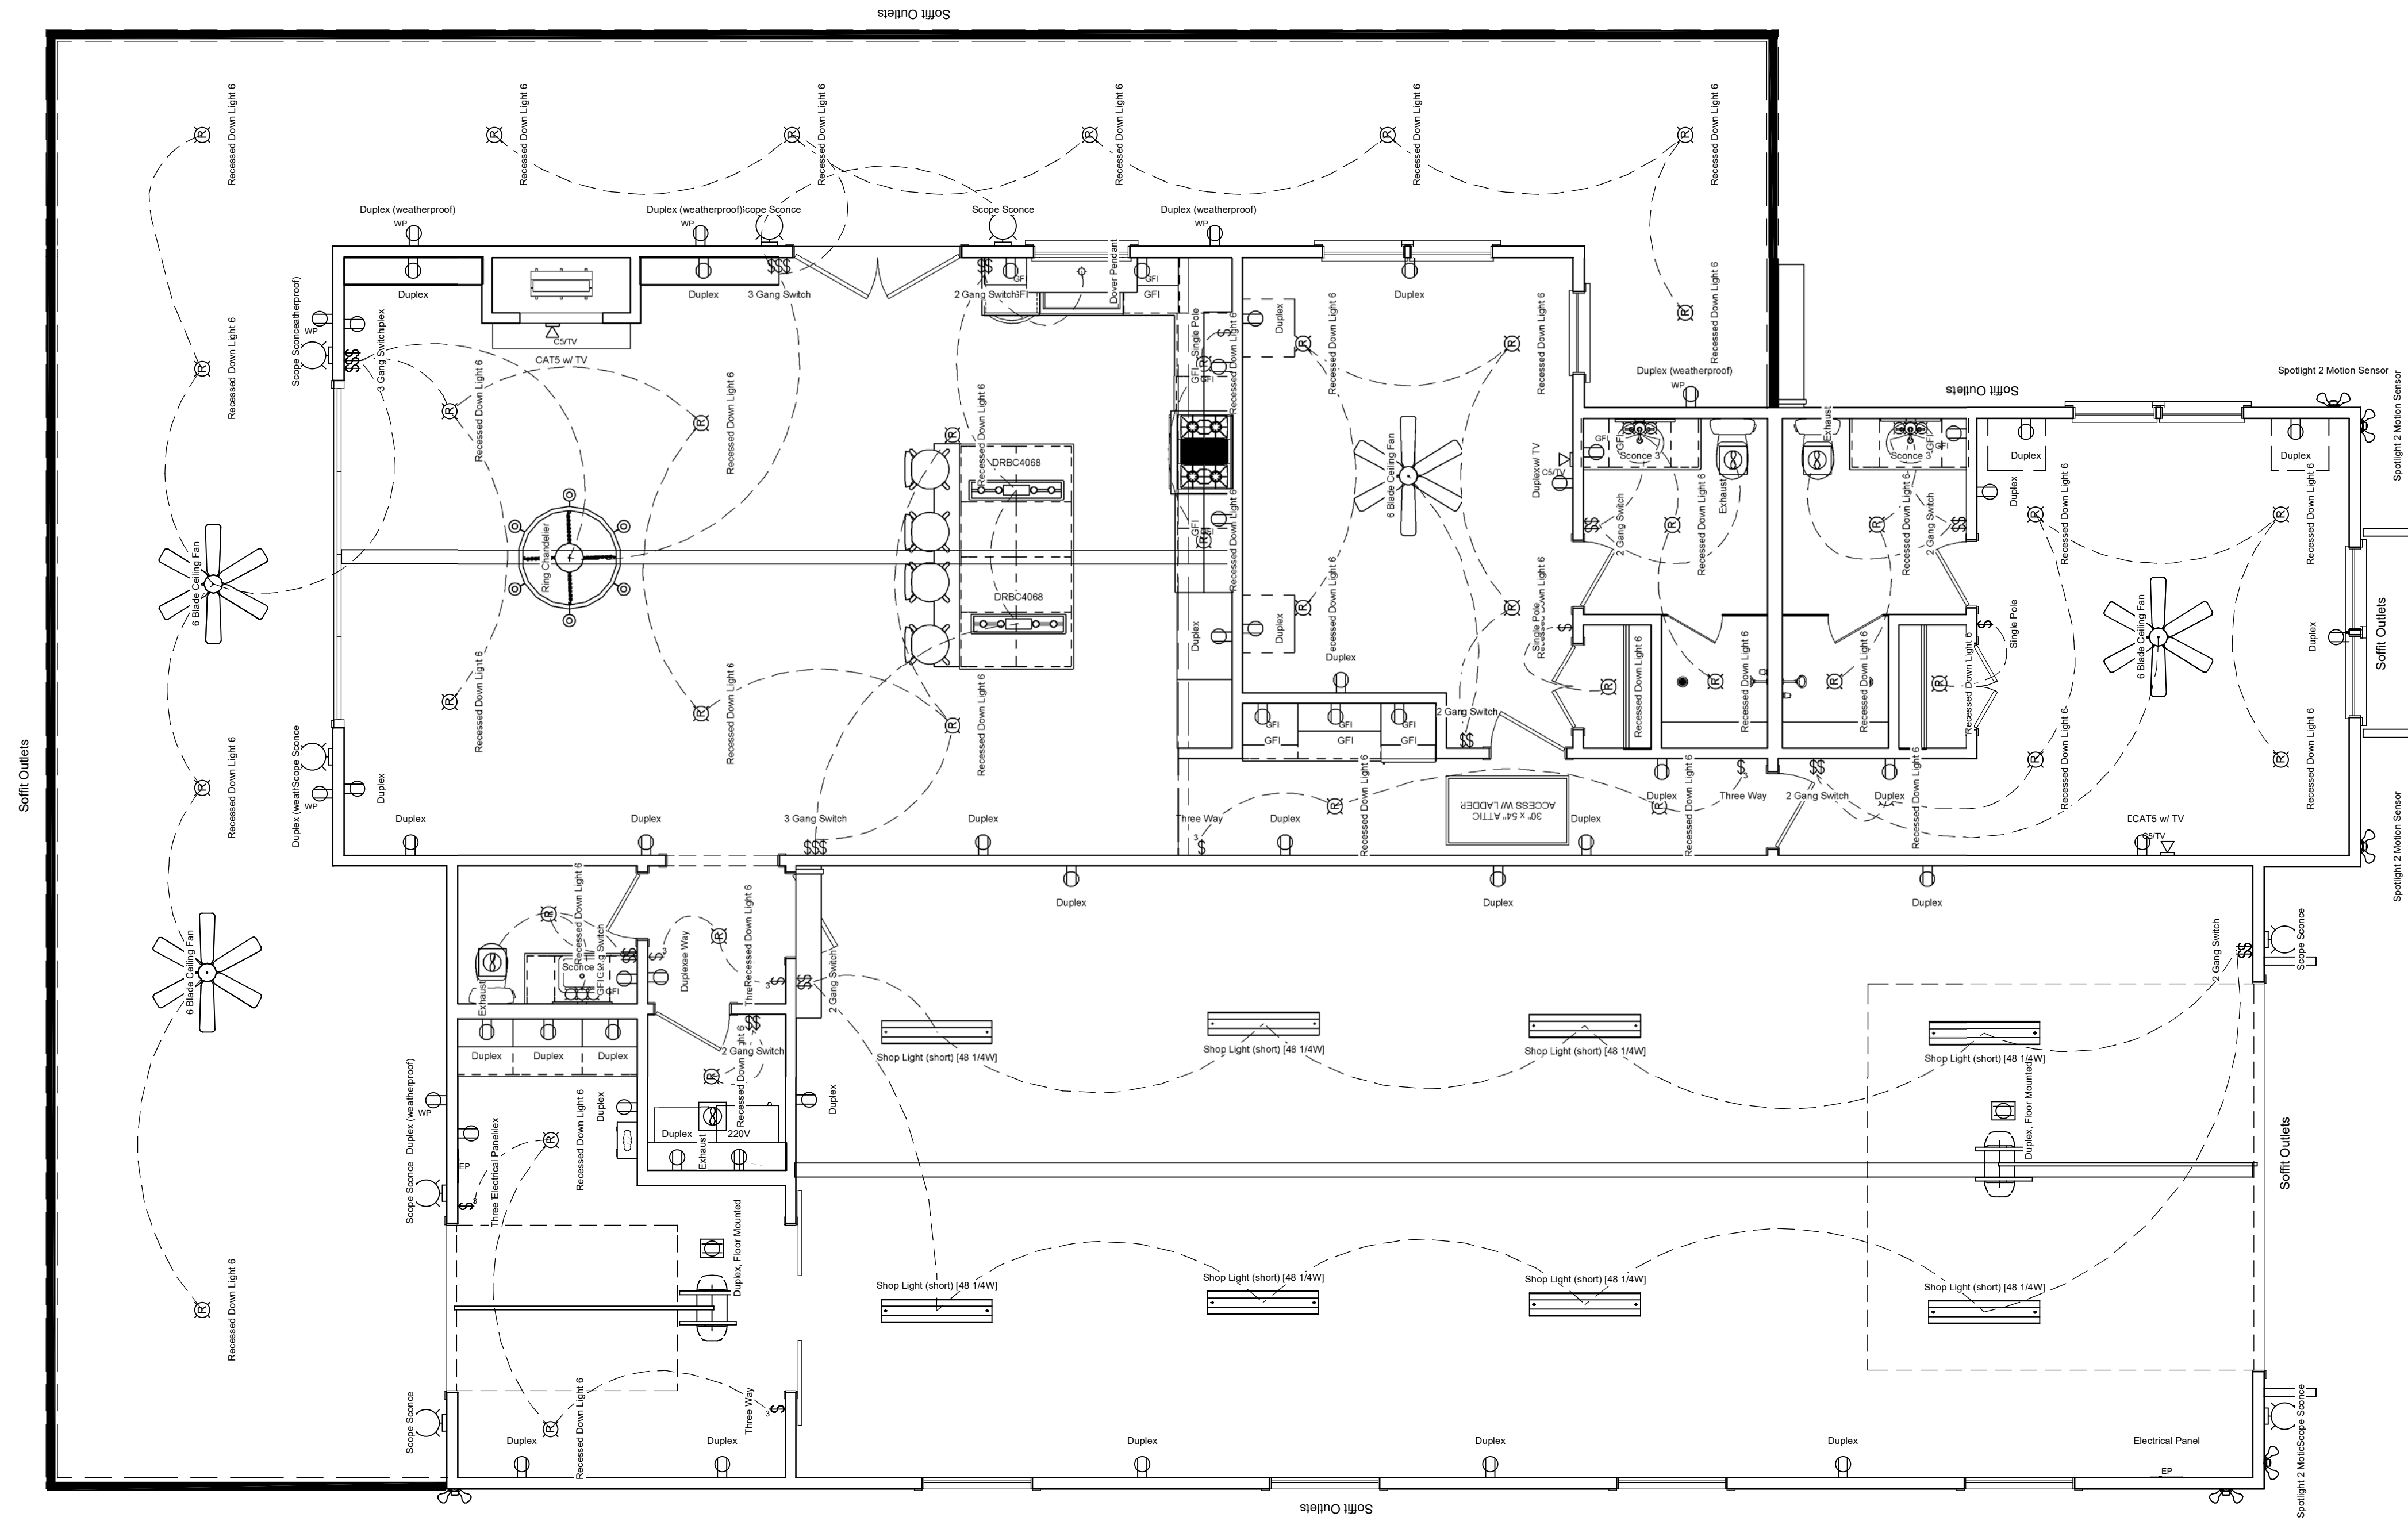

ELECTRICAL SCHEDULE		
QTY	2D SYMBOL	DESCRIPTION
9		2 GANG SWITCH
1		220V
3		3 GANG SWITCH
4		6 BLADE CEILING FAN
3		CAT5 W/ TV
1		DOVER PENDANT
38		DUPLEX
7		DUPLEX (WEATHERPROOF)
2		DUPLEX, FLOOR MOUNTED
2		ELECTRICAL PANEL
4		EXHAUST
10		GFI
40		RECESSED DOWN LIGHT 6
1		RING CHANDELIER
3		SCONCE 3
8		SCOPE SCONCE
8		SHOP LIGHT (SHORT) [48 1/4W]
3		SINGLE POLE
6		SPOTLIGHT 2 MOTION SENSOR
6		THREE WAY
2		LIGHTING

SRR@IDEALDESIGNSOURCE.COM

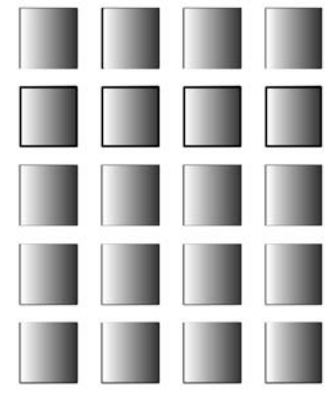

IDEAL DESIGN
SOURCE
281-636-4159

WADELYN ONE UNIT 168

UNIT 168 ARCH RAY CONDOMINIUM
RV AND CABIN COMMUNITY
GILLESPIE COUNTY, TEXAS

PRIVATE ROAD
FREDERICKSBURG, TEXAS 78624

WWW.IDEALDESIGNSOURCE.COM

DATE:10/30/202
DRAWN BY:
Steve Reyna
REVISION
1/4 " = 1'-0"
SIZE: D 24X36

6


THIS DRAWING IS FOR FINAL REVIEW PURPOSES ONLY AND IS NOT INTENDED TO BE USED OR DISTRIBUTED AS A BUILD SET

REDLINE REVIEW


DRAWINGS PROVIDED BY IDEAL DESIGN SOURCE © 2024

REDLINE REVIEW

FIXTURE SCHEDULE			
NUMBER	LABEL	QTY	FLOOR
A01	APRON FRONT SINK [36W]	2	1
A02	BASIC HANDS	2	1
A03	CLOTHES DRYER	1	1
A04	DMID ATTIC ACCESS W/CLADDER	1	1
A05	CARAGE DOOR OPENER	2	1
A06	GAS CLOTHES DRYER	1	1
A07	LOGS ON STAND W/FIRE	1	1
A08	SLAB MANTEL	1	1
A09	STANDARD TOILET	3	1
A10	CHEFFERIES DISHWASHER	1	1
A11	KR364Q LP	1	1
A12	K-1596	1	1
A13	K-9132	2	1
A14	OVAK SINK	2	1
A15	RECTANGULAR SINK [20"]	1	1
A16	WORLD	1	1
A17	TANKLESS WATER HEATER	1	1

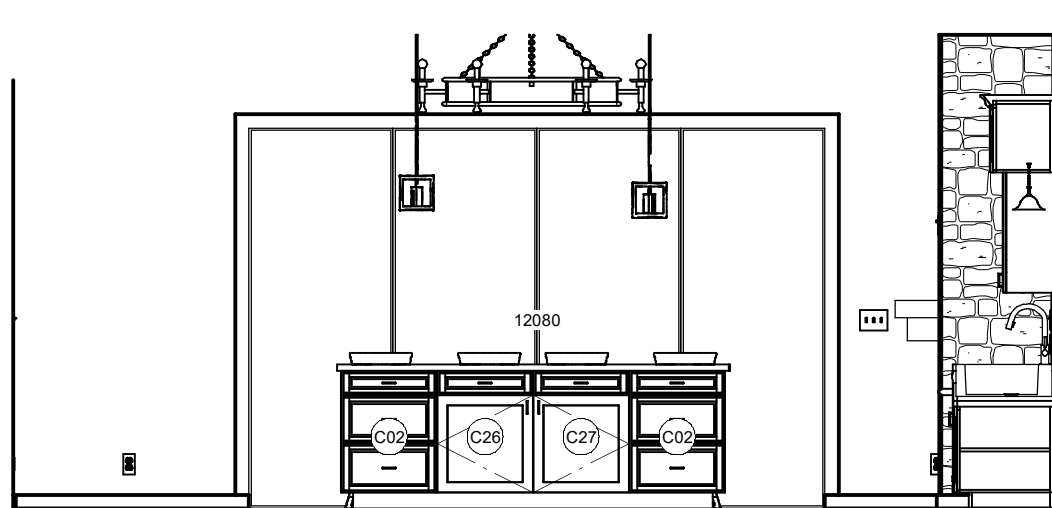


Elevation 13

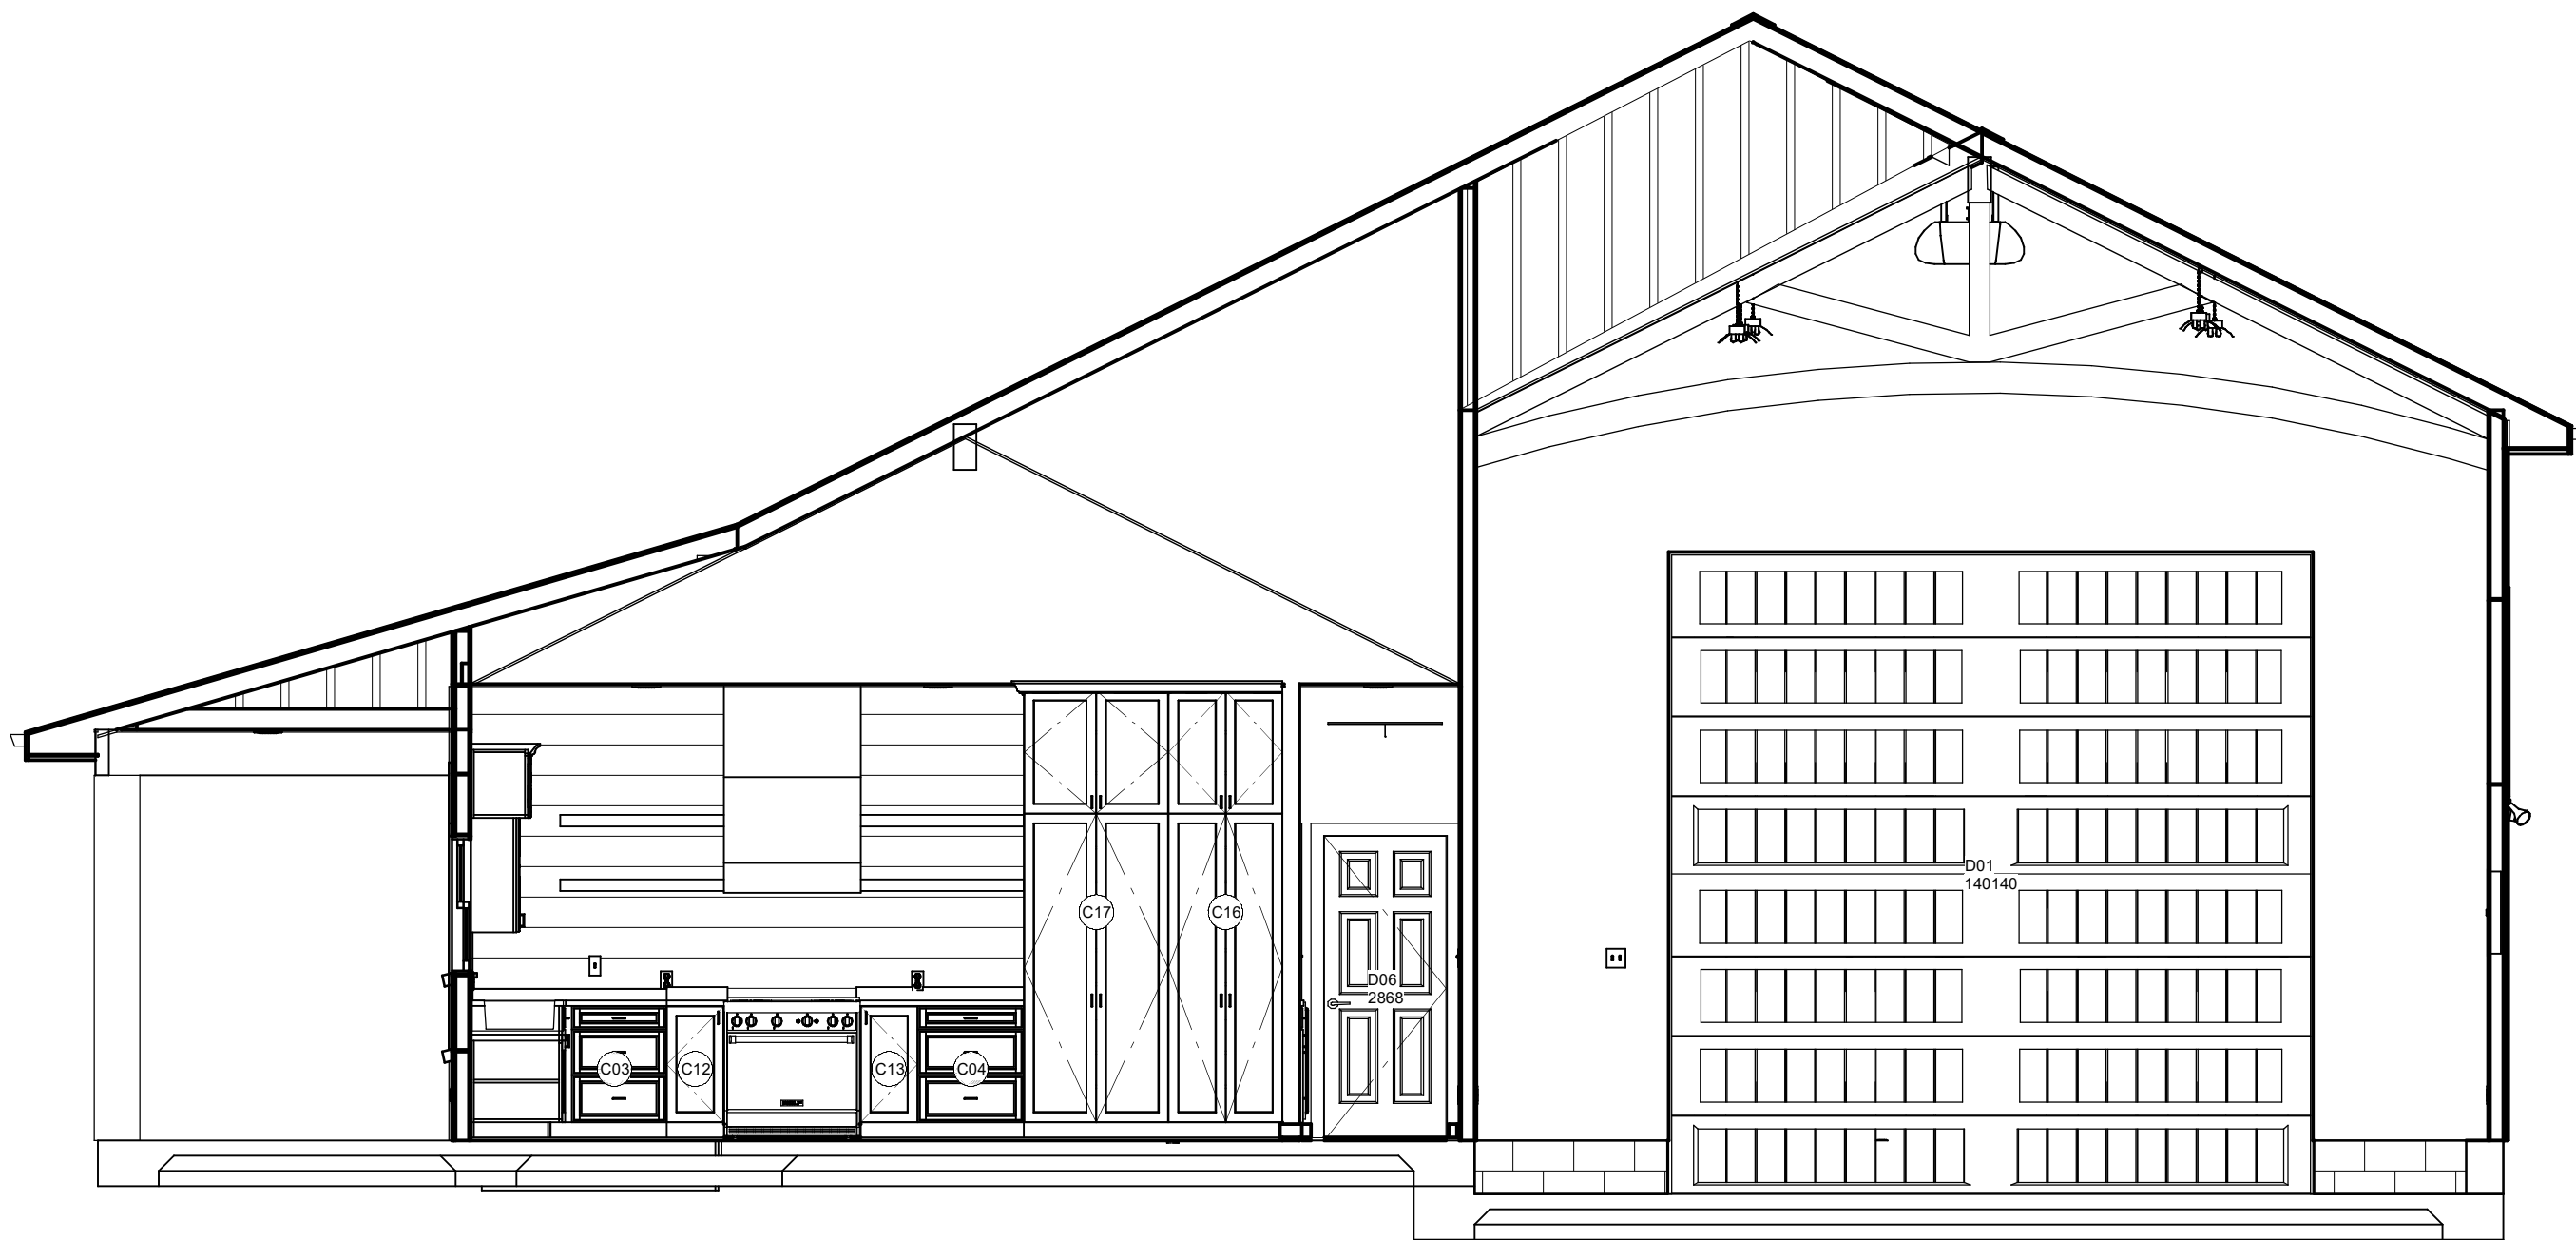

Elevation 12



Elevation 14

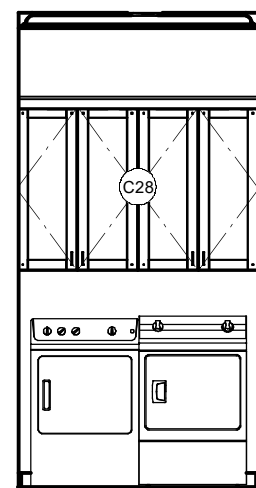

Elevation 17

WWW.IDEALDESIGNSOURCE.COM



PRIVATE ROAD
FREDERICKSBURG, TEXAS 78624

DATE:10/30/202
DRAWN BY:
Steve Reyna
REVISION
1/4 " = 1'-0"
SIZE: D 24X36

7

REDLINE REVIEW

THIS DRAWING IS FOR FINAL REVIEW PURPOSES ONLY AND IS NOT INTENDED TO BE USED OR DISTRIBUTED AS A BUILD SET

DRAWINGS PROVIDED BY IDEAL DESIGN SOURCE © 2024