

LOOS CUSTOM HOMES RESERVES THE RIGHT TO CHANGE SPECIFICATIONS AND SELECTIONS ON INDIVIDUAL MARKET HOMES IF NECESSARY, TO IMPROVE PERFORMANCE OR IF CURRENT PRODUCTS ARE NOT AVAILABLE. OPTIONS CHOSEN WILL SUPERSEDE SPECIFICATIONS.

PLAN NOTES:			
ABBREVIATIONS			
ADJ.	ADJUSTABLE	REF.	REFRIGERATOR
ASPH.	ASPHALT	EA.	ROOM
BSMT.	BASEMENT	R.C.	ROUGH OPENING
BTM.	BOTTOM	R.S.	ROUGH SAWN
BTW.	BETWEEN	SEC.	SECOND
CANT.	CANTILEVER	SH.	SINGLE HINGED
C.J.	CONTROL JOINT	SHWR.	SHOWER
CLG.	CEILING	S.L.	SIDELIGHT
CER.	CERAMIC	STA.	STATIONARY
CHIM.	CHIMNEY	STD.	STANDARD
C.O.	CASED OPENING	STL.	STEEL
COMB.	COMBINATION	STRUCT.	STRUCTURAL
COMP.	COMPACT	T.C.	TRASH COMPACTOR
CONC.	CONCRETE	T & G	TONGUE & GROOVED
CSD.	CASED	TRANS.	TRANSOM
CPT.	CARPET	TRAP	TRAPZOID
C.T.	CERAMIC TILE	W.H.	WATER HEATER
MAR.	MARBLE	FLR.	FLOOR
MICRO.	MICROWAVE	FLOUR.	FLOURESENT
MIL.	.001 INCH	FTG.	FOOTING
MIN.	MINIMUM	GALV.	GALVANIZED
MISC.	MISCELLANEOUS	G & N	GLUED & NAILED
M.O.	MASONRY OPENING	G & S	GLUED & SCREWED
NO.	NUMBER	G.L.L.	GAS LOG LIGHTER
N.T.S.	NOT TO SCALE	HDR.	HEADER
O.C.	ON CENTER	INSUL.	INSULATION
O.H.D.	OVERHEAD DOOR	INT.	INTERIOR
OPG.	OPENING	JST.	JOIST
P.C.	PULL CHAIN	LVL	LAMINATED VENEER LUMBER
PICT.	PICTURE	LAM.	LAMINATE
POLY.	POLYETHYLENE	LIN.	LINEN
PROJ.	PROJECTION	LIV.	LIVING
RAD.	RADIUS	MAX.	MAXIMUM
RAFT.	RAFTERS	MBR.	MASER BEDROOM
DBL.	DOUBLE	M.C.	MEDICINE CABINET
DET.	DETAIL	W.W.A.	WELDED WIRE MESH
DH.	DOUBLE HINGED	U.L.	UNDERLOYMENT
DIA.	DIAMETER	UNEX.	UNEXCOVATED
DN.	DOWN	WASH.	WASHER
DRY.	DRYER	WD	WOOD
D.W.	DISWASHER	W.F.	WIDE FLANGE
EA.	EACH		
ELEV.	ELEVATION	MISCELLANEOUS ABBREVIATIONS	
ENT.	ENTERTAINMENT	AT	
EXP.	EXPOSURE	1-SH ONE SHELF	
EXT.	EXTERIOR	2-SH TWO SHELVES	
F.C.	FLOOR CHANGE	3-SH THREE SHELVES	
F/G	FIBERGLASS	4-SH FOUR SHELVES	
FIN.	FINISHED	5-SH FIVE SHELVES	
FIXT.	FIXTURE	1-SH/PO ONE SHELF/ONE POLE	
F.J.	FLOOR JOIST	2-SH/PO TWO SHELVES/2 POLES WITH	
		W/	

APPLICABLE BUILDING CODES
THE FOLLOWING MASTER SET COMPLYS WITH THE FOLLOWING CODES AS APPLICABLE IN THE FOLLOWING STATES:
STATE OF WISCONSIN STATE OF WISCONSIN BUILDING CODE CHAPTERS 20 THRU 25 STATE OF WISCONSIN PLUMBING CODE CHAPTERS 81 TO 95 STATE OF WISCONSIN BUILDING CODE CHAPTER 16 STATE OF WISCONSIN BUILDING CODE CHAPTERS 1-25 SEALS/ENDORSMENTS

FABRICATION NOTES
TRUSS FABRICATION THE TRUSS MANUFACTURER IS RESPONSIBLE TO DESIGN AND DETAIL THE ROOF TRUSS SYSTEM. THE ROOF TRUSS SYSTEM SHALL INCLUDE, BUT IS NOT LIMITED TO, A COMPLETE ROOF PLAN INDICATING ALL TRUSS SIZED, LOCATIONS, CONNECTIONS, IMPOSED LOADS, AND BEARING REQUIREMENTS. THE TRUSS SYSTEM SHALL BE DESIGNED TO ACCOMMODATE ALL LIVE, DEAD, SNOW, WIND, AND UPLIFT LOADS AS REQUIRED BY ALL APPLICABLE MUNICIPAL CODES. TRUSS MANUFACTURER HALL SUBMIT 2 SETS OF SEALED SHOP DRAWINGS TO LOOS HOMES INC. AND THE ARCHITECT FOR APPROVAL OF ROOF TRUSSES AND BEAMS PRIOR TO SUBMITTAL TO CITY. IF MODIFICATIONS TO THE CONSTRUCTION DOCUMENTS ARE REQUIRED, LOOS HOMES INC. AND ARCHITECT SHALL BE NOTIFIED IMMEDIATELY. REFER TO GENERAL NOTES FOR ADDITIONAL INSTRUCTION.
WALL PANEL FABRICATION THE WALL PANEL MANUFACTURER IS RESPONSIBLE TO DESIGN AND DETAIL THE STRUCTURE WALL PANELS. THE WALL PANEL SYSTEM SHALL INCLUDE, BUT IS NOT LIMITED TO, A WALL PANEL PLAN INDICATION ALL STRUCTURAL HEADER AND BEAM SIZING, LOCATIONS, CONNECTIONS, IMPOSED LOADS, AND BEARING REQUIREMENTS. THE WALL PANEL SYSTEM SHALL BE DESIGNED TO ACCOMMODATE ALL LIVE, DEAD, WIND, AND SEISMIC LOADS AS REQUIRED BY ALL APPLICABLE MUNICIPAL CODES. WALL PANEL MANUFACTURER SHALL SUBMIT 2 SETS OF SEALED BEAM AND HEADER CALCULATIONS WITH WALL PANEL SHOP DRAWINGS TO LOOS HOMES INC. AND THE ARCHITECT FOR APPROVAL OF WALL PANELS PRIOR TO SUBMITTAL TO CITY. IF MODIFICATIONS TO THEIR CONSTRUCTION DOCUMENTS ARE REQUIRED, LOOS HOMES INC. AND THE ARCHITECT SHALL BE NOTIFIED IMMEDIATELY. REFER TO GENERAL NOTES FOR ADDITIONAL INSTRUCTION.
FLOOR JOIST FABRICATION THE FLOOR JOIST MANUFACTURER/SUPPLIER IS RESPONSIBLE TO DESIGN AND DETAIL THE STRUCTURE FLOOR SYSTEM. THE FLOOR SYSTEM SHALL INCLUDE, BUT IS NOT LIMITED TO, A COMPLETE FLOOR JOIST PLAN INDICATING ALL STRUCTURAL BEAM SIZING, BLOCKING LOCATIONS, CONNECTIONS, IMPOSED LOADS, AND BEARING REQIUREMENTS. THE FLOOR JOISTS SHALL BE DESIGNED TO ACCOMMODATE ALL LIVE AND DEAD LOADS AS REQUIRED BY ALL APPLICABLE MUNICIPAL CODES. IN ADDITION, FLOOR JOISTS MUST BE SIZED FOR A LIVE LOAD MINIMUM DEFLECTION OF L/480. FLOOR JOIST MANUFACTURER/SUPPLIER SHALL SUBMIT 2 SETS OF SEALED BEAM CALCULATIONS WITH FLOOR JOIST PLAN DRAWINGS TO LOOS HOMES INC. AND THE ARCHITECT FOR APPROVAL OF FLOOR JOIST SYSTEM PRIOR TO SUBMITTAL TO CITY. IF MODIFICATIONS TO THEIR CONSTRUCTION DOCUMENTS ARE REQUIRED, LOOS HOMES INC. AND ARCHITECT SHALL BE NOTIFIED IMMEDIATELY. REFER TO GENERAL NOTES FOR ADDITIONAL INSTRUCTION.



SPRUCE

MASTER PLAN

LAKE COUNTRY
DESIGN STUDIO, LLC

N51W35831 HILLCREST COURT
OCONOMOWOC, WI 53086
PH|920.723.7005

WWW.LCDSDESIGN.COM

CONTRACTOR
INFORMATION



LOOS CUSTOM
HOMES LLC

435 Village Walk Lane
Johnson Creek, WI 53038
PH|920.699.3787
FAX|920.699.7202

WWW.LOOSHOMES.COM

PROJECT
INFORMATION

MARKET HOME

SPRUCE MASTER

EDGE FIELD
LOT 46
1233 EDGE FIELD CT.
WATERTOWN, WI 53094

JOB NUMBER: 26EF46

8	----	----	----
7	----	----	----
6	7.14.26	SF UPDATE	KMS
5	7.13.26	PD5	KMS
4	6.24.26	PD4	KMS
3	6.22.26	PD3	KMS
2	5.26.26	PD2	KMS
1	3.17.26	PD1	KMS
NO.	DATE:	DESCRIPTION:	BY:
	DRAWN BY: KMS	DATE: 3.17.26	



FIRST FLOOR LAYOUT

© 2026 LOOS CUSTOM HOMES LLC

SQUARE FOOTAGES

LIVING AREAS	
FIRST FLOOR LIVING AREA	1528 SF
TOTAL LIVING AREA	1528 SF

NON-LIVING AREAS	
GARAGE AREA	460 SF
COVERED PORCH AREA	27 SF
DECK W/STAIRS AREA	59 SF
REAR PATIO AREA	144 SF

PROJECT INFORMATION

MARKET HOME

EDGE FIELD
LOT 46
1233 EDGE FIELD CT.
WATERTOWN, WI 53094

JOB NUMBER: 26EF46

INDEX OF DRAWINGS

Sheet List Table	
Sheet Number	Sheet Title
Coversheet	
CS	Coversheet
Architectural Drawings	
A1	Exterior Elevations 1 – Roof Plan
A2	Foundation Plan
A3	First Floor Plan
A4	Foundation & First Floor Bracing Plan
Electrical Drawings	
E1	Foundation & First Floor Electrical Plan
Section & Detail Drawings	
D1	Typical Wall Section & Building Details
D2	Deck Framing Plan and Details

SHEET TITLE


COVERSHEET

JOB NUMBER
26EF46

SHEET NUMBER

CS

SHT 1 OF 8

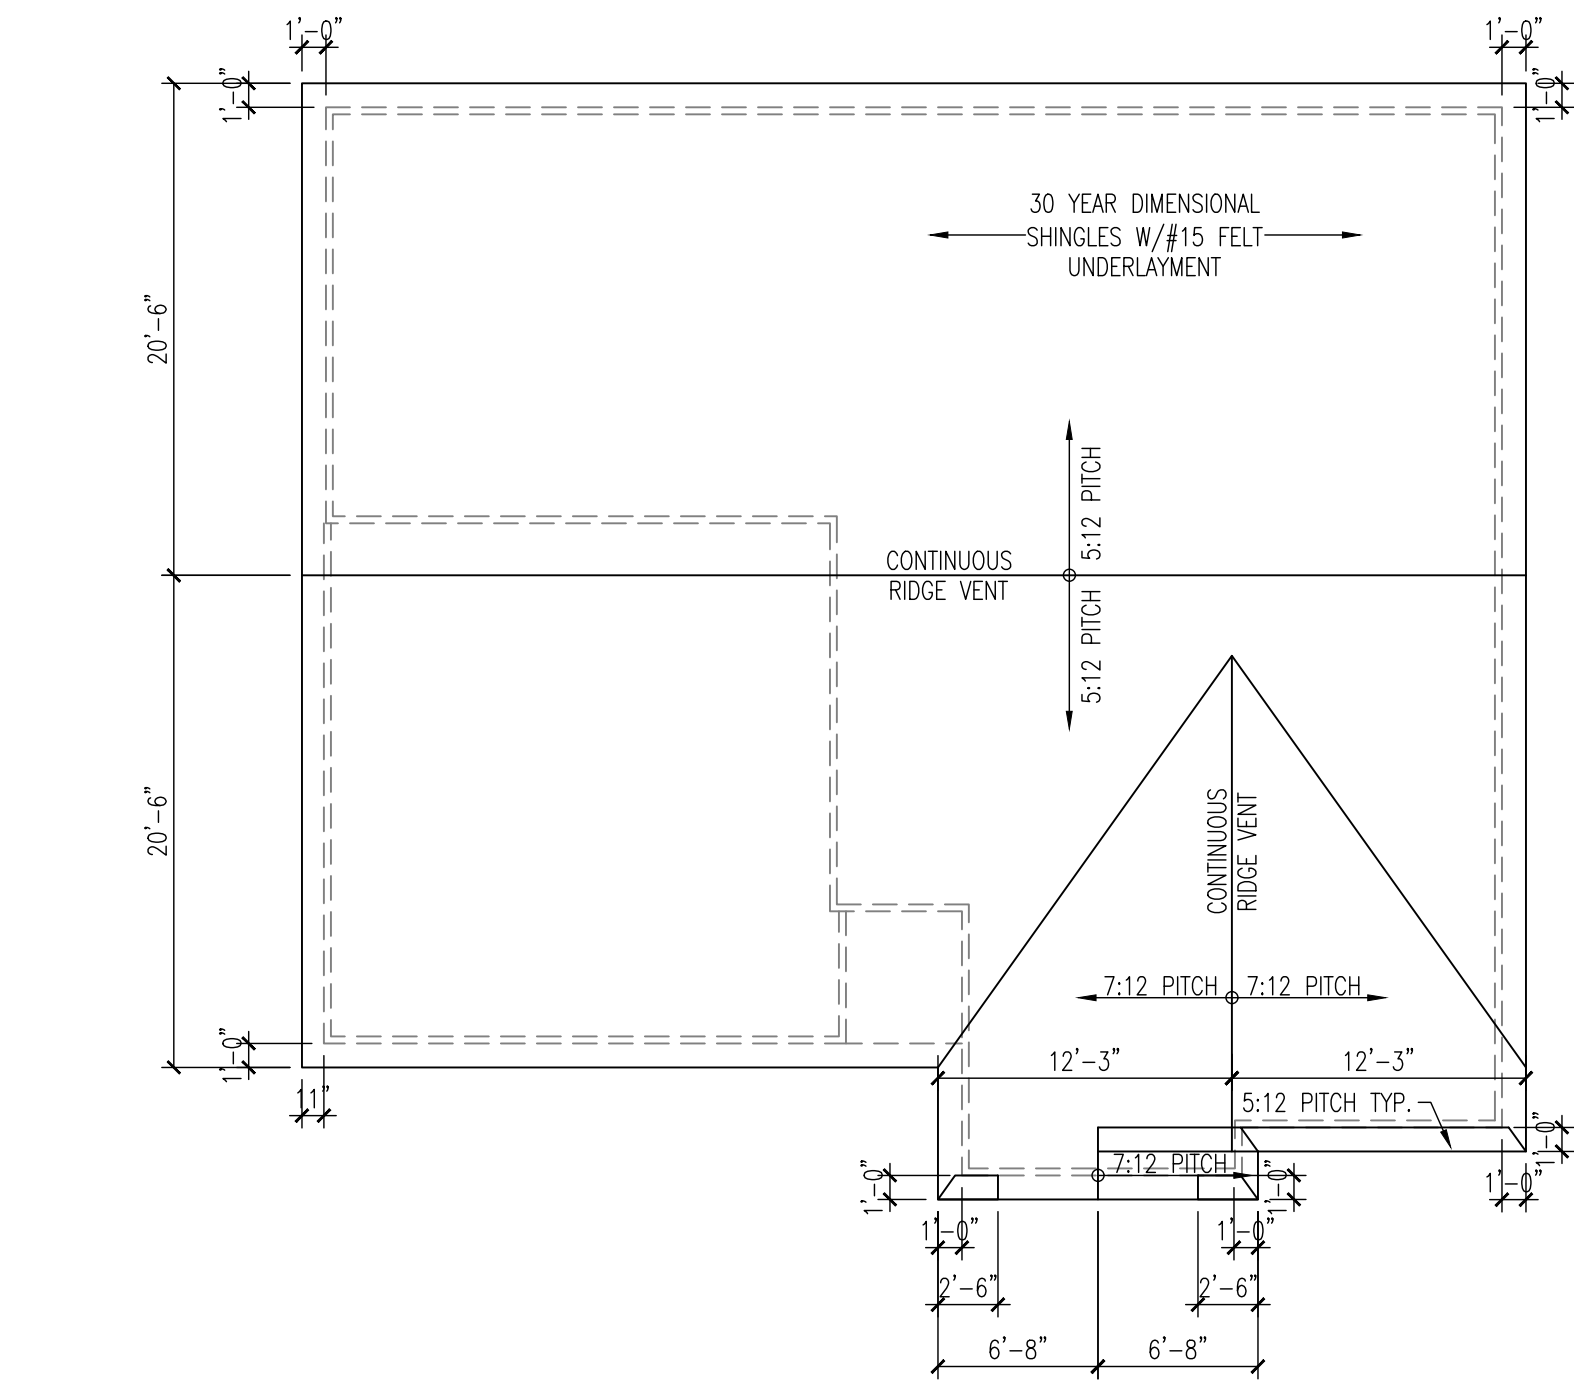


ELEVATION 1
ROOF PLAN
SCALE: 1/8" = 1'-0"

- NOTES:
ROOF INFORMATION
- ROOF TO BE COMPOSED OF PRE-ENGINEERED TRUSSES BY OTHERS @ 24" O.C.




ELEVATION 1
LEFT ELEVATION
SCALE: 1/8" = 1'-0"

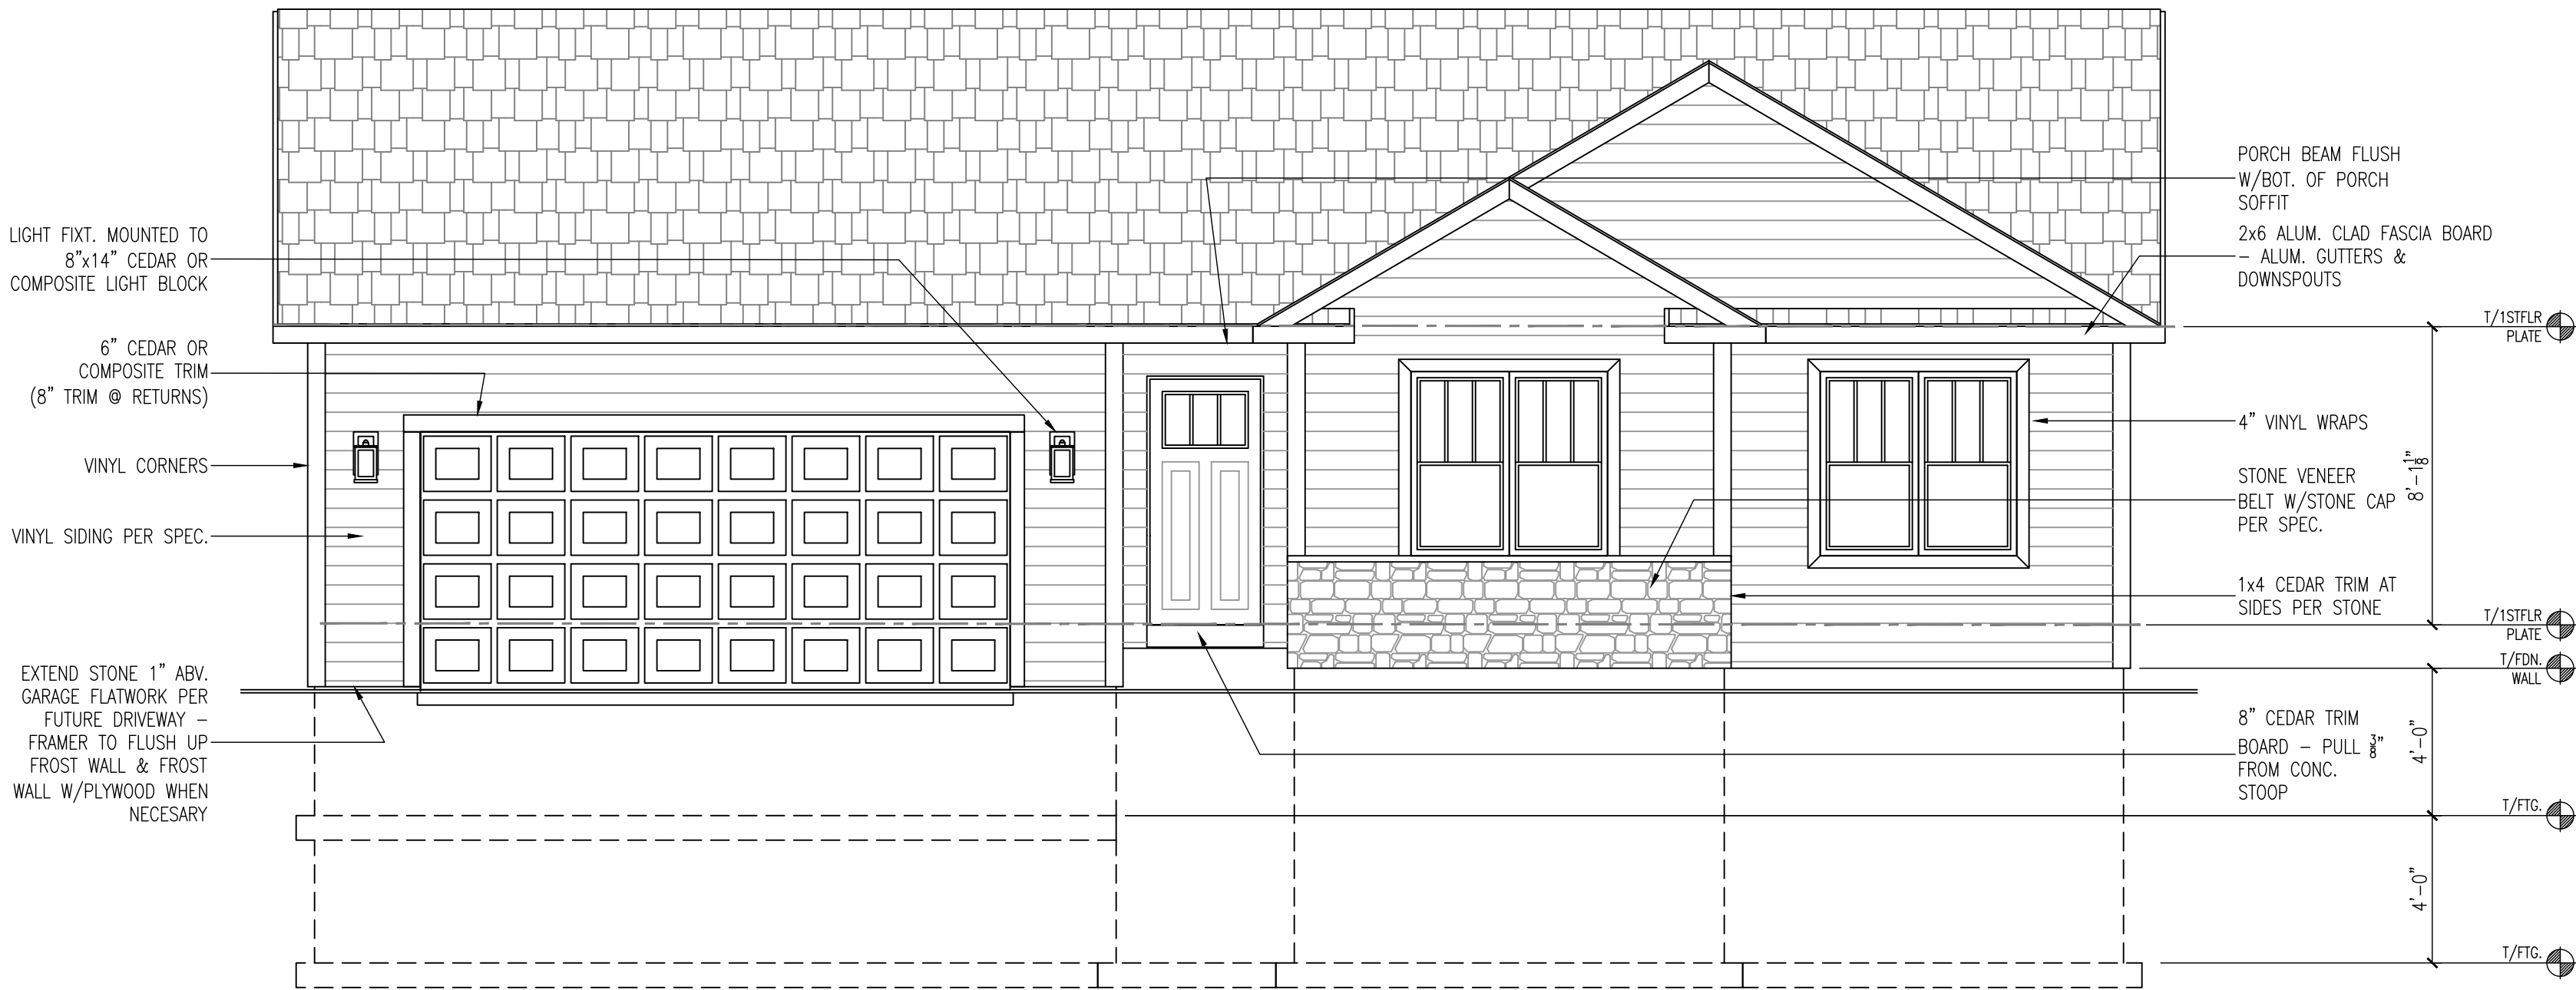

ELEVATION 1
FRONT ELEVATION
SCALE: 1/4" = 1'-0"



ELEVATION 1
REAR ELEVATION
SCALE: 1/8" = 1'-0"

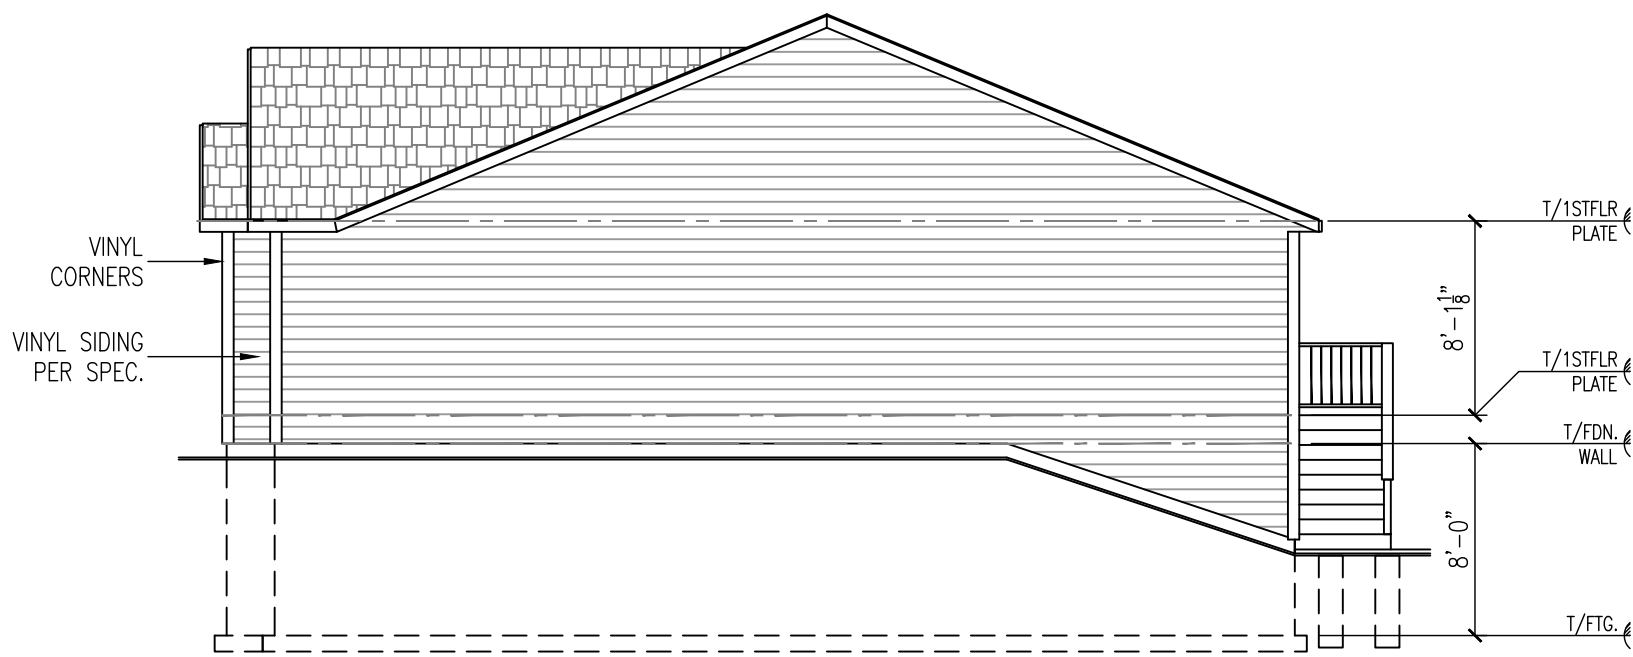

ELEVATION 1
RIGHT ELEVATION
SCALE: 1/8" = 1'-0"

LAKE COUNTRY
DESIGN STUDIO, LLC

N51W35831 HILLCREST COURT
OCONOMOWOC, WI 53066
PH|920.723.7005

WWW.LCDSDESIGN.COM

CONTRACTOR
INFORMATION



**LOOS CUSTOM
HOMES LLC**

435 Village Walk Lane
Johnson Creek, WI 53038
PH|920.699.3787
FAX|920.699.7202

WWW.LOOSHOMES.COM

PROJECT
INFORMATION

MARKET HOME

SPRUCE MASTER

EDGE FIELD
LOT 46
1233 EDGE FIELD CT.
WATERTOWN, WI 53094

JOB NUMBER: 26EF46

8	----	----	----
7	----	----	----
6	7.14.26	SF UPDATE	KMS
5	7.13.26	PD5	KMS
4	6.24.26	PD4	KMS
3	6.22.26	PD3	KMS
2	5.26.26	PD2	KMS
1	3.17.26	PD1	KMS
NO.	DATE:	DESCRIPTION:	BY:
	DRAWN BY: KMS	DATE: 3.17.26	

SHEET TITLE

**EXTERIOR
ELEVATIONS 1 -
ROOF PLAN**

JOB NUMBER
26EF46

SHEET NUMBER

A1

SHT 2 OF 8



8	-----	----	-----
7	-----	----	-----
6	7.14.26	SF UPDATE	KMS
5	7.13.26	PD5	KMS
4	6.24.26	PD4	KMS
3	6.22.26	PD3	KMS
2	5.26.26	PD2	KMS
1	3.17.26	PD1	KMS
NO.	DATE:	DESCRIPTION:	BY:
DRAWN BY: KMS		DATE: 3.17.26	

FOUNDATION PLAN

JOB NUMBER
26EF46

A2

FOUNDATION PLAN

SCALE: $1/4" = 1'-0"$ ($1/8" = 1'-0"$ 11x17)

NOTES:

WALL INFORMATION


- MAIN HOUSE CONCRETE WALLS: 8" 3000psi POURED CONCRETE WALL @ 8'-0" (UNLESS NOTED).
- GARAGE CONCRETE WALLS: 6" 3000psi POURED CONCRETE WALL @ 4'-0" (UNLESS NOTED).

STAIR INFORMATION

- REFER TO FIRST FLOOR PLAN FOR STAIR INFORMATION.

PLAN INFORMATION

- REFER TO TYPICAL WALL SECTION (SHT. D1) FOR ADDITIONAL FOUNDATION INFORMATION.
- ALL PLAN DIMENSIONS ARE TO FACE OF STUD OR CONCRETE TO FACE OF STUD OR CONCRETE.
- THE CONDITIONS LISTED HERE ARE STANDARD FOR THIS PLAN ELEVATION(S). EXCEPTIONS ARE NOTED ON THE PLAN.

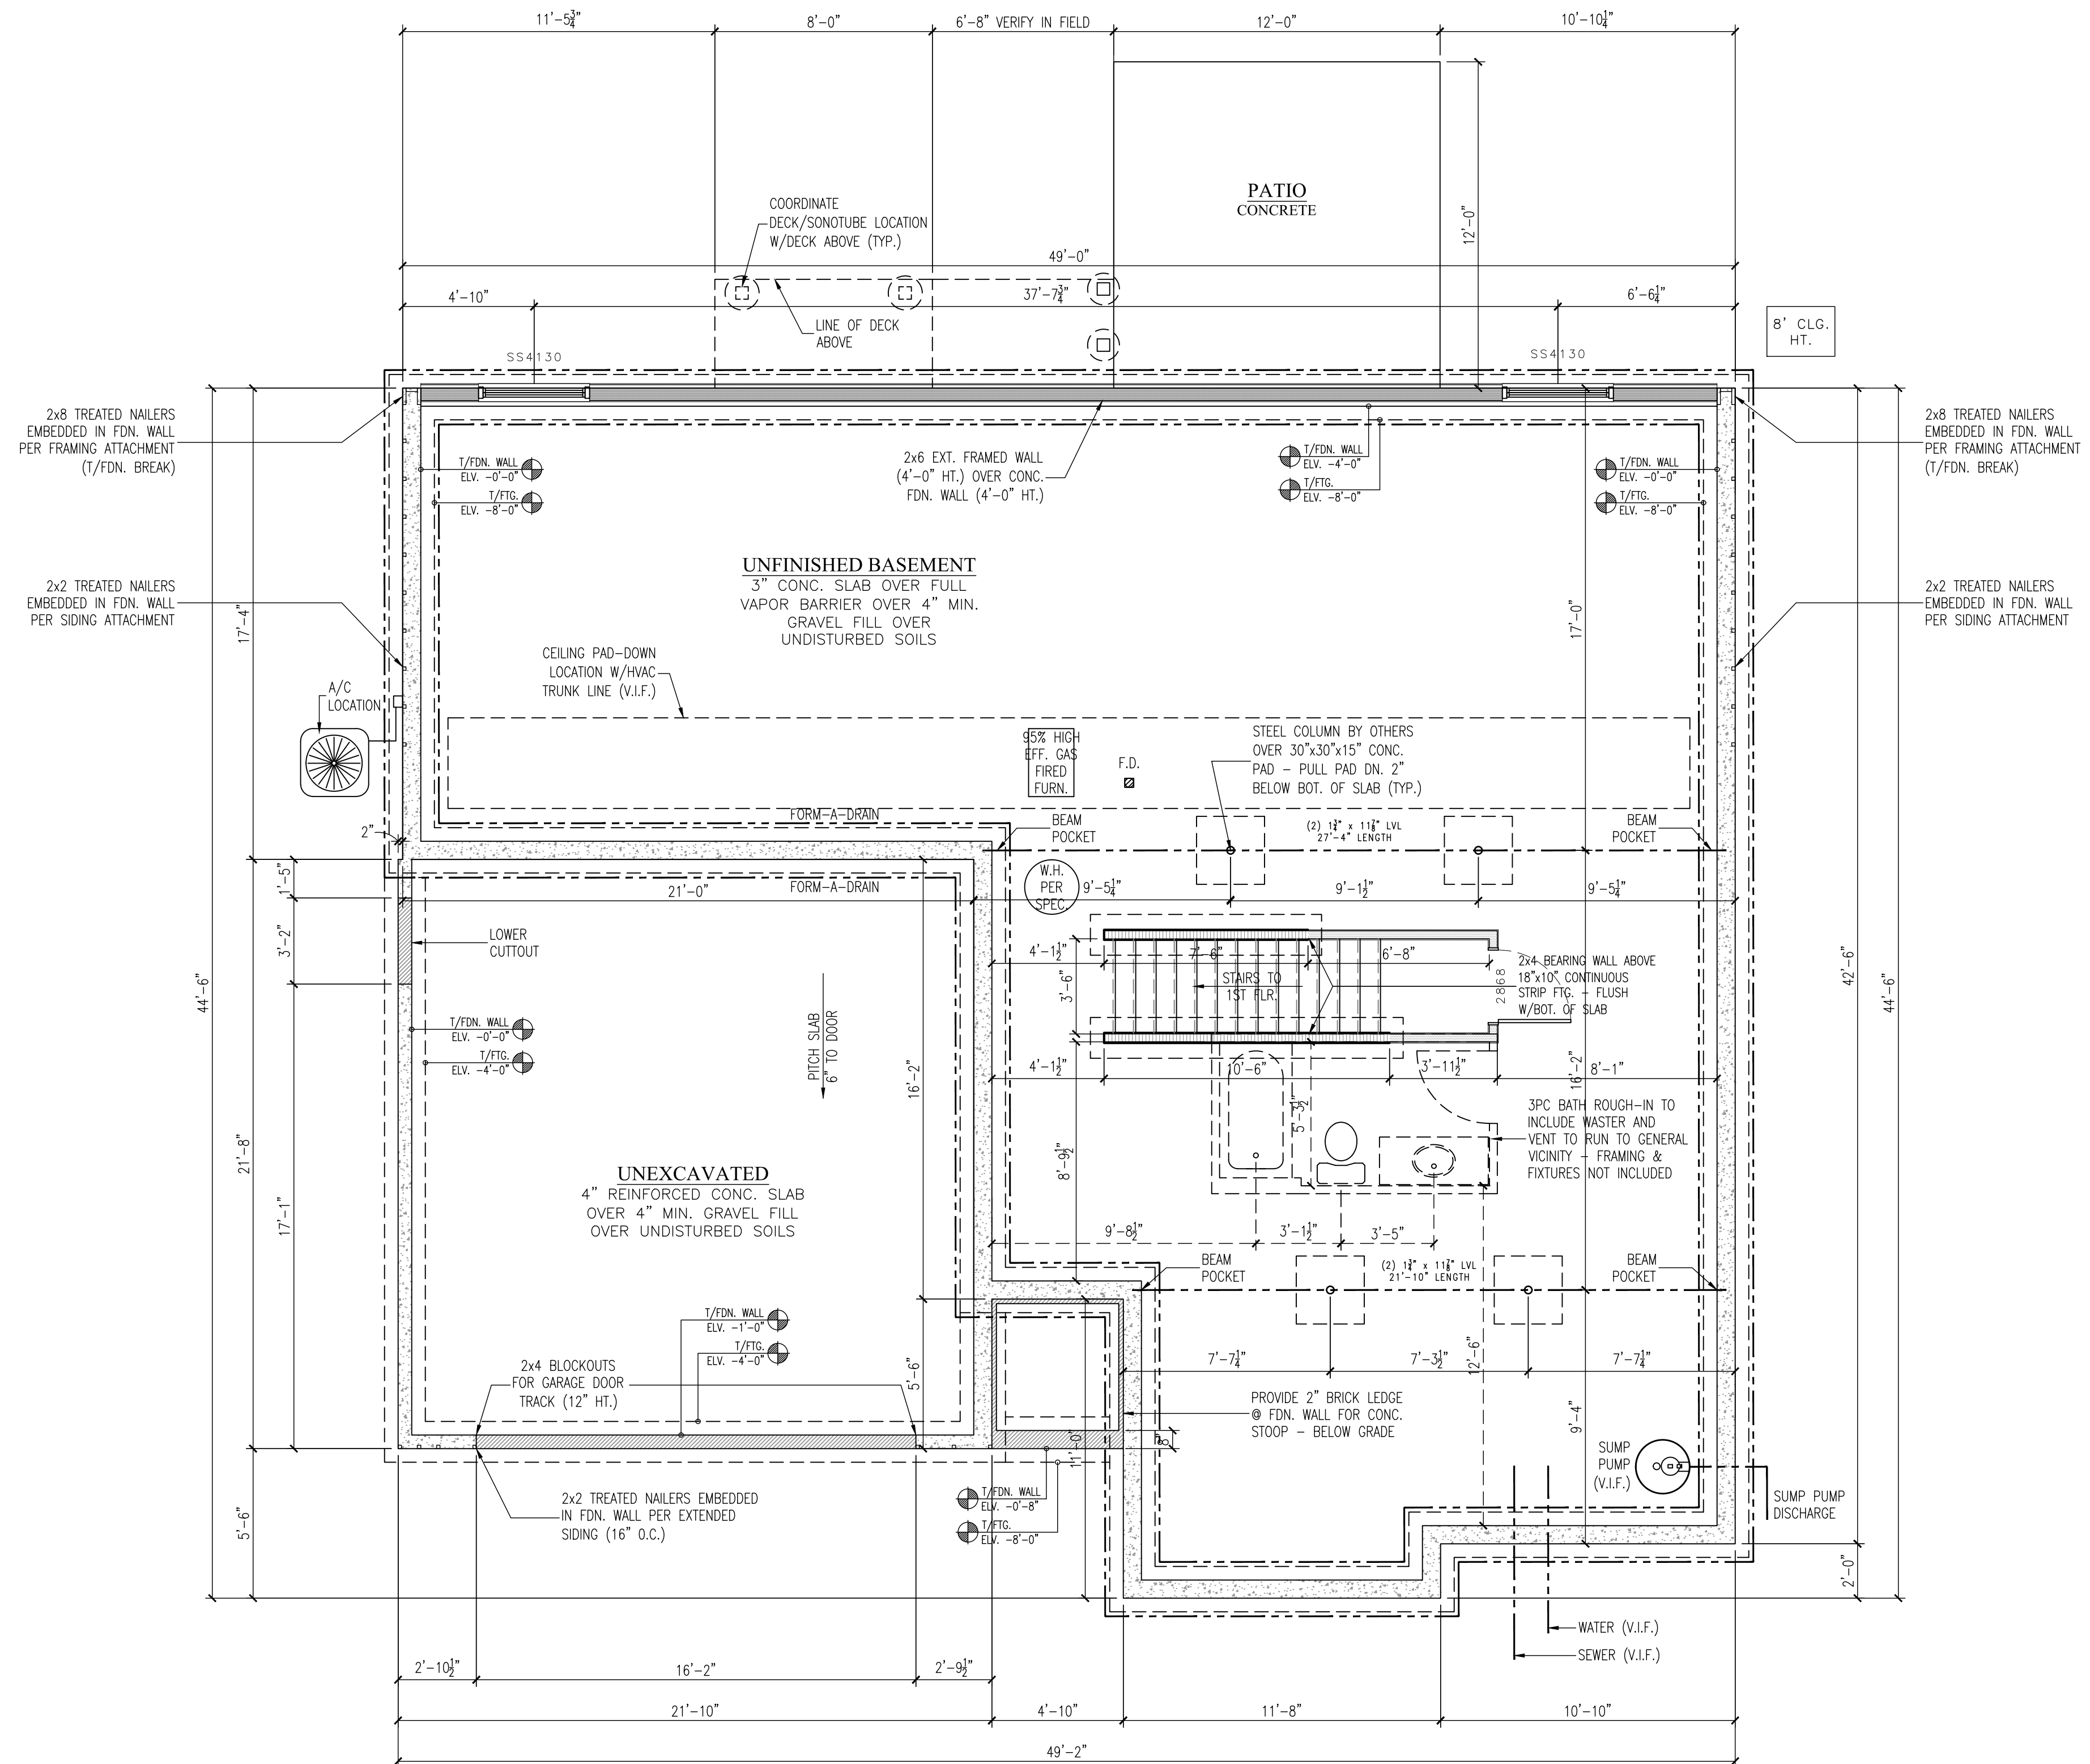

FIRST FLOOR PLAN

SCALE: 1/4" = 1'-0" (1/ 8" = 1'-0" 11x17)

NOTES:

FLOOR SYSTEM INFORMATION

- FIRST FLOOR DECK: 11³/₈" ENGINEERED "I" JOIST BY OTHERS 16" (SERIES PER MANUFACTURER).

WALL INFORMATION

- EXTERIOR WALLS: 92³/₈" 2x4 #2SPF STUD GRADE OR BETTER @ 16" O.C.
- INTERIOR BEARING WALLS: 92³/₈" 2x #2SPF STUD GRADE OR BETTER @ 16" O.C.
- INTERIOR WALLS: 92³/₈" 2x4 #2SPF STUD GRADE OR BETTER @ 16" O.C.

WINDOW INFORMATION

- ALL WINDOW TYPE AND SIZED SHOWN ARE FOR ALLIANCE WINDOWS – REFER TO CATALOG FOR DETAILS.
- ALL WINDOW CALLOUTS IN GENERIC SIZES: FEET_INCH(WIDTH)_FEET_INCH(HEIGHT).
- ALL WINDOW HEADER HEIGHTS @ 6'-10¹/₂" FROM T/SUBFLOOR (UNLESS NOTED).

DOOR INFORMATION


- ALL BI-FOLD DOOR ROUGH OPENINGS TO BE 1¹/₂" WIDER THAN PLAN CALLOUT & 82" FROM T/FLR.
- ALL SINGLE POCKET DOORS (24"-36") ROUGH OPENINGS TO BE 2x THE DOOR WIDTH PLUS 1" & 85" FROM T/FLR.
- ALL DOUBLE POCKET DOOR (48"-72") ROUGH OPENINGS TO BE 2x THE DOOR WIDTH PLUS 1¹/₂" & 85" FROM T/FLR.

STAIR INFORMATION

- BASEMENT TO FIRST FLOOR: 14 RISERS @ 8" MAX RISE/13 TREADS @ 9" PLUS 1" NOSING – 10" OVERALL.

PLAN INFORMATION

- REFER TO TYPICAL WALL SECTION (SHT. D1) FOR ADDITIONAL INFORMATION.
- ALL PLAN DIMENSIONS ARE TO FACE OF STUD OR TO FACE OF STUD.
- THE CONDITIONS LISTED HERE ARE STANDARD FOR THIS PLAN ELEVATION(S). EXCEPTIONS ARE NOTED ON THE PLAN.

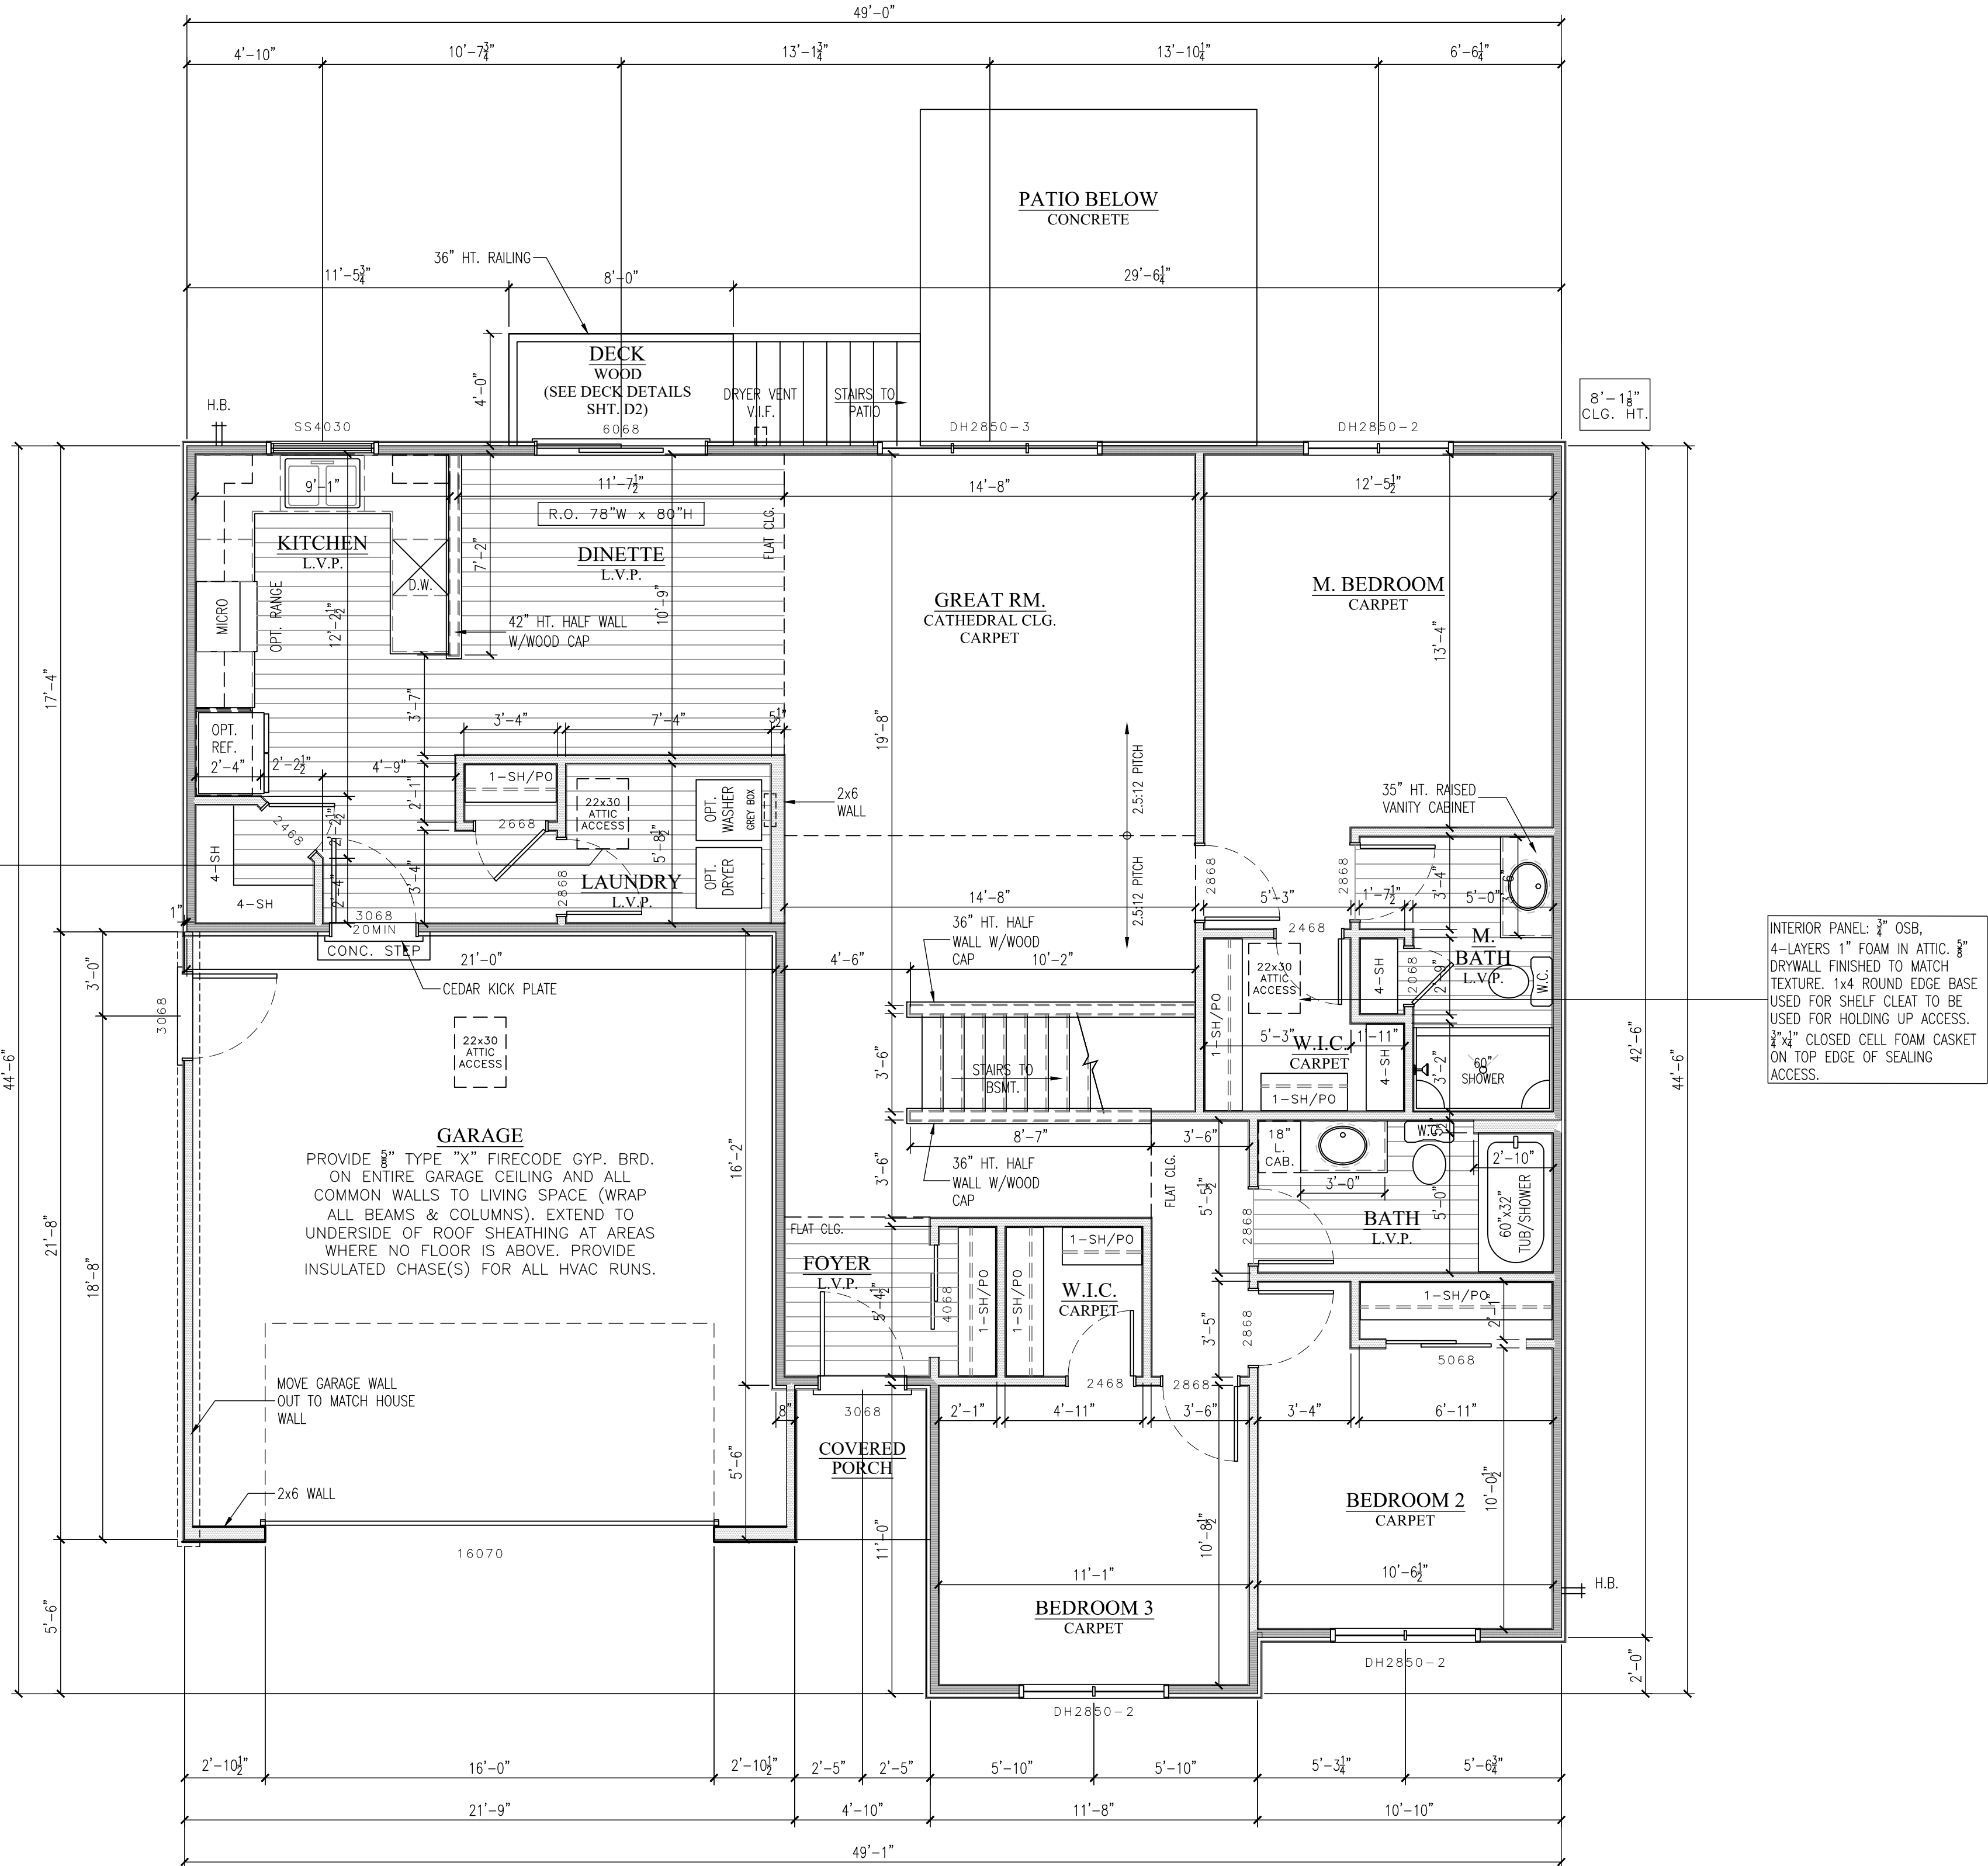

LAKE COUNTRY
DESIGN STUDIO, LLC

N51W35831 HILLCREST COURT
OCONOMOWOC, WI 53066
PH|920.723.7005

WWW.LCDSDESIGN.COM

CONTRACTOR
INFORMATION



LOOS CUSTOM
HOMES LLC

435 Village Walk Lane
Johnson Creek, WI 53038
PH|920.699.3787
FAX|920.699.7202

WWW.LOOSHOMES.COM

PROJECT
INFORMATION

MARKET HOME

SPRUCE MASTER

EDGE FIELD
LOT 46
1233 EDGE FIELD CT.
WATERTOWN, WI 53094

JOB NUMBER: 26EF46

8	----	----	----
7	----	----	----
6	7.14.26	SF UPDATE	KMS
5	7.13.26	PD5	KMS
4	6.24.26	PD4	KMS
3	6.22.26	PD3	KMS
2	5.26.26	PD2	KMS
1	3.17.26	PD1	KMS
NO.	DATE:	DESCRIPTION:	BY:
DRAWN BY:		DATE:	
KMS		3.17.26	

SHEET TITLE

FIRST FLOOR PLAN


JOB NUMBER

26EF46

SHEET NUMBER

A3

SHT 4 OF 8

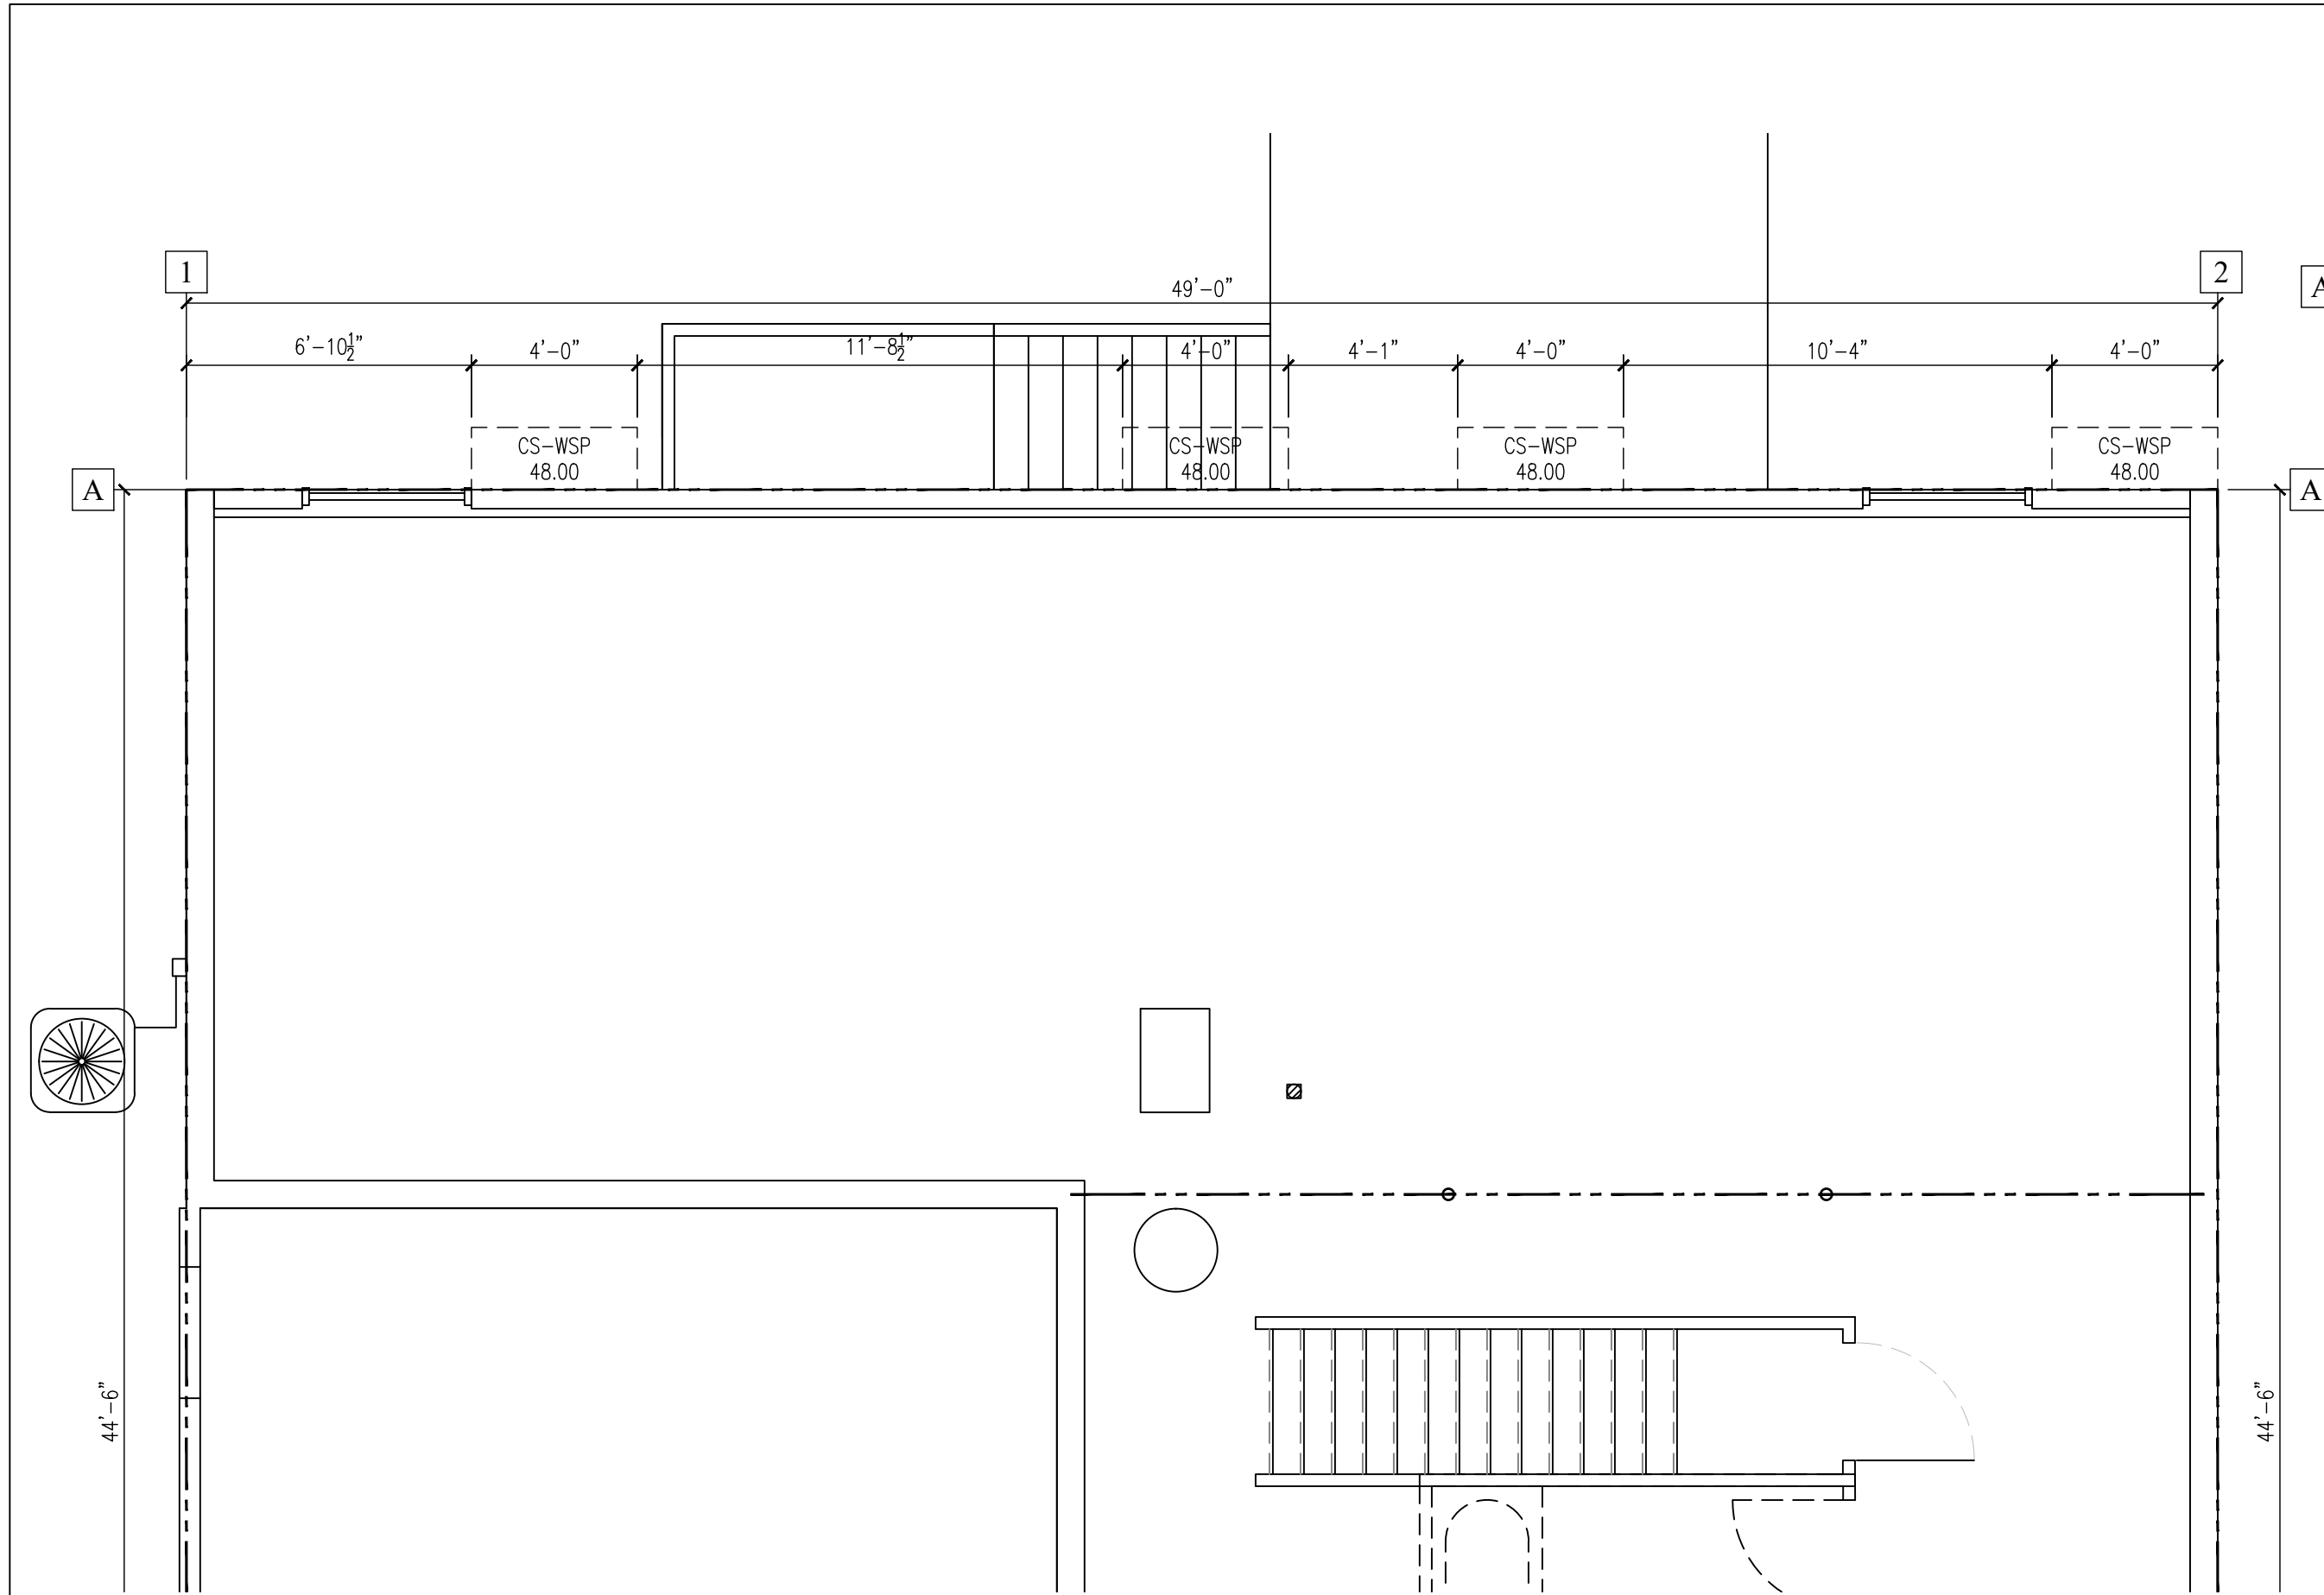


FOUNDATION BRACING PLAN

SCALE: 1/4" = 1'-0"

BRACE PANEL DESIGNATION INFORMATION						
PANEL DESIGNATION	BRACING METHOD	MATERIAL	MAXIMUM NOMINAL WALL HEIGHT	MINIMUM BRACED WALL PANEL WIDTH OR BRACE ANGLE	CONNECTION CRITERIA	
					MINIMUM FASTENERS	MAXIMUM SPACING
CS-WSP	CONTINUOUS	WOOD STRUCTURAL PANEL 7/16" OSB SHEATHING	10'	PER TABLE SPS 321.25-H OF THE WISCONSIN ADMINISTRATIVE CODE	6d COMMON NAIL OR 8d BOX NAIL (2 1/2" LONG x 0.113" DIAMETER) OR 7/16" CROWN 16 GAGE STAPLES, 1 1/4" LONG	6" EDGES, 12" FIELD (NAILS) 3" EDGES, 6" FILED (STAPLES)
CS-PF (PORTAL FRAME)	CONTINUOUS (NARROW PANEL BRACING)	7/16" OSB SHEATHING	12'	SEE PORTAL FRAME DETAIL	SEE PORTAL FRAME DETAIL	SEE PORTAL FRAME DETAIL
WSP	INTERMITTENT	WOOD STRUCTURAL PANEL 7/16" OSB SHEATHING	10'	48" (36" PANEL COUNTS AS 1/2 PANEL)	6d COMMON NAIL OR 8d BOX NAIL (2 1/2" LONG x 0.113" DIAMETER) OR 7/16" CROWN 16 GAGE STAPLES, 1 1/4" LONG	6" EDGES, 12" FIELD (NAILS) 3" EDGES, 6" FILED (STAPLES)
LIB	INTERMITTENT	LET-IN-BRACING (METAL BRACE INSTALLED PER MANUFACTURERS INSTRUCTIONS)	10'	48 ANGLE MAX 16" O.C. STUD SPACING (60 DEGREE BRACE COUNTS AS 1/2 PANEL)	2-8d COMMON NAILS OR 3-8d BOX NAILS (2 1/2" LONG x 0.133" DIAMETER)	PER STUD AND TOP AND BOTTOM PLATES
GB	INTERMITTENT	GYPSUM BOARD 1/2" FOR MAX 24" O.C. STUD SPACING (INSTALLED BOTH SIDES OF WALL)	10'	96" (48" COUNTS AS 1/2 PANEL)	5d COOLER NAILS OR #6 SCREWS	7" EDGES, 7" FILED
PF (PORTAL FRAME)	INTERMITTENT (NARROW PANEL BRACING)	7/16" OSB SHEATHING	12'	SEE PORTAL FRAME DETAIL (ALL LENGTHS COUNT AS 1/2 PANEL)	SEE PORTAL FRAME DETAIL	SEE PORTAL FRAME DETAIL

- NOTES
- EACH WOOD STRUCTURAL PANEL MAY CONTAIN NO MORE THAN ONE HOLE, HAVING A MAXIMUM DIMENSION NO MORE THAN 10 PERCENT OF THE LEAST DIMENSION OF THE PANEL, AND CONFINED TO THE MIDDLE THREE-FOURTHS OF THE PANEL.
 - BLOCKING TO BE PROVIDED AT ALL SPLICE JOINTS ON CS-WSP PANELS

WALL BRACING SCHEDULE NOTES		
REQUIRED BRACE UNIT LENGTH INCORPORATED WHETHER WALL SUPPORTS ROOF & CEILING ONLY: ONE FLOOR, ROOF & CEILING OR TWO FLOORS, ROOF & CEILING PER TABLES SPS 321.25-1 (INTERMITTENT METHOD) & SPS 321.25-J (CONTINUOUS METHOD) OF THE WISCONSIN ADMINISTRATIVE CODE.	WIND FACTOR: TOTAL INCLUDES WIND EXPOSURE FACTOR, WALL HEIGHT FACTOR, AND EAVE TO RIDGE FACTOR.	INTERPOLATION USED IN BRACING CALCULATIONS

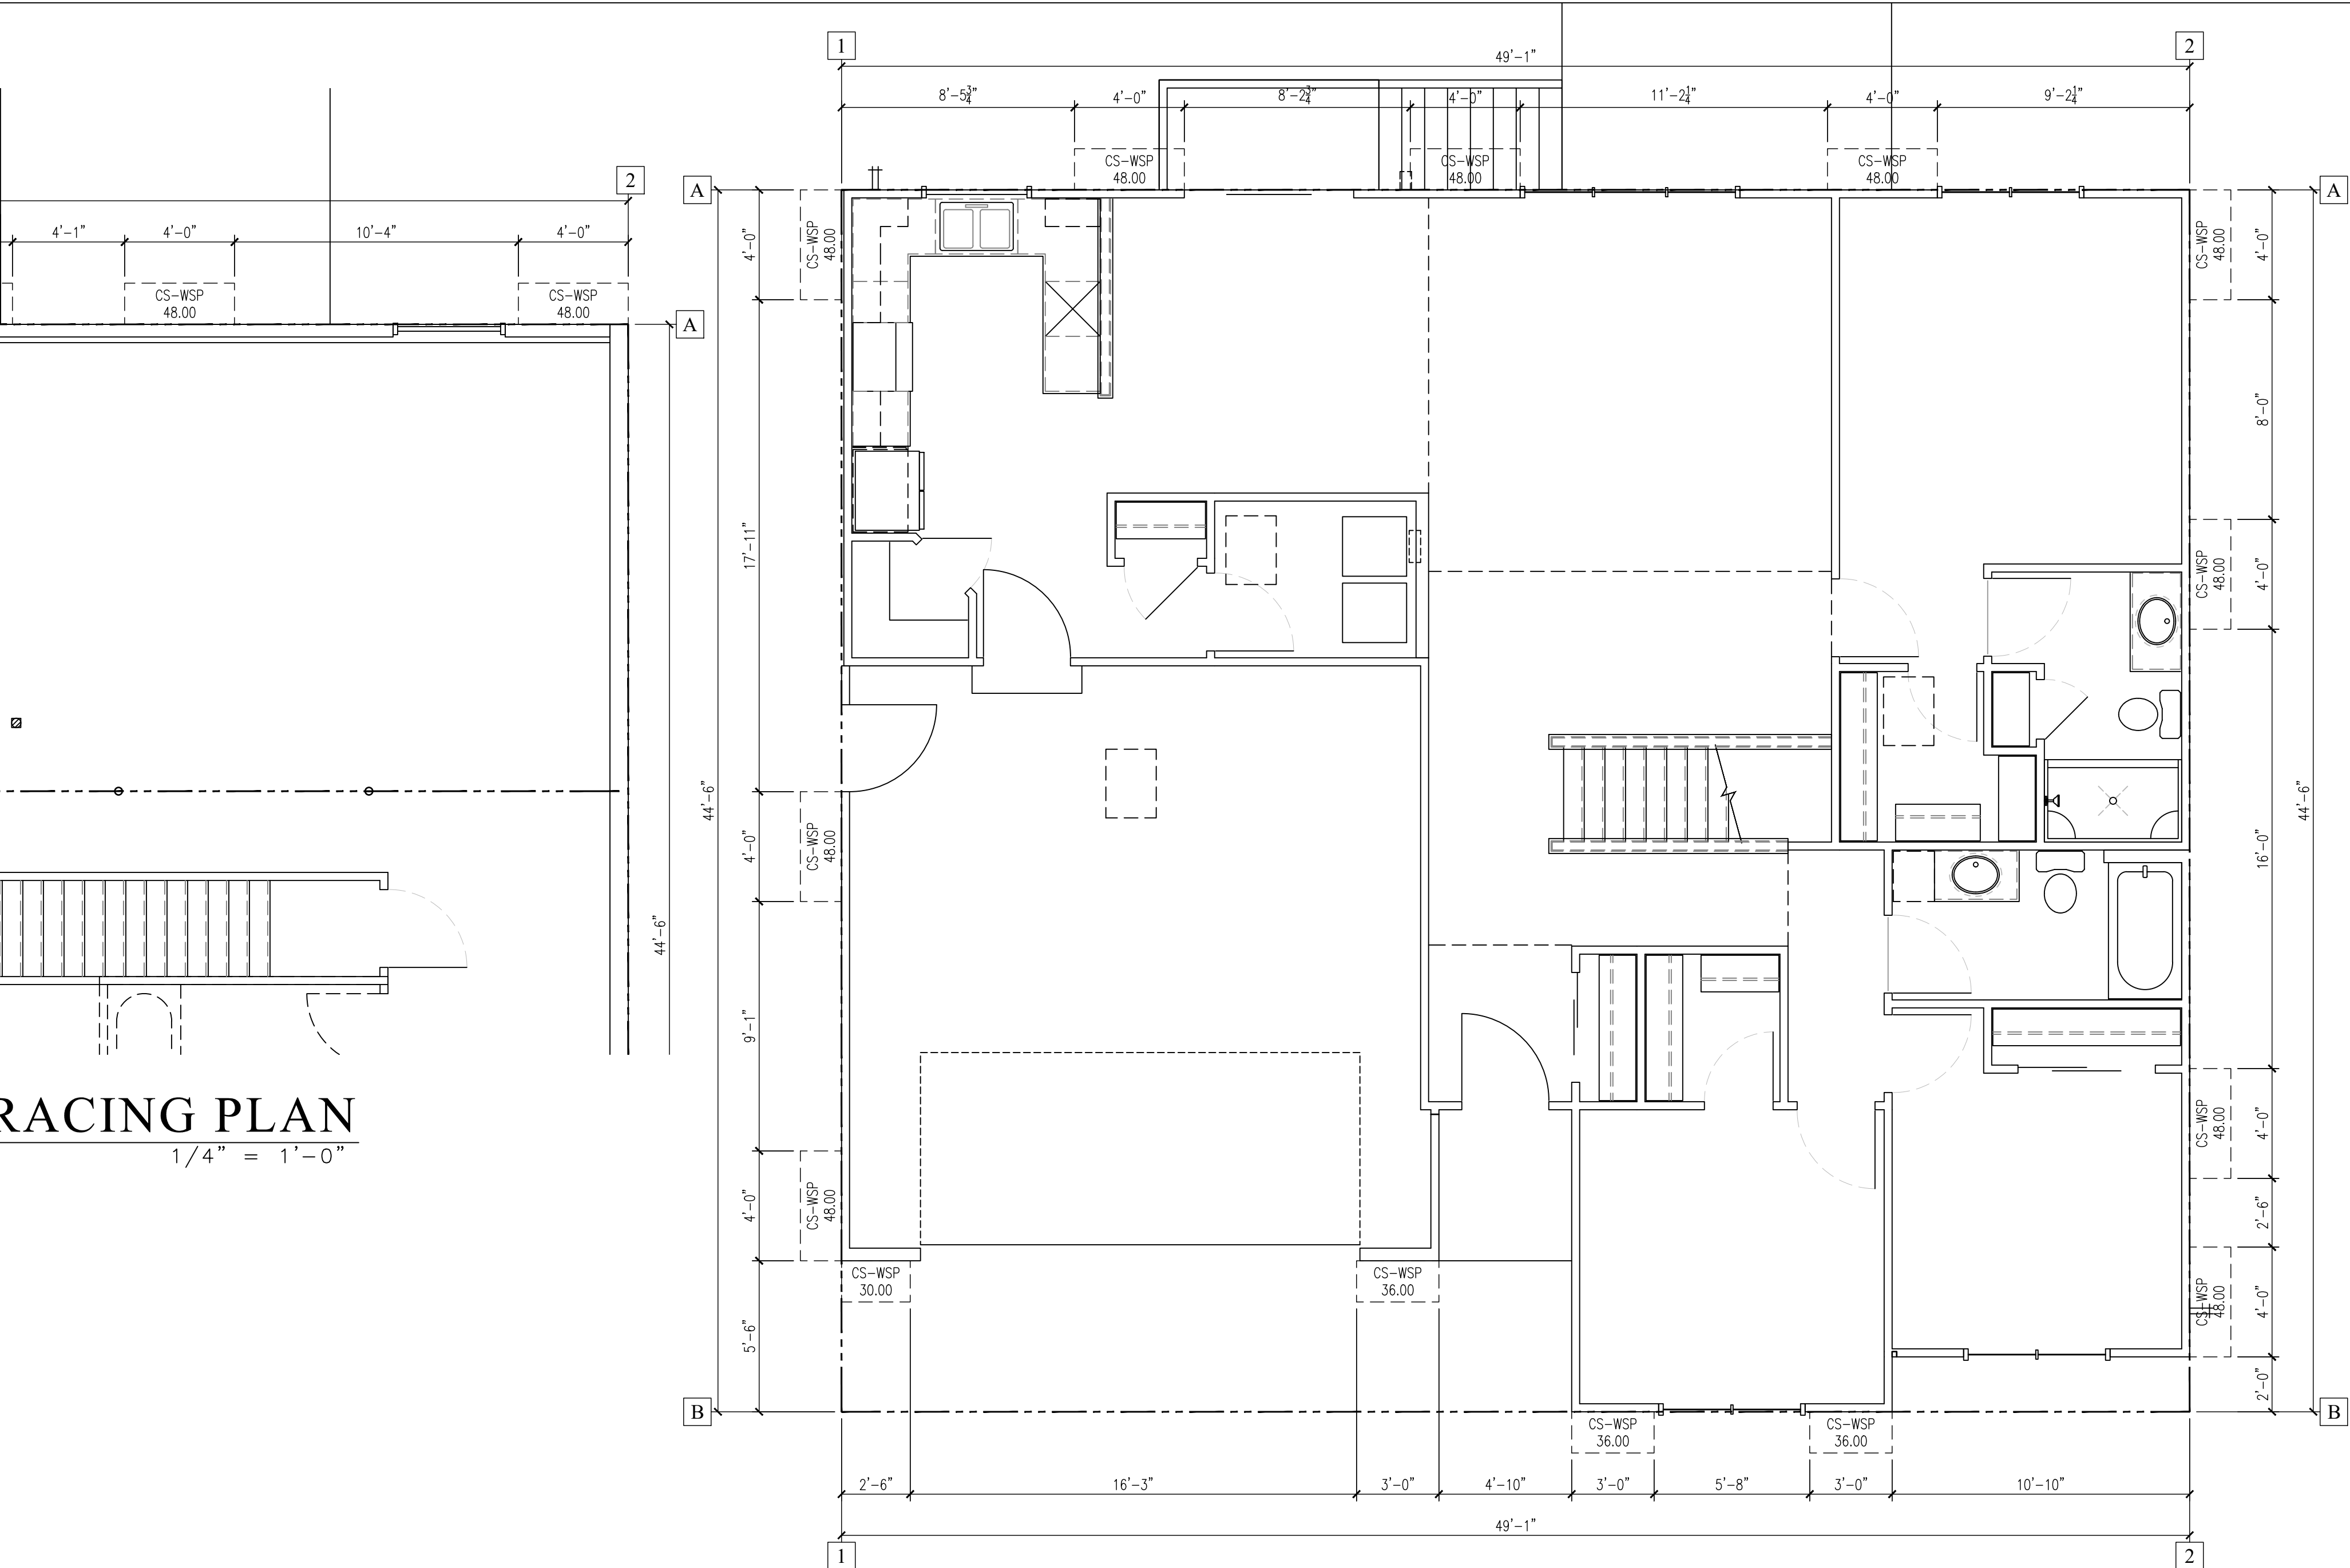

FIRST FLOOR BRACING PLAN

SCALE: 1/4" = 1'-0"

FOUNDATION WALL BRACING SCHEDULE											
PROJECT WIND EXPOSURE CATEGORY: B											
WALL BRACE LINE	BRACE MATERIAL	BRACING METHOD	BRACE LINE SPACING	REQUIRED BRACE UNIT LENGTH (CONTINUOUS METHOD ONLY)	WIND EXPOSURE FACTOR	WALL HEIGHT FACTOR	DRYWALL OMISSION FACTOR	WIND FACTOR TOTAL	TOTAL BRACE UNIT LENGTH REQUIRED -FEET- (CONTINUOUS METHOD ONLY)	TOTAL BRACE UNIT LENGTH PROVIDED -FEET- (CONTINUOUS METHOD ONLY)	MAX OPENING HT. (ADJACENT TO PANEL - CONTINUOUS METHOD ONLY)
A	7/16" OSB SHEATHING	CONTINUOUS	50.00'	14.50'	1.00	1.00	1.00	1.00	14.50'	16.00'	3'-0"
FIRST FLOOR WALL BRACING SCHEDULE											
PROJECT WIND EXPOSURE CATEGORY: B											
WALL BRACE LINE	BRACE MATERIAL	BRACING METHOD	BRACE LINE SPACING	REQUIRED BRACE UNIT LENGTH (CONTINUOUS METHOD ONLY)	WIND EXPOSURE FACTOR	WALL HEIGHT FACTOR	DRYWALL OMISSION FACTOR	WIND FACTOR TOTAL	TOTAL BRACE UNIT LENGTH REQUIRED -FEET- (CONTINUOUS METHOD ONLY)	TOTAL BRACE UNIT LENGTH PROVIDED -FEET- (CONTINUOUS METHOD ONLY)	MAX OPENING HT. (ADJACENT TO PANEL - CONTINUOUS METHOD ONLY)
A	7/16" OSB SHEATHING	CONTINUOUS	50.00'	7.50'	1.00	1.00	1.00	1.00	7.50'	12.00'	6'-10"
B	7/16" OSB SHEATHING	CONTINUOUS	50.00'	7.50'	1.00	1.00	1.40	1.40	10.50'	11.00'	6'-4"
1	7/16" OSB SHEATHING	CONTINUOUS	50.00'	7.50'	1.00	1.00	1.00	1.00	7.50'	16.00'	5'-0"
2	7/16" OSB SHEATHING	CONTINUOUS	50.00'	7.50'	1.00	1.00	1.40	1.40	10.50'	12.00'	NA

LAKE COUNTRY
DESIGN STUDIO, LLC

N51W35831 HILLCREST COURT
OCONOMOWOC, WI 53086
PH|920.723.7005

WWW.LCDSDESIGN.COM

CONTRACTOR
INFORMATION



LOOS CUSTOM
HOMES LLC

435 Village Walk Lane
Johnson Creek, WI 53038
PH|920.699.3787
FAX|920.699.7202

WWW.LOOSHOMES.COM

PROJECT
INFORMATION

MARKET HOME

SPRUCE MASTER

EDGE FIELD
LOT 46
1233 EDGE FIELD CT.
WATERTOWN, WI 53094

JOB NUMBER: 26EF46

8	----	----	----
7	----	----	----
6	7.14.26	SF UPDATE	KMS
5	7.13.26	PD5	KMS
4	6.24.26	PD4	KMS
3	6.22.26	PD3	KMS
2	5.26.26	PD2	KMS
1	3.17.26	PD1	KMS
NO.	DATE:	DESCRIPTION:	BY:
	DRAWN BY: KMS	DATE: 3.17.26	

SHEET TITLE

FOUNDATION &
FIRST FLOOR
BRACING PLAN


JOB NUMBER

26EF46

SHEET NUMBER

A4

SHT 5 OF 8

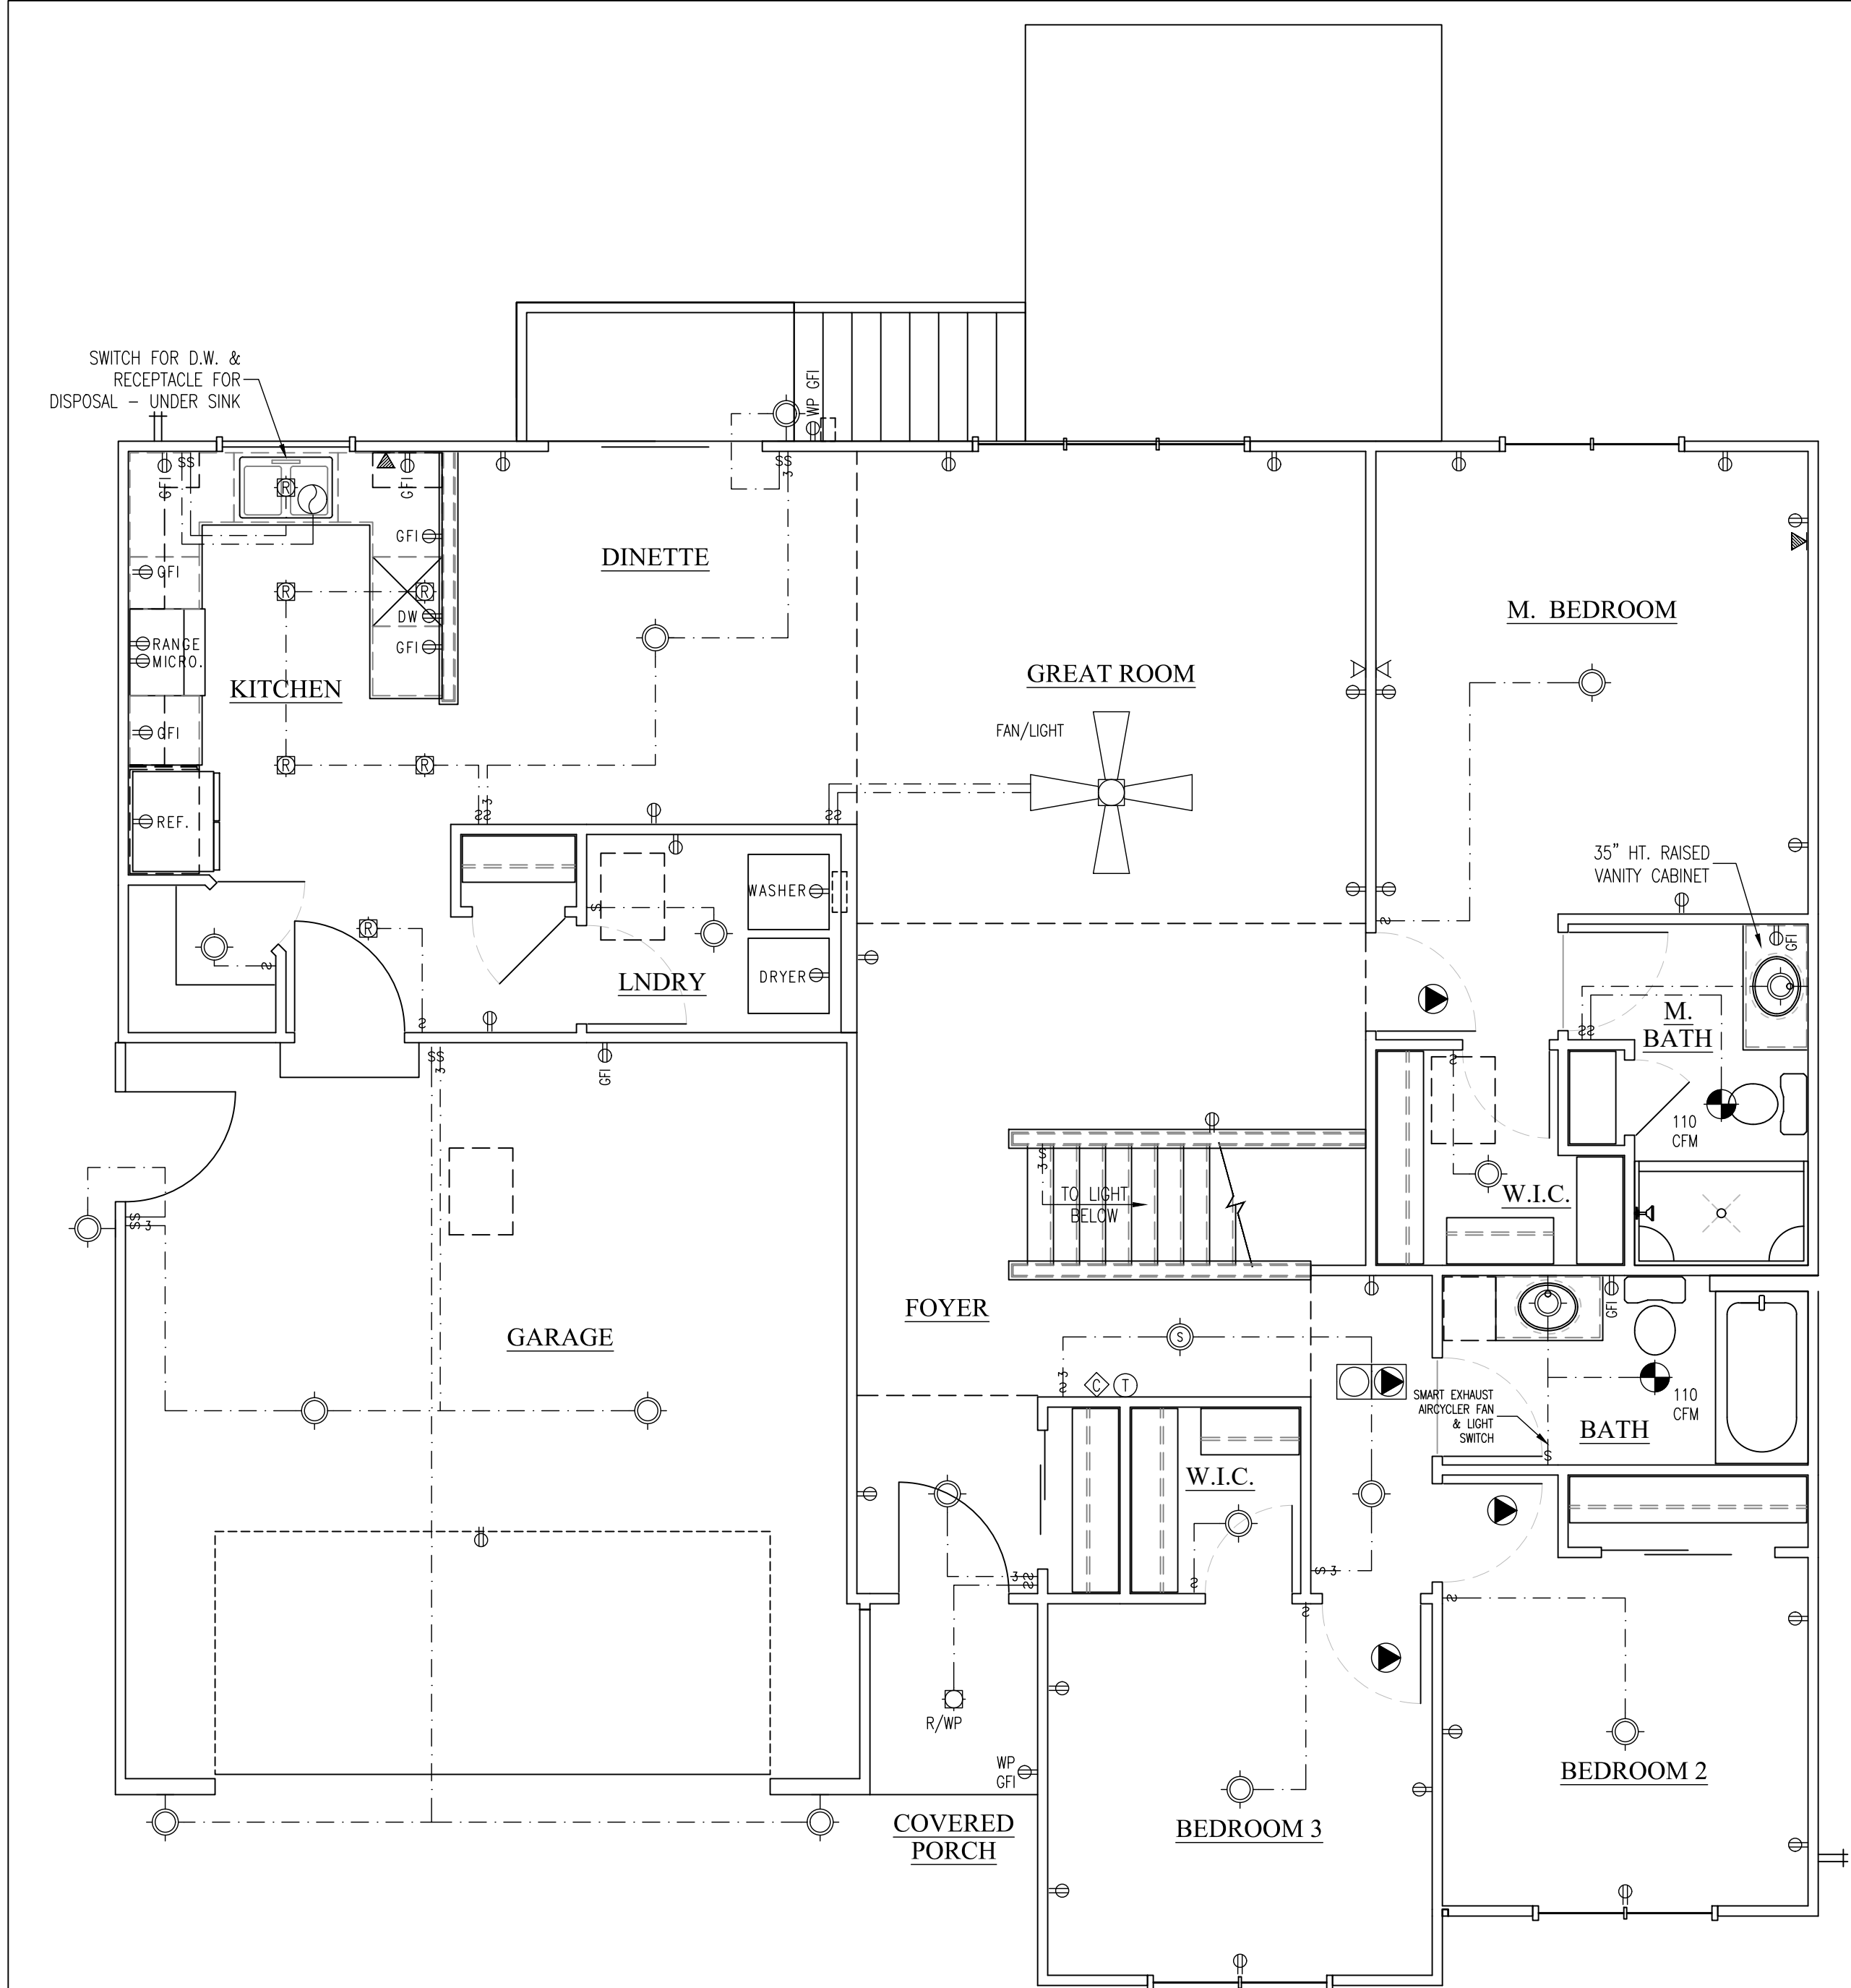


ELECTRICAL SYMBOLS			
	FAN/LIGHT KIT		FAN/LIGHT
			FAN
			TV OUTLET
			PHONE OUTLET
			SINGLE POLE SWITCH
			THREE WAY SWITCH
			FOUR WAY SWITCH
			DIMMER SWITCH
			DUPLEX OUTLET (15-20 AMP)
			DUPLEX OUTLET (15-20 AMP) ONE HALF SWITCHED
			REINFORCED CEILING OUTLET (15-20 AMP) ONE HALF SWITCHED
			INDICATES GROUND FAULT INTERRUPT
			INDICATES WATERPROOF
			INDICATES SLOPED CEILING
			DOOR CHIME
			GARBAGE DISPOSAL
			ELECTRICAL PANEL

FOUNDATION
ELECTRICAL PLAN

SCALE: 1/4" = 1'-0"

THE LOCATION OF OUTLETS SHOWN ARE TO BE VERIFIED IN THE FIELD & COMPLY WITH THE ELECTRICAL CODE

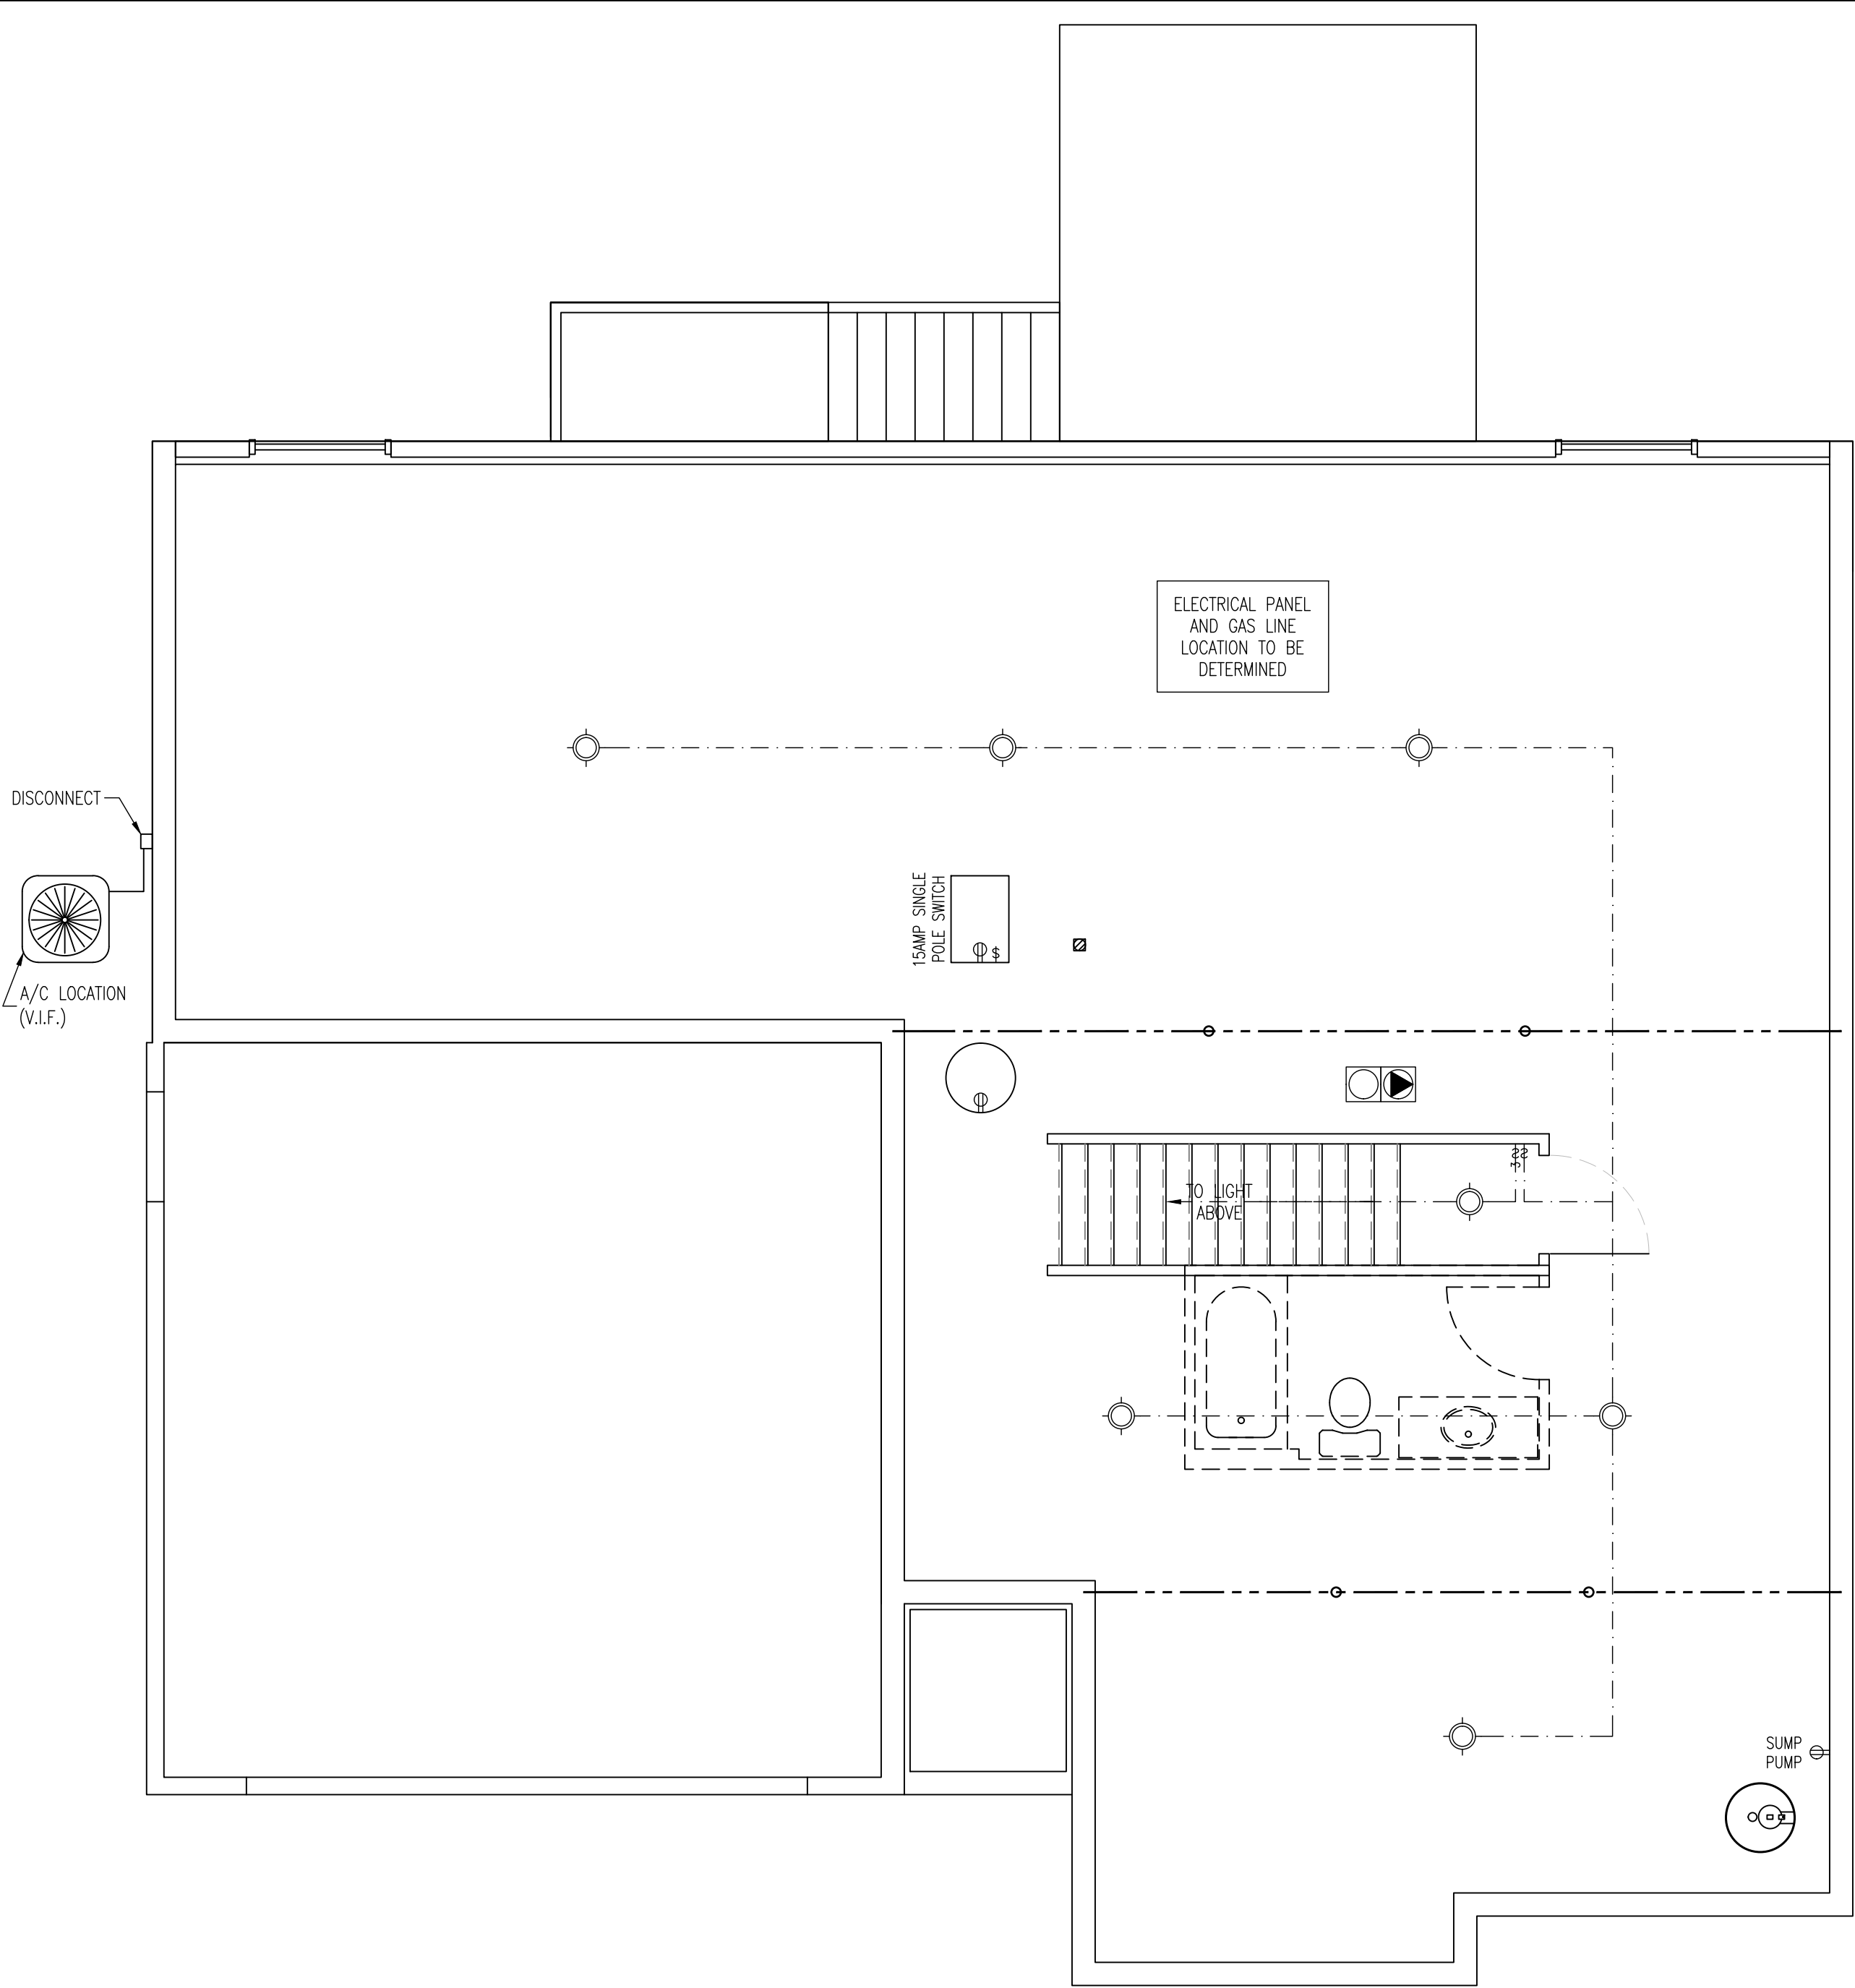

FIRST FLOOR
ELECTRICAL PLAN

SCALE: 1/4" = 1'-0"

THE LOCATION OF OUTLETS SHOWN ARE TO BE VERIFIED IN THE FIELD & COMPLY WITH THE ELECTRICAL CODE

LAKE COUNTRY
DESIGN STUDIO, LLC

N51W35831 HILLCREST COURT
OCONOMOWOC, WI 53086
PH|920.723.7005

WWW.LCDSDESIGN.COM

CONTRACTOR
INFORMATION



LOOS CUSTOM
HOMES LLC

435 Village Walk Lane
Johnson Creek, WI 53038
PH|920.699.3787
FAX|920.699.7202

WWW.LOOSHOMES.COM

PROJECT
INFORMATION

MARKET HOME

SPRUCE MASTER

EDGE FIELD
LOT 46
1233 EDGE FIELD CT.
WATERTOWN, WI 53094

JOB NUMBER: 26EF46

8	----	----	----
7	----	----	----
6	7.14.26	SF UPDATE	KMS
5	7.13.26	PD5	KMS
4	6.24.26	PD4	KMS
3	6.22.26	PD3	KMS
2	5.26.26	PD2	KMS
1	3.17.26	PD1	KMS
NO.	DATE:	DESCRIPTION:	BY:
	DRAWN BY: KMS	DATE: 3.17.26	

SHEET TITLE

FOUNDATION &
FIRST FLOOR
ELECTRICAL PLAN

JOB NUMBER

26EF46

SHEET NUMBER

E1

N51W35831 HILLCREST COURT
OCONOMOWOC, WI 53066
PH|920.723.7005

W W W . L C D S D E S I G N . C O M

CONTRACTOR
INFORMATION

**LOOS CUSTOM
HOMES LLC**

435 Village Walk Lane
Johnson Creek, WI 53038
PH|920.699.3787
FAX|920.699.7202

WWW.LOOSHOMES.COM

PROJECT INFORMATION

MARKET HOME

SPRUCE MASTER

EDGE FIELD
LOT 46
1233 EDGE FIELD CT.
WATERTOWN, WI 53094

JOB NUMBER: 26EF46

8	----	----	----
7	----	----	----
6	7.14.26	SF UPDATE	KMS
5	7.13.26	PD5	KMS
4	6.24.26	PD4	KMS
3	6.22.26	PD3	KMS
2	5.26.26	PD2	KMS
1	3.17.26	PD1	KMS
NO.	DATE:	DESCRIPTION:	BY:
DRAWN BY: KMS		DATE: 3.17.26	

SHEET TITLE

TYPICAL WALL SECTION & BUILDING DETAILS


JOB NUMBER

26EF46

SHEET NUMBER

D1

SHT 7 OF 8

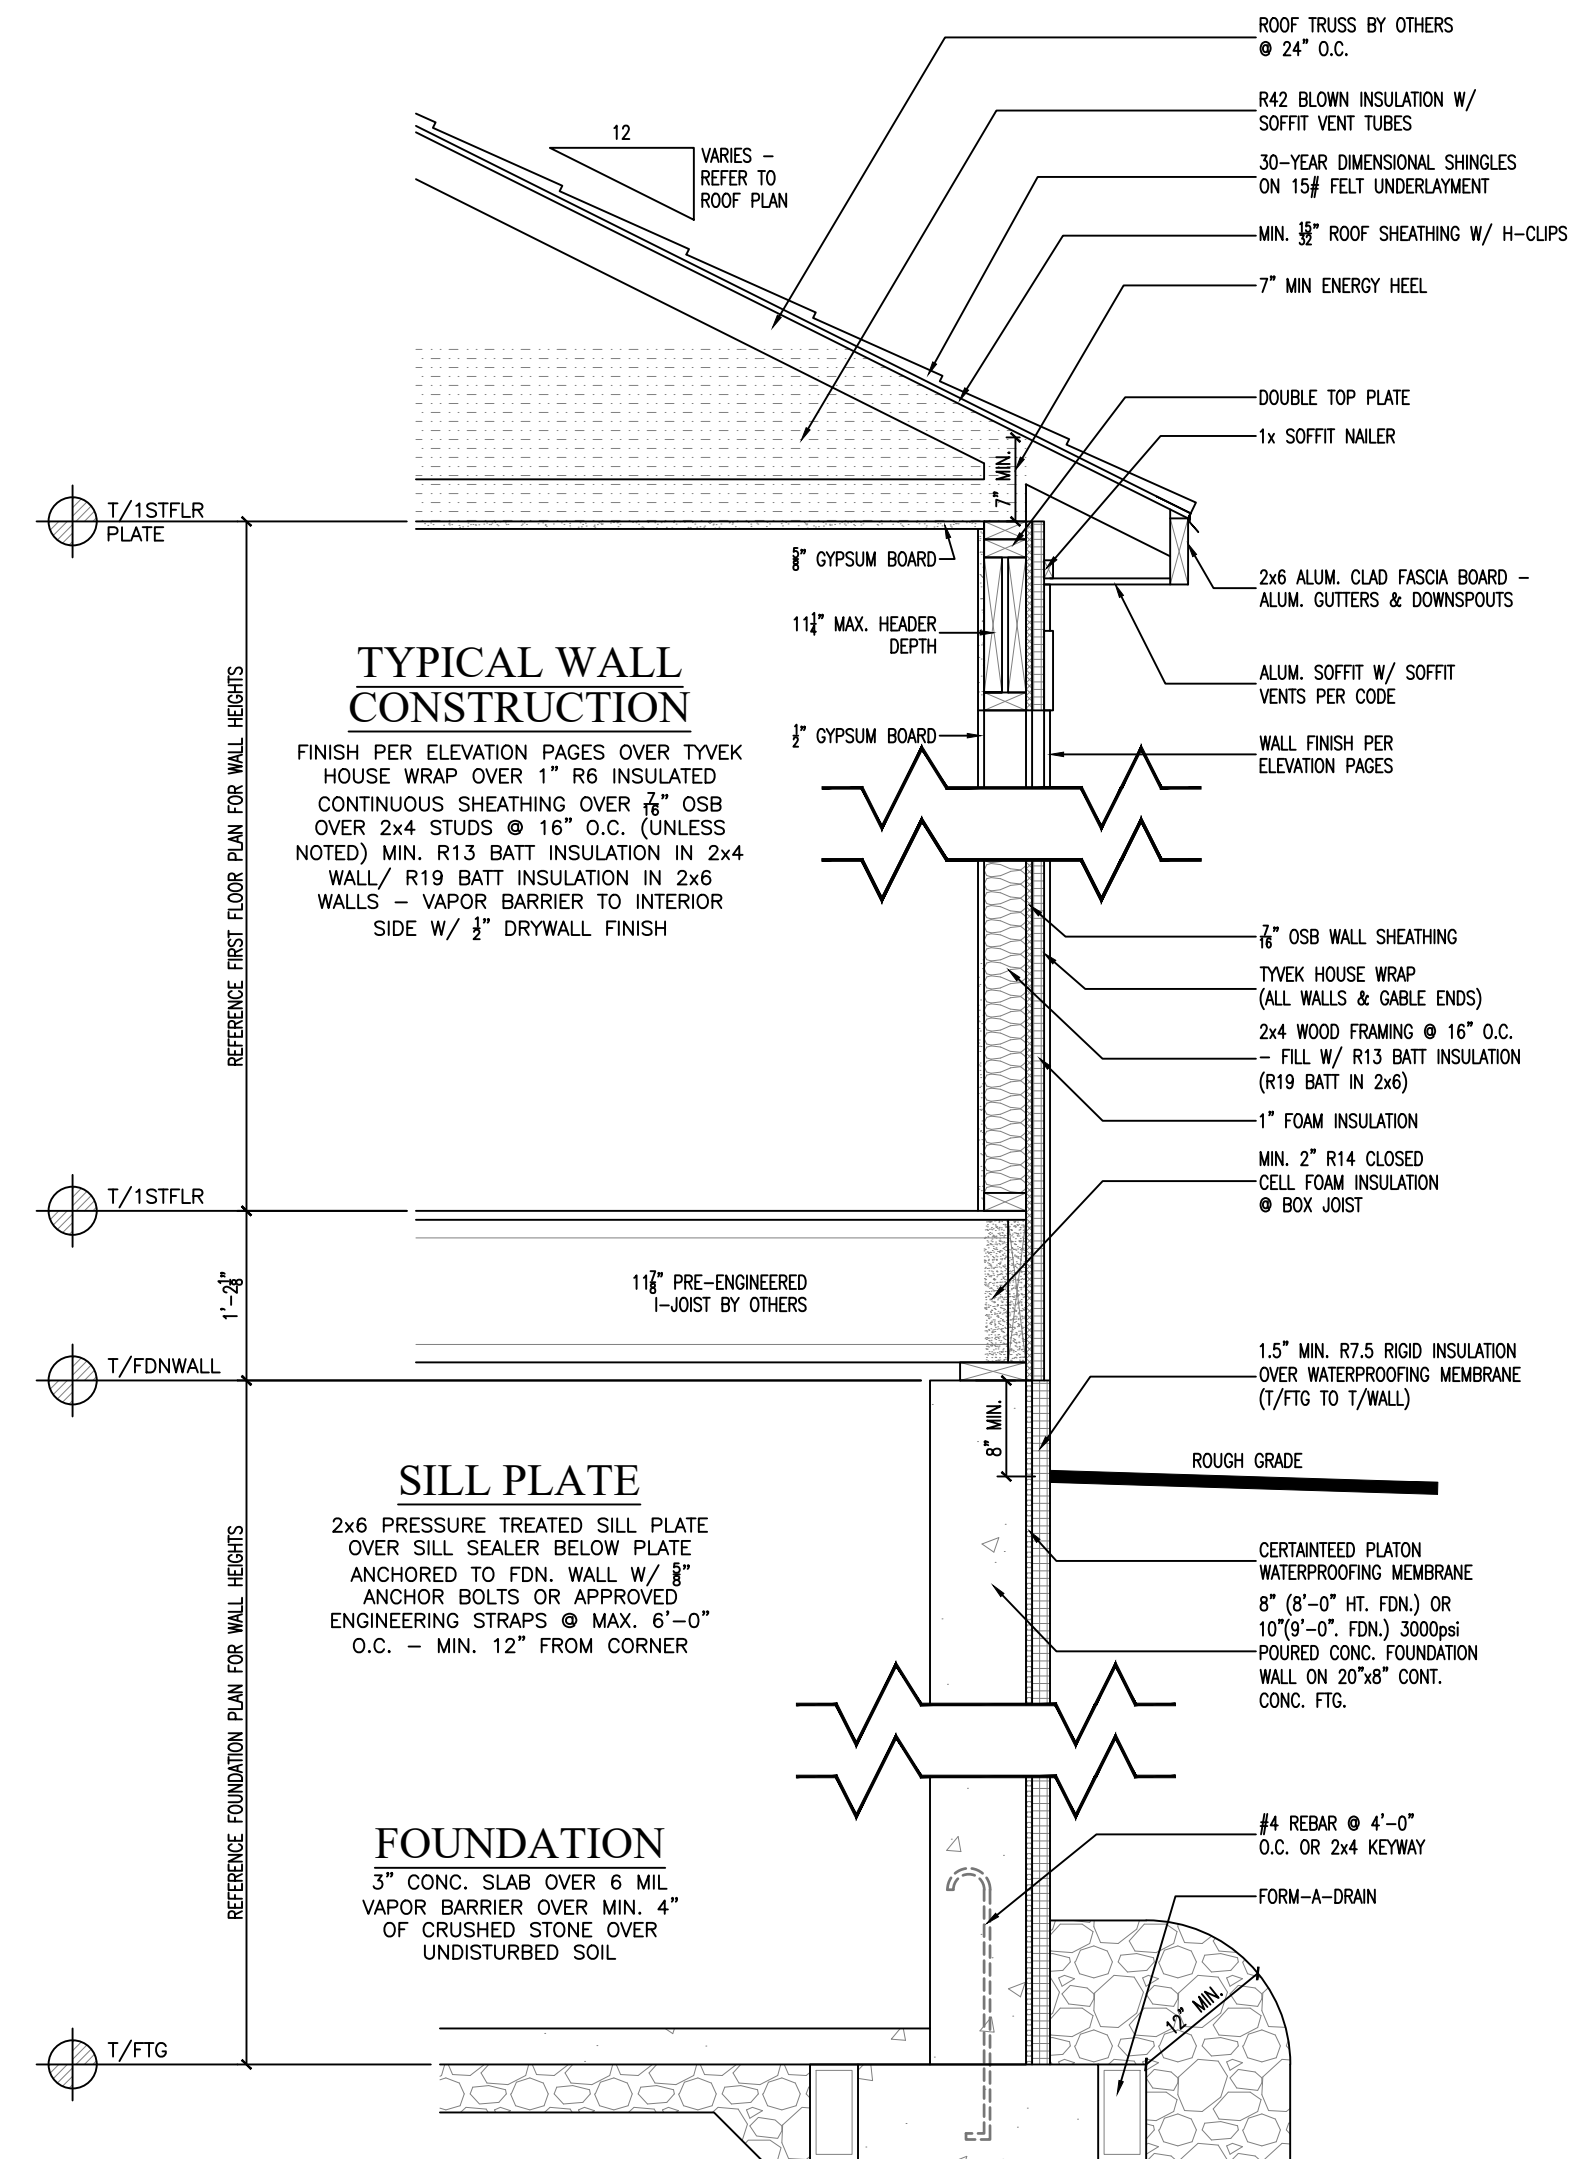


TYPICAL WALL SECTION


SCALE: $3/4" = 1'-0"$

NOTES:


- FILL ALL GAPS W/INSULATION AT GIRDER TRUSSES & JOISTS
- COVER ALL SEAMS AT BOTTOM PLATE OF EXTERIOR WALLS

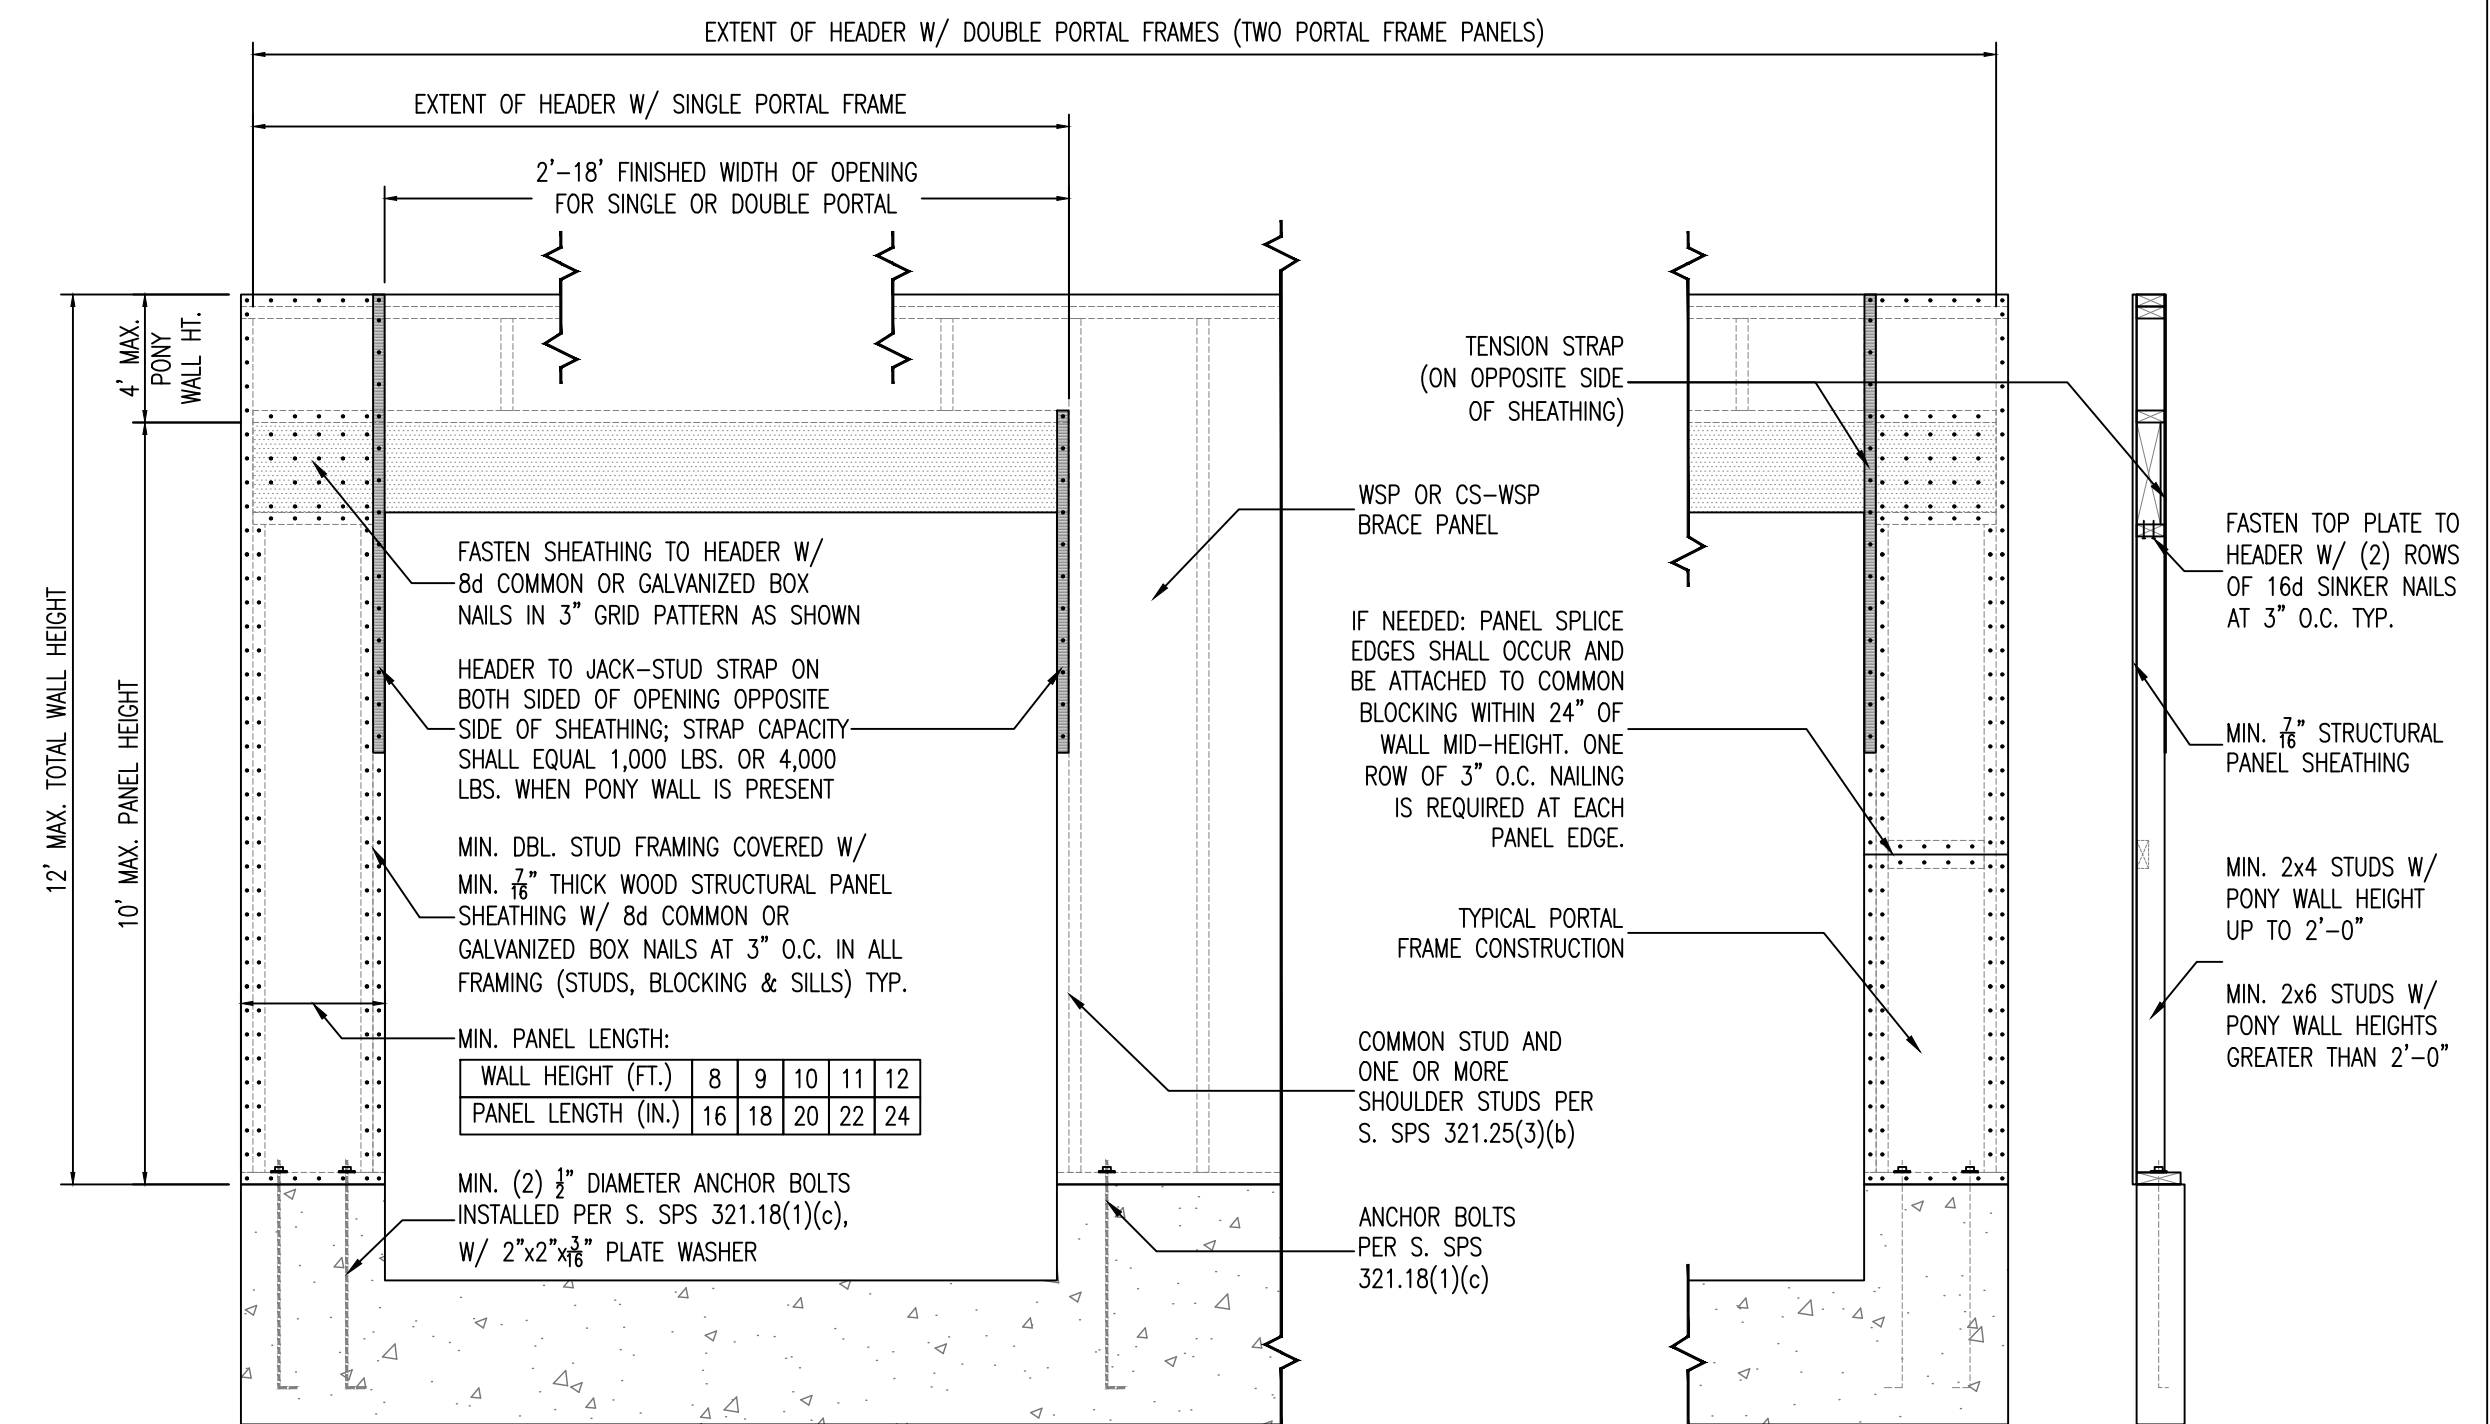

OVER CONCRETE OR MASONRY BLOCK FOUNDATION

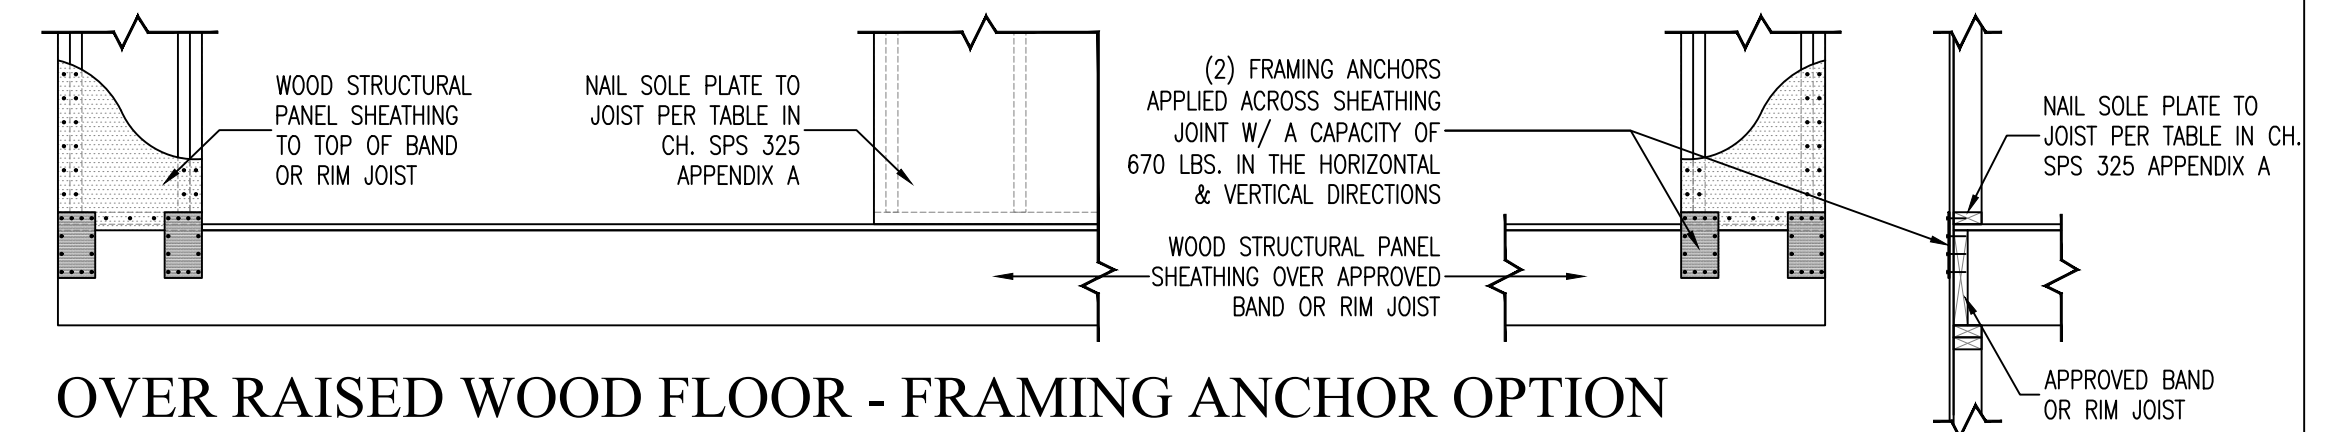

OVER RAISED WOOD FLOOR - FRAMING ANCHOR OPTION

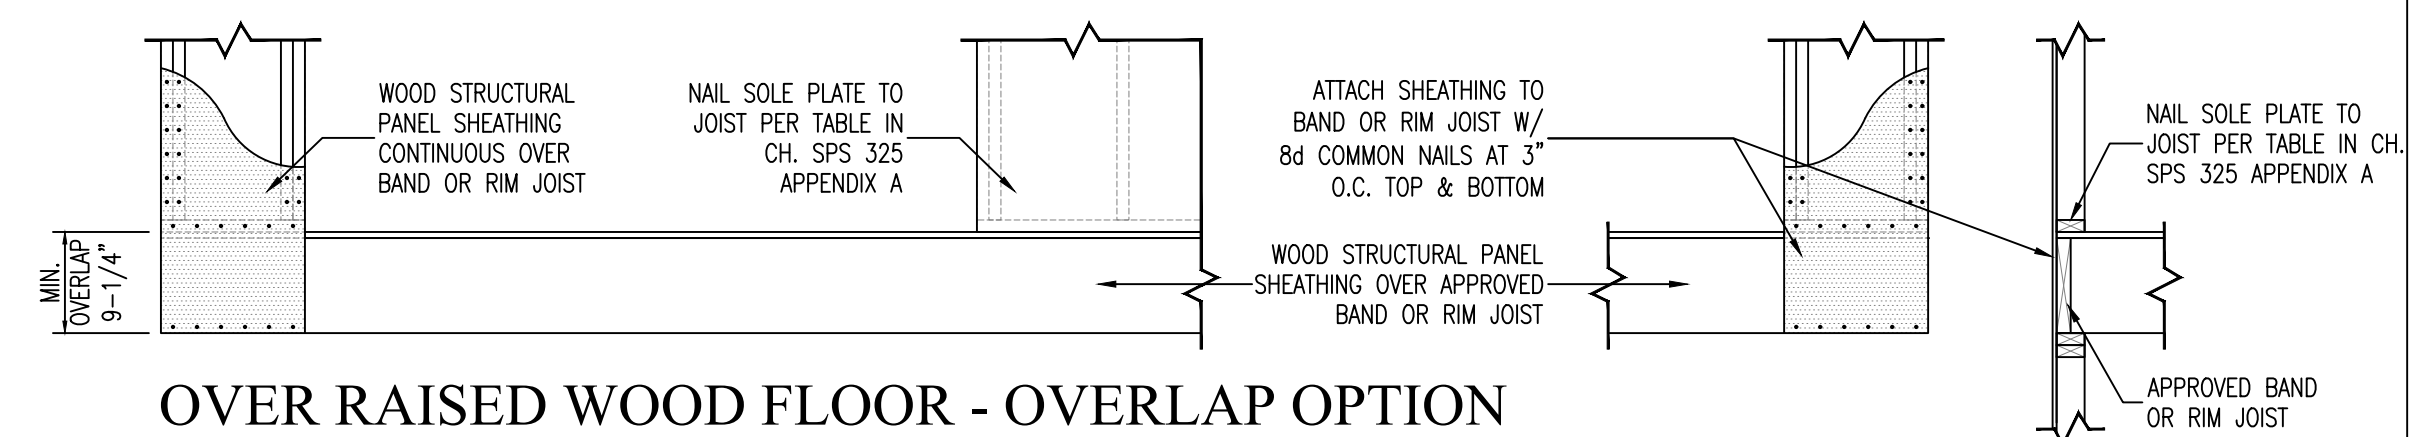

OVER RAISED WOOD FLOOR - OVERLAP OPTION

PORTAL FRAM (PF) DETAILS

SCALE: 1/2" = 1'-0"

CONTRACTOR
INFORMATION



LOOS CUSTOM
HOMES LLC

435 Village Walk Lane
Johnson Creek, WI 53038
PH|920.699.3787
FAX|920.699.7202

WWW.LOOSHOMES.COM

PROJECT
INFORMATION

EDGE FIELD
LOT 46
1233 EDGE FIELD CT.
WATERTOWN, WI 53094

8	----	----	----
7	----	----	----
6	7.14.26	SF UPDATE	KMS
5	7.13.26	PD5	KMS
4	6.24.26	PD4	KMS
3	6.22.26	PD3	KMS
2	5.26.26	PD2	KMS
1	3.17.26	PD1	KMS
NO.	DATE:	DESCRIPTION:	BY:
DRAWN BY:		DATE:	
KMS		3.17.26	


SHEET TITLE

DECK FRAMING
PLAN & DETAILS

JOB NUMBER
26EF46


SHEET NUMBER

D2

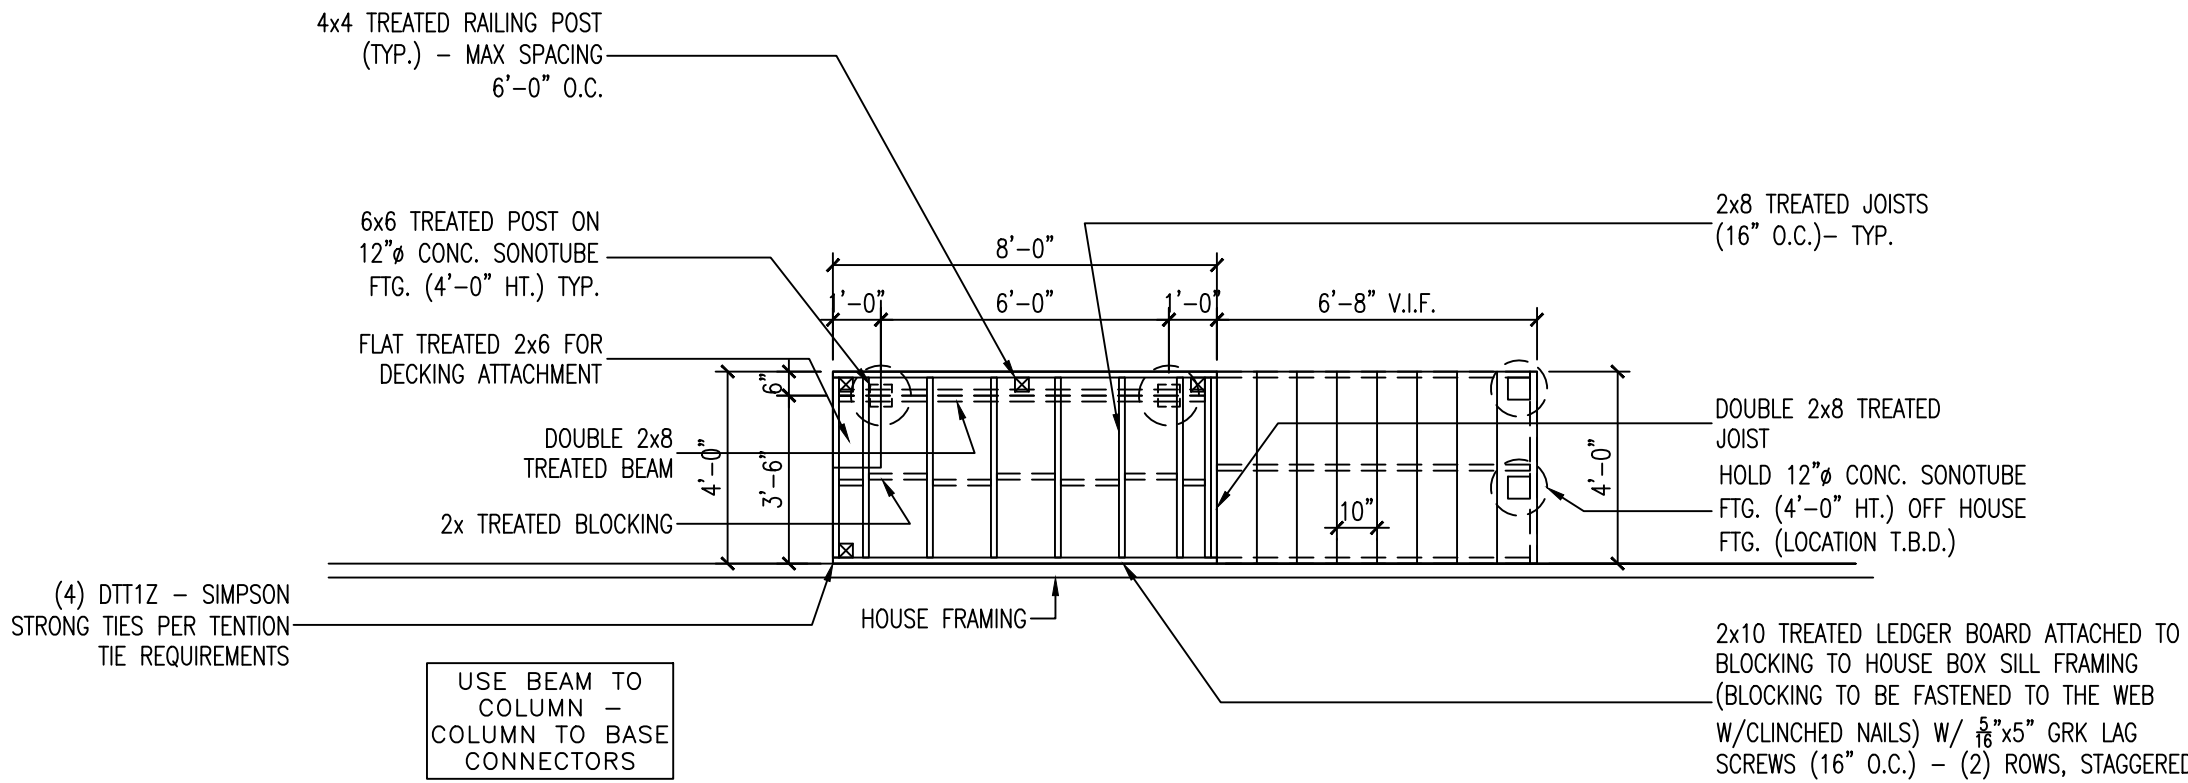


DECK FRAMING PLAN

SCALE: 1/4" = 1'-0"

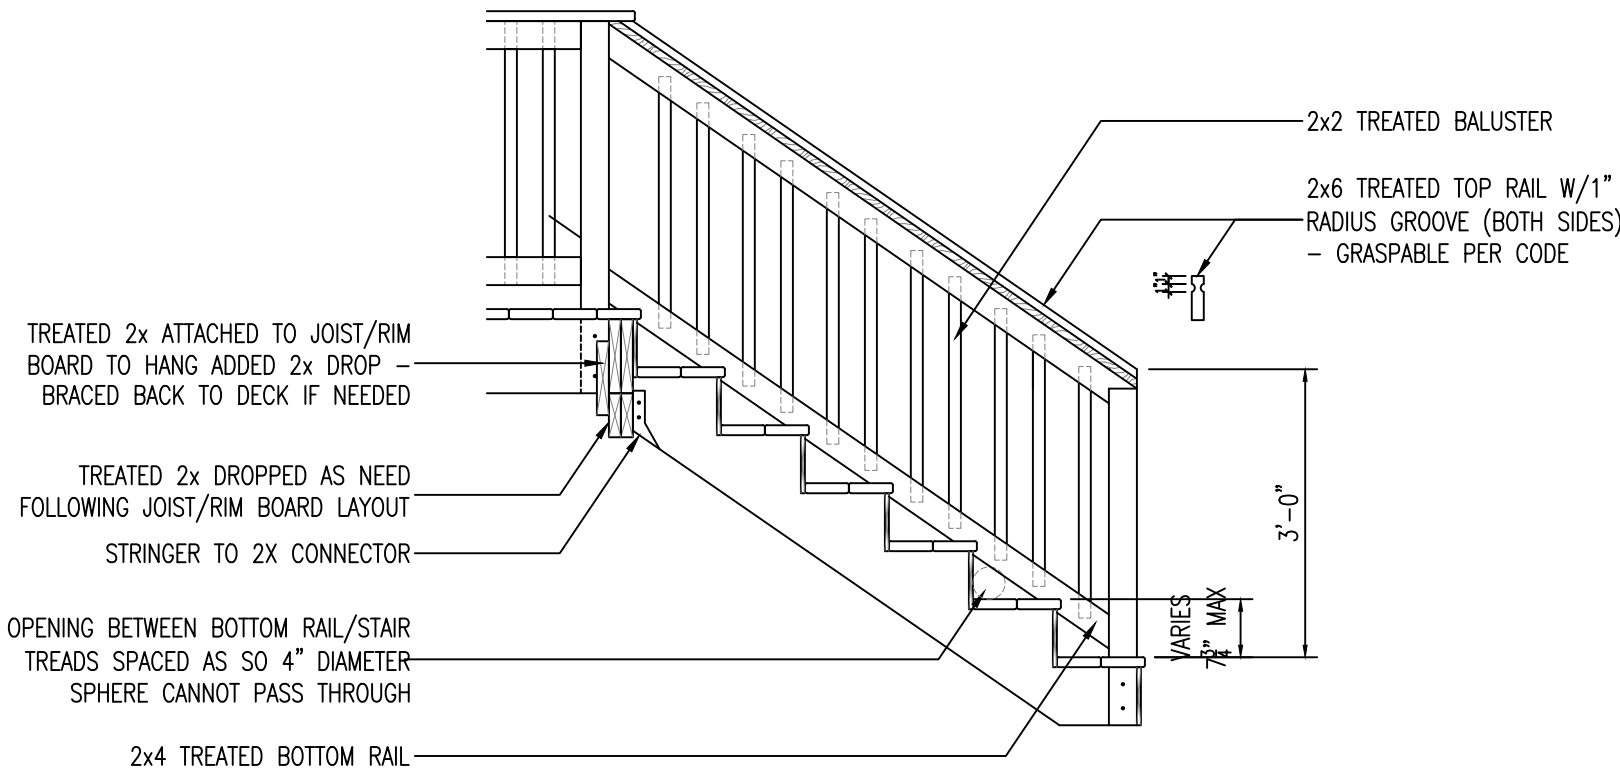


STAIR DETAIL

SCALE: 1/2" = 1'-0"

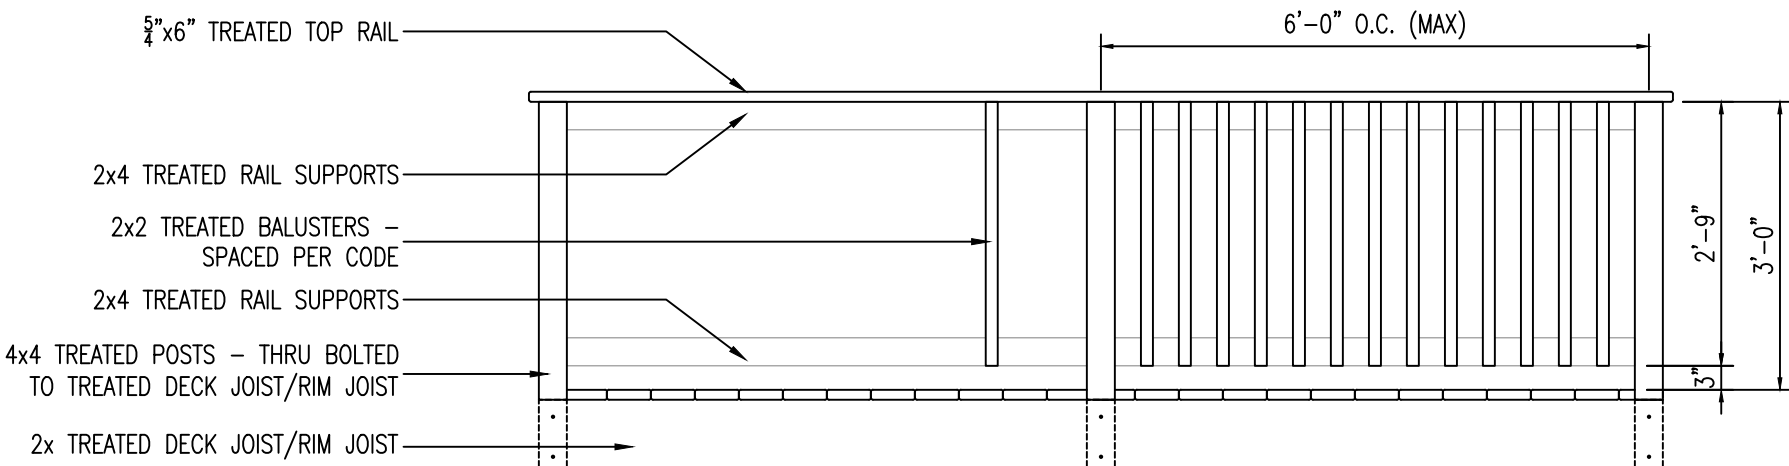

DECK RAILING DETAIL

SCALE: 1/2" = 1'-0"

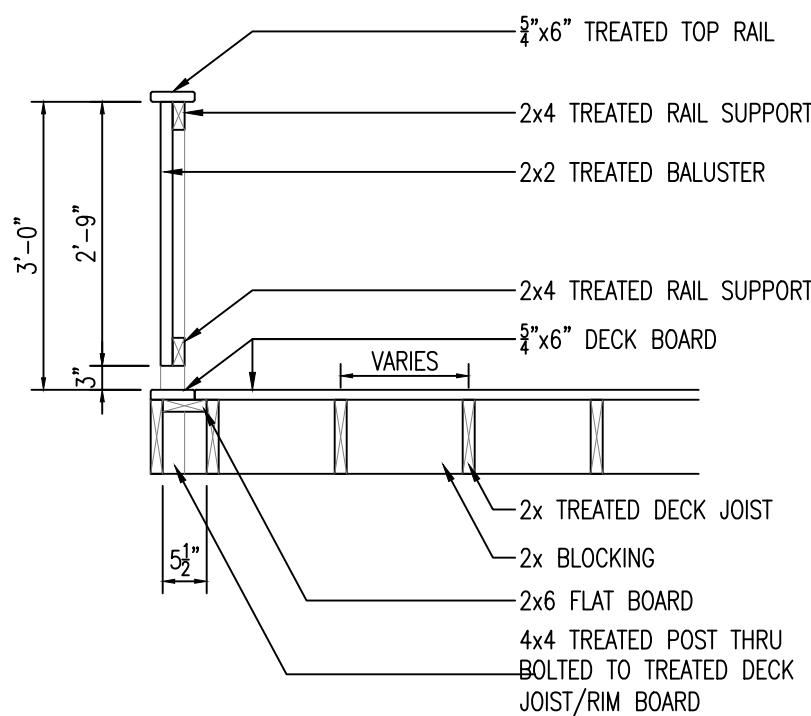

DECK DETAIL

SCALE: 1/2" = 1'-0"