
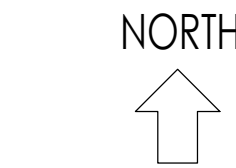


P:\2024\24-230 2875 SPRING ROSE CIRCLE - GRAND RAIL\USE Drawings\GRAND RAIL 32 PLEX REFLECT CEIL 2024 CURRENT.dwg

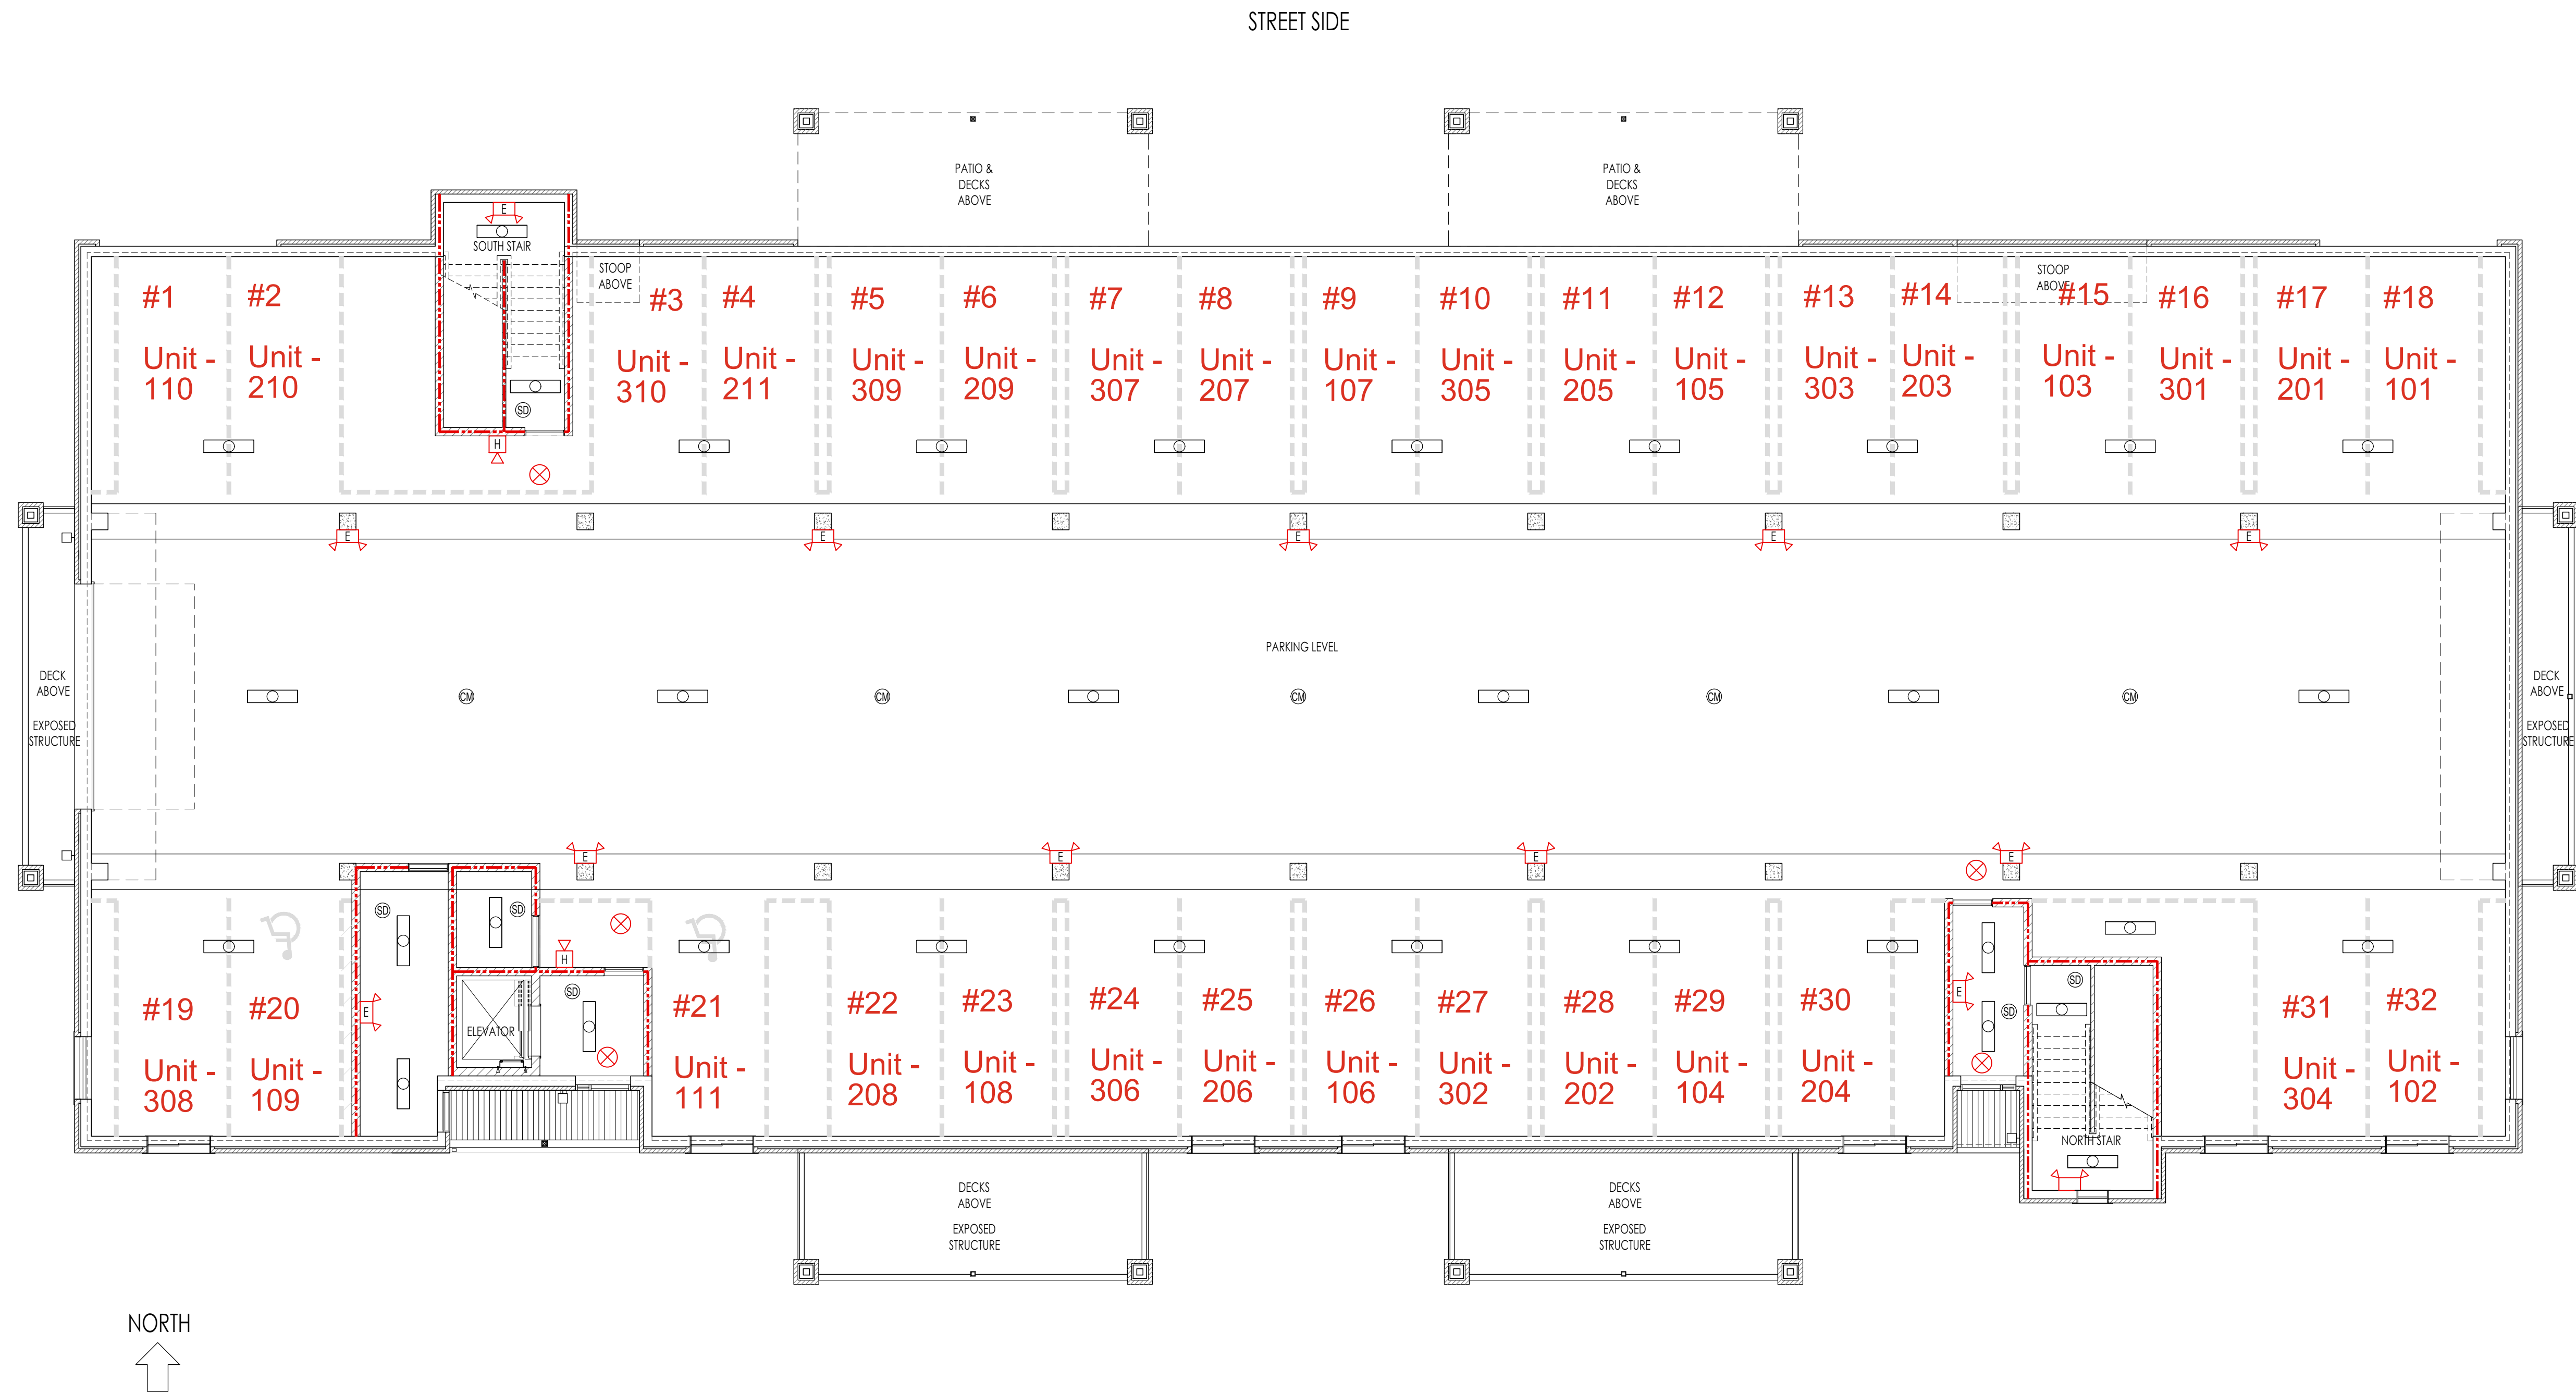

0 GROUND FLOOR REFLECTED CEILING PLAN
14,222 SQ. FT.
Scale: 1/8" = 1'-0"

--- = 1 HOUR FIRE RATED
--- = 2 HOUR FIRE RATED

REFLECTED CEILING PLAN SYMBOLS

- | | | | |
|--|---|--|--|
| | SURFACE MOUNTED 1' X 4' (2) BULB, LED OR FLUORESCENT LIGHT FIXTURE, ELECTRONIC BALLAST / PRIZMATIC LENS | | EXIT LIGHT - AS SHOWN ON PLAN 8'-6" MAX AFF (VERIFY WITH FIRE DEPT.) |
| | EXTERIOR WALL SCONCE LIGHT (NOTE: BATTERY BACKUP AT MAIN ENTRY DOORS) | | EMERGENCY LIGHT - AS SHOWN ON PLAN 8'-6" MAX AFF (VERIFY WITH FIRE DEPARTMENT) |
| | VANITY LIGHT (ABOVE MIRROR) | | GYB, CEILING OR BULKHEAD |
| | 6" DIAMETER RECESSED CAN LIGHT | | HORN/STROBE (VERIFY LOCATIONS) |
| | PORCELAIN LIGHT FIXTURE | | SMOKE DETECTOR PER LOCAL CODE (VERIFY LOCATIONS) |
| | CEILING MOUNTED LIGHT FIXTURE | | CARBON MONOXIDE DETECTOR PER LOCAL CODE (VERIFY QUANTITY AND LOCATIONS) INTAKE AND EXHAUST LOUVERS TO BE DETERMINED. |
| | CEILING MOUNTED PENDANT LIGHT FIXTURE | | ATTIC ACCESS |
| | CEILING FAN WITH LIGHT FIXTURE | | VAULTED CEILING |
| | EXHAUST FAN/LIGHT COMBO | | PRE-FINISHED ALUM. SOFFIT |

606 14TH AVE SW
CEDAR RAPIDS, IA 52404
319-365-1150

2435 KIMBERLY RD.
SUITE 240S
BETTENDORF, IA 52722
563-359-3117

SELECT
STRUCTURAL
SELECT-STRUCTURAL.COM

REVISIONS

#	DATE	BY	DESCRIPTION

THESE PLANS ARE PROPERTY OF SELECT STRUCTURAL ENGINEERING, LLC
NO PART OF THESE PLANS MAY BE REPRODUCED OR TRANSMITTED IN ANY FORM OR BY ANY MEANS, ELECTRONIC OR MECHANICAL, WITHOUT PRIOR AUTHORIZATION
DO NOT MODIFY, ALTER OR DUPLICATE WITHOUT PRIOR AUTHORIZATION



32-PLEX (MULTI-FAMILY)
2875 SPRING ROSE CIRCLE
CORALVILLE, IOWA 52241
GRAND RAIL DEVELOPMENT

DRAWN BY: KRS
CHECKED BY: KRS
APPROVED BY: KRS
JOB DATE: 5-18-2024
JOB NO: 24-230

SHEET TITLE

GROUND FLOOR REFLECTED CEILING PLAN

PAGE NO. A-700